


**SIGN DETAIL**  
1:75

LS-BM-06  
STA. 95+50

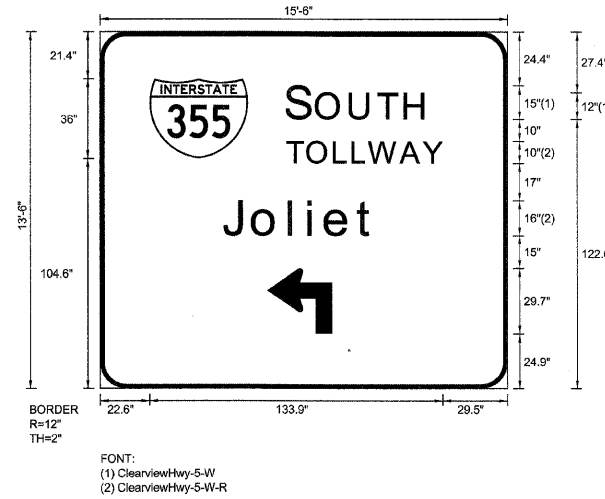

Panel Style: guide\_exp\_advance\_a.ssi  
Dimensions are in inches.tenths

SIGN NUMBER	Right Exit - Ground
WIDTH x HGHT.	15'-6" x 13'-6"
BORDER WIDTH	2"
CORNER RADIUS	12"
MOUNTING	Ground
BACKGROUND	TYPE: Reflective
	COLOR: Green
LEGEND/BORDER	TYPE: Reflective
	COLOR: White/White

SYMBOL	ROT	X	Y	WID	HT
M1_1	0	22.6	104.6	45	36
AR90L1	0	76.2	24.9	29.7	29.7

Letter locations are panel edge to lower left corner

LETTER POSITIONS (X)												LENGTH	SERIESSIZE
S	O	U	T	H									ClearviewHwy-5-W
85.6	99.2	114.6	127.5	139.7								63.3	15,12
T	O	L	L	W	A	Y							ClearviewHwy-5-W-R
85.6	94.8	107	115.4	122.9	137.4	147.7						70.9	10
J	o	l	i	e	t								ClearviewHwy-5-W-R
56.5	70	86.8	95.4	103.2	117.8							69.1	16/13

FILE NAME =	DESIGNED - SEW	REVISED -
*FILEL*	DRAWN - SEW	REVISED -
USER NAME = *USER*	CHECKED - FML	REVISED -
PLOT DATE = *DATE*	DATE - 12/2009	REVISED -



**STATE OF ILLINOIS**  
**DEPARTMENT OF TRANSPORTATION**

SIGNING DETAILS			
SCALE: N.T.S.	SHEET NO. 4 OF 71 SHEETS	STA. TO STA.	

F.A.I. RTE.	SECTION	COUNTY	TOTAL SHEETS	SHEET NO.
* 220	1-1, 2&3/RS-7	DUPAGE	661	586
* 290,355				CONTRACT NO. 60G51
FED. ROAD DIST. NO. [ILLINOIS] FED. AID PROJECT				