


SIGN DETAIL  
1:75

NB-TR-07  
STA. 98+80

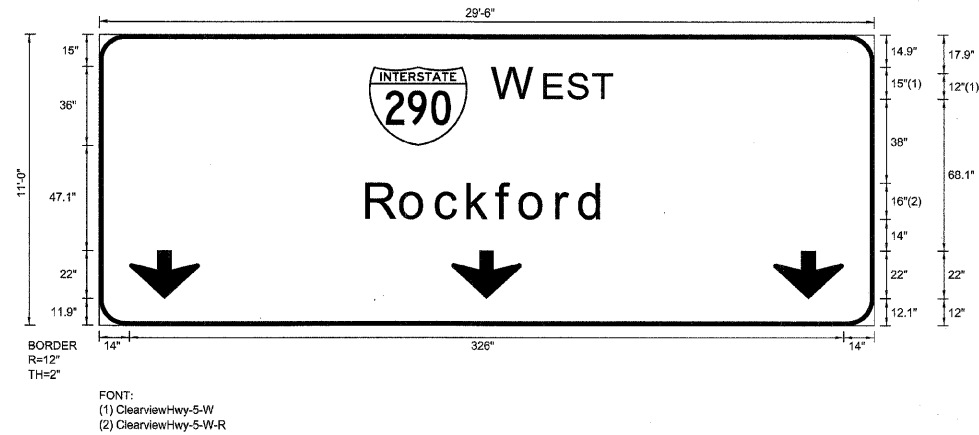

Panel Style: sign\_default.ssi  
Dimensions are in inches.tenths

Letter locations are panel edge to lower left corner

SIGN NUMBER	name
WIDTH x HGHT.	29'-6" x 11'-0"
BORDER WIDTH	2"
CORNER RADIUS	12"
MOUNTING	Overhead
BACKGROUND	TYPE: Reflective COLOR: Green
LEGEND/BORDER	TYPE: Reflective COLOR: White/White

SYMBOL	ROT	X	Y	WID	HT
M1_1	0	123.3	81	45	36
ARROW	0	14	12	32	22
ARROW	0	161	12	32	22
ARROW	0	308	12	32	22

LETTER POSITIONS (X)

														LENGTH	SERIESIZE
W	E	S	T												ClearviewHwy-5-W
180.3	204	214.7	226.1											54.5	15,12
R	o	c	k	f	o	r	d								ClearviewHwy-5-W-R
122.5	138.3	154.4	168.9	182.1	192.8	209.5	219.9							108.9	1613

FILE NAME =	DESIGNED - SEW	REVISED -
\$FILEL\$	DRAWN - SEW	REVISED -
USER NAME = \$USER\$	CHECKED - FML	REVISED -
PLOT DATE = \$DATE\$	DATE - 12/2009	REVISED -



STATE OF ILLINOIS  
DEPARTMENT OF TRANSPORTATION

SIGNING DETAILS

SCALE: N.T.S. SHEET NO. 5 OF 71 SHEETS STA. TO STA.

F.A.I. RTE.	SECTION	COUNTY	TOTAL SHEETS	SHEET NO.
*	22(1, 1-1, 2&3)RS-7	DUPAGE	661	587
* 290,355			CONTRACT NO. 60651	
FED. ROAD DIST. NO. ILLINOIS FED. AID PROJECT				