


SIGN DETAIL
1:75

NB-TR-12
STA. 117+70

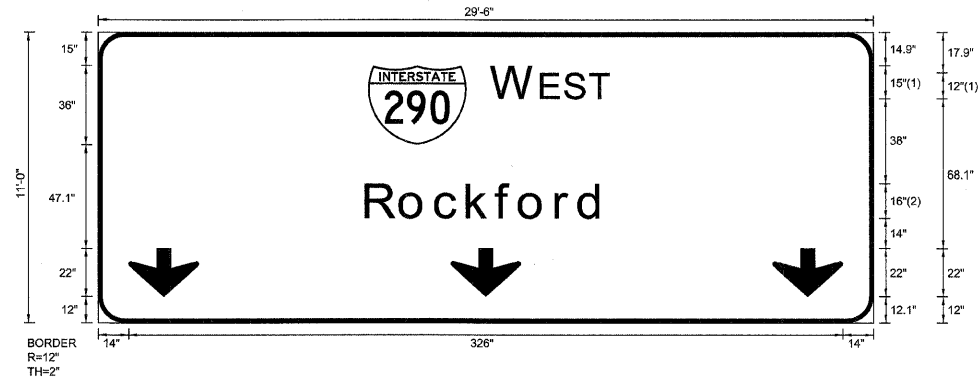

SIGN NUMBER	name
WIDTH x HGHT.	29'-6" x 11'-0"
BORDER WIDTH	2"
CORNER RADIUS	12"
MOUNTING	Overhead
BACKGROUND	TYPE: Reflective COLOR: Green
LEGEND/BORDER	TYPE: Reflective COLOR: White/White

SYMBOL	ROT	X	Y	WID	HT
M1_1	0	123.3	81.1	45	36
ARROW	0	14	12	32	22
ARROW	0	161	12.1	32	22
ARROW	0	308	12	32	22

Panel Style: sign_default.ssi
Dimensions are in inches.tenths

Letter locations are panel edge to lower left corner

LETTER POSITIONS (X)

																				LENGTH	SERIESIZE		
W	E	S	T																		ClearviewHwy-5-W		
180.3	202.9	213.6	225																		53.4	15,12	
R	o	c	k	f	o	r	d															ClearviewHwy-5-W-R	
122.5	138.3	154.4	168.9	182.1	192.8	209.5	219.9															108.9	1613

FILE NAME =	DESIGNED - SEW	REVISED -
\$FILEL\$	DRAWN - SEW	REVISED -
USER NAME = \$USER\$	CHECKED - FML	REVISED -
PLOT DATE = \$DATE\$	DATE - 12/2009	REVISED -



STATE OF ILLINOIS
DEPARTMENT OF TRANSPORTATION

SIGNING DETAILS

SCALE: N.T.S. SHEET NO. 9 OF 71 SHEETS STA. TO STA.

F.A.I. RTE.	SECTION	COUNTY	TOTAL SHEETS	SHEET NO.
*	22(1, 1-1, 2&3)RS-7	DUPAGE	661	591
* 290,355		CONTRACT NO. 60G51		
FED. ROAD DIST. NO.		[ILLINOIS] FED. AID PROJECT		