


SIGN DETAIL
1:75

SB-CL-10
STA. 64+90

SIGN NUMBER	name
WIDTH x HGHT.	20'-0" x 6'-0"
BORDER WIDTH	2"
CORNER RADIUS	9"
MOUNTING	Overhead
BACKGROUND	TYPE: Reflective COLOR: Green
LEGEND/BORDER	TYPE: Reflective COLOR: White,Black&White

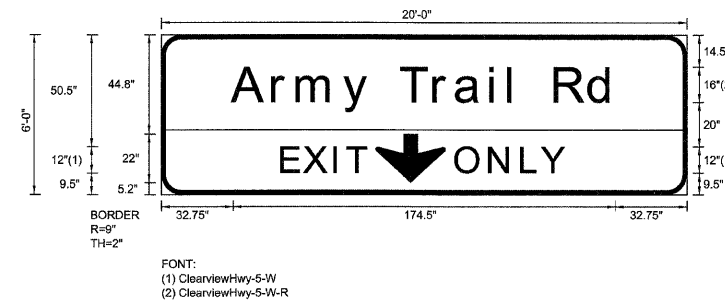

Panel Style: sign_default.ssi
Dimensions are in inches.tenths

Letter locations are panel edge to lower left corner

SYMBOL	ROT	X	Y	WID	HT
ARNDOWN	0	97.8	5.2	32	22

LETTER POSITIONS (X)														LENGTH	SERIESIZE								
A	r	m	y		T	r	a	i	l		R	d									ClearviewHwy-5-W-R		
32.7	51.2	62.2	83.5	95.9	109.6	124.8	134.9	150.5	159	164	180	195.7									174.5	1613	
E	X	I	T																			ClearviewHwy-5-W	
55.4	65.6	79.3	85.2																			38.5	12
O	N	L	Y																			ClearviewHwy-5-W	
134.8	150.3	164.9	174.2																			49.8	12

FILE NAME =	DESIGNED - SEW	REVISED -
#FILE#	DRAWN - SEW	REVISED -
USER NAME = #USER#	CHECKED - FML	REVISED -
PLOT DATE = #DATE#	DATE - 12/2009	REVISED -



STATE OF ILLINOIS
DEPARTMENT OF TRANSPORTATION

SIGNING DETAILS			
SCALE: N.T.S.	SHEET NO. 17 OF 71 SHEETS	STA.	TO STA.

F.A.I. RTE.	SECTION	COUNTY	TOTAL SHEETS	SHEET NO.
*	22(1, 1-1, 2&3)RS-7	DUPAGE	661	599
* 290.355	CONTRACT NO. 60G51			
FED. ROAD DIST. NO.		[ILLINOIS] FED. AID PROJECT		