


SIGN DETAIL
1:75

EB-TR-03
STA. 32+50

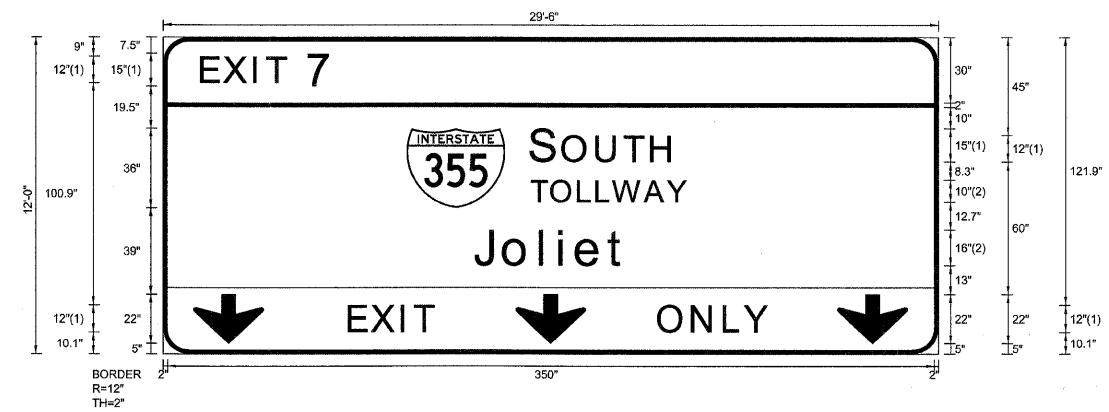

SIGN NUMBER	name
WIDTH x HGHT.	29'-6" x 12'-0"
BORDER WIDTH	2"
CORNER RADIUS	12"
MOUNTING	Overhead
BACKGROUND	TYPE: Reflective COLOR: Green
LEGEND/BORDER	TYPE: Reflective COLOR: White,Black/White

SYMBOL	ROT	X	Y	WID	HT
M1_1	0	111.2	66	45	36
ARROW	0	14	5	32	22
ARROW	0	161	5	32	22
ARROW	0	308	5	32	22

Panel Style: sign_default.ssi
Dimensions are in inches.tenths

FONT:
(1) ClearviewHwy-5-W
(2) ClearviewHwy-5-W-R

Letter locations are panel edge to lower left corner

LETTER POSITIONS (X)										LENGTH	SERIESSIZE
E	X	I	T	7							ClearviewHwy-5-W
18	28.3	41.9	47.9	66.5						59	12,15
S	O	U	T	H							ClearviewHwy-5-W
168.2	183	198.4	211.3	223.5						64.4	15,12
T	O	L	L	W	A	Y					ClearviewHwy-5-W-R
168.2	177.4	189.7	198.1	205.6	220.1	230.4				70.9	10
J	o	l	i	e	t						ClearviewHwy-5-W-R
142.4	155.9	172.7	181.3	189.1	203.7					69.1	16,13
E	X	I	T								ClearviewHwy-5-W
85.4	95.7	109.3	115.3							38.5	12
O	N	L	Y								ClearviewHwy-5-W
226.7	242.1	256.8	266							49.8	12

FILE NAME =	DESIGNED - SEW	REVISED -
*FILEL#	DRAWN - SEW	REVISED -
USER NAME = *USER*	CHECKED - FML	REVISED -
PLOT DATE = *DATE*	DATE - 12/2009	REVISED -



STATE OF ILLINOIS
DEPARTMENT OF TRANSPORTATION

SIGNING DETAILS

SCALE: N.T.S. SHEET NO. 24 OF 71 SHEETS STA. TO STA.

F.A.I. RTE.	SECTION	COUNTY	TOTAL SHEETS	SHEET NO.
*	2201, 1-1, 2&3/RS-7	DUPAGE	661	606
* 290,355			CONTRACT NO. 60C51	
FED. ROAD DIST. NO.		[ILLINOIS] FED. AID PROJECT		