


SIGN DETAIL  
1:75

EB-BM-05  
STA. 22+50

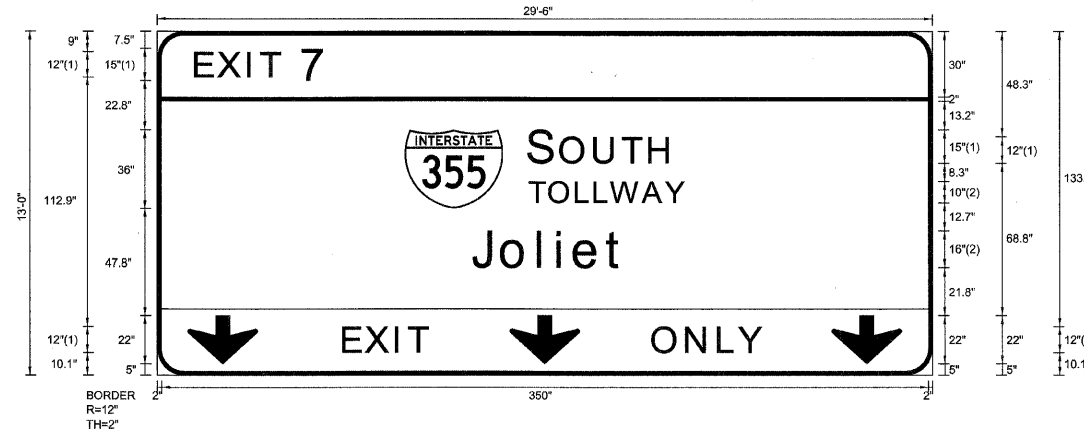

SIGN NUMBER	name
WIDTH x HGHT.	29'-6" x 13'-0"
BORDER WIDTH	2"
CORNER RADIUS	12"
MOUNTING	Overhead
BACKGROUND	TYPE: Reflective COLOR: Green
LEGEND/BORDER	TYPE: Reflective COLOR: White,Black/White

SYMBOL	ROT	X	Y	WID	HT
M1_1	0	113	74.8	45	36
ARROW	0	14	5	32	22
ARROW	0	161	5	32	22
ARROW	0	308	5	32	22

Panel Style: sign\_default.ssi  
Dimensions are in inches.tenths

FONT:  
(1) ClearviewHwy-5-W  
(2) ClearviewHwy-5-W-R

Letter locations are panel edge to lower left corner

LETTER POSITIONS (X)

		LETTER POSITIONS (X)					LENGTH	SERIESSIZE
E	X	I	T	7				ClearviewHwy-5-W
18	28.3	41.9	47.9	66.5			59	12,15
S	O	U	T	H				ClearviewHwy-5-W
170	184.8	200.2	213.1	225.3			64.4	15,12
T	O	L	L	W	A	Y		ClearviewHwy-5-W-R
170	179.2	191.5	199.9	207.4	221.9	232.2	70.9	10
J	o	l	i	e	t			ClearviewHwy-5-W-R
144.2	157.7	174.5	183.1	190.9	205.5		69.1	16,13
E	X	I	T					ClearviewHwy-5-W
85.4	95.7	109.3	115.3				38.5	12
O	N	L	Y					ClearviewHwy-5-W
226.7	242.1	256.8	266				49.8	12

FILE NAME =	DESIGNED - SEW	REVISED -
#FILEL#	DRAWN - SEW	REVISED -
USER NAME = #USER#	CHECKED - FML	REVISED -
PLOT DATE = #DATE#	DATE - 12/2009	REVISED -



STATE OF ILLINOIS  
DEPARTMENT OF TRANSPORTATION

SIGNING DETAILS

SCALE: N.T.S. SHEET NO. 26 OF 71 SHEETS STA. TO STA.

F.A.I. RTE.	SECTION	COUNTY	TOTAL SHEETS	SHEET NO.
*	22(1, 1-1, 2&3)RS-7	DUPAGE	661	608
* 290,355			CONTRACT NO. 60G51	
FED. ROAD DIST. NO. [ILLINOIS] FED. AID PROJECT				