


SIGN DETAIL  
1:75

EB-TR-07  
STA. 14+95

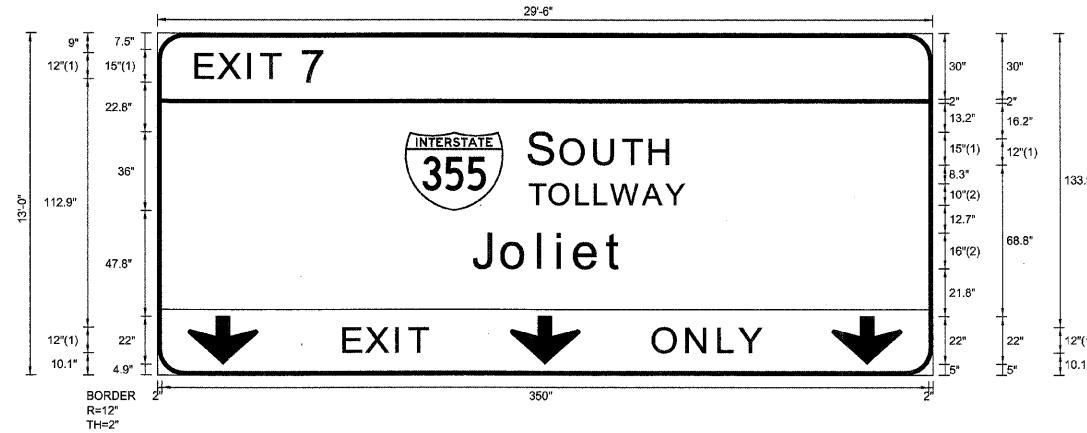

SIGN NUMBER	name
WIDTH x HGHT.	29'-6" x 13'-0"
BORDER WIDTH	2"
CORNER RADIUS	12"
MOUNTING	Overhead
BACKGROUND	TYPE: Reflective COLOR: Green
LEGEND/BORDER	TYPE: Reflective COLOR: White,BlackWhite

SYMBOL	ROT	X	Y	WID	HT
M1_1	0	113	74.8	45	36
ARROW	0	14	5	32	22
ARROW	0	161	5	32	22
ARROW	0	308	5	32	22

Panel Style: sign\_default.ssi  
Dimensions are in inches.tenths

FONT:  
(1) ClearviewHwy-5-W  
(2) ClearviewHwy-5-W-R

Letter locations are panel edge to lower left corner

LETTER POSITIONS (X)

						LENGTH	SERIESSIZE	
E	X	I	T	7		59	ClearviewHwy-5-W 12,15	
18	28.3	41.9	47.9	66.5				
S	O	U	T	H		64.4	ClearviewHwy-5-W 15,12	
170	184.8	200.2	213.1	225.3				
T	O	L	L	W	A	Y	70.9	ClearviewHwy-5-W-R 10
170	179.2	191.5	199.9	207.4	221.9	232.2		
J	o	l	i	e	t		69.1	ClearviewHwy-5-W-R 1613
144.2	157.7	174.5	183.1	190.9	205.5			
E	X	I	T				38.5	ClearviewHwy-5-W 12
85.4	95.7	109.3	115.3					
O	N	L	Y				49.8	ClearviewHwy-5-W 12
226.7	242.1	256.8	266					

FILE NAME =	DESIGNED - SEW	REVISED -
*FILEL*	DRAWN - SEW	REVISED -
USER NAME = *USERS*	CHECKED - FML	REVISED -
PLOT DATE = *DATE*	DATE - 12/2009	REVISED -



STATE OF ILLINOIS  
DEPARTMENT OF TRANSPORTATION

SIGNING DETAILS

SCALE: N.T.S. SHEET NO. 28 OF 71 SHEETS STA. TO STA.

F.A.I. RTE.	SECTION	COUNTY	TOTAL SHEETS	SHEET NO.
*	22(1, 1-1, 2&3)RS-7	DUPAGE	661	610
*	290,355	CONTRACT NO.	60G51	
FED. ROAD DIST. NO. ILLINOIS FED. AID PROJECT				