


SIGN DETAIL  
1:75

WB-CL-06  
STA. 0+10

SIGN NUMBER	name
WIDTH x HGHT.	19'-0" x 9'-6"
BORDER WIDTH	2"
CORNER RADIUS	12"
MOUNTING	Overhead
BACKGROUND	TYPE: Reflective COLOR: Green
LEGEND/BORDER	TYPE: Reflective COLOR: White/White

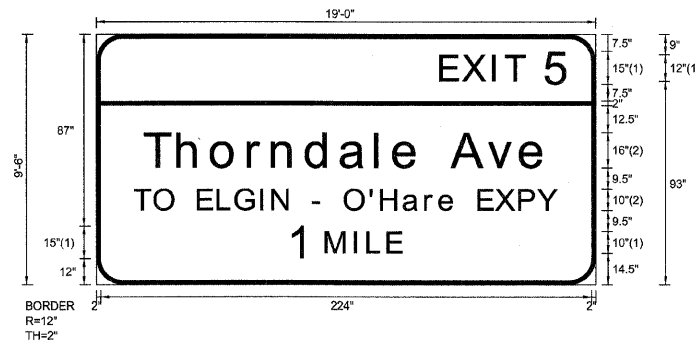

FONT:  
(1) ClearviewHwy-S-W  
(2) ClearviewHwy-S-W-R

Panel Style: sign\_default.ssi  
Dimensions are in inches.tenths

Letter locations are panel edge to lower left corner

SYMBOL	ROT	X	Y	WID	HT

LETTER POSITIONS (X)

																				LENGTH	SERIESSIZE		
E	X	I	T	5																	ClearviewHwy-5-W		
157.6	167.9	181.6	187.5	206.1																58.8	12,15		
T	h	o	r	n	d	a	l	e		A	v	e									ClearviewHwy-5-W-R		
22.2	37.4	53	69.7	80.7	96.3	112	127.9	136.2	147.9	162.7	179.3	194							183.5	1613			
T	O		E	L	G	I	N		-	O	'	H	a	r	e		E	X	P	Y		ClearviewHwy-5-W-R	
17.5	26.7	35.9	46.4	55.5	63.6	75.2	80.5	88.7	99.4	103.3	113.5	125.2	130	140.4	150.4	156.8	164.2	174.5	182.5	193.3	201.8	193.1	108.1
1	M	I	L	E																			ClearviewHwy-5-W
88.4	105.2	118.3	124.2	133.3																		51.2	15,10

FILE NAME =	DESIGNED - SEW	REVISED -
*FILEL*	DRAWN - SEW	REVISED -
USER NAME = *USER*	CHECKED - FML	REVISED -
PLOT DATE = *DATE*	DATE - 12/2009	REVISED -



STATE OF ILLINOIS  
DEPARTMENT OF TRANSPORTATION

SIGNING DETAILS

SCALE: N.T.S. SHEET NO. 46 OF 71 SHEETS STA. TO STA.

F.A.I. RTE.	SECTION	COUNTY	TOTAL SHEETS	SHEET NO.
*	221, 1-1, 2&3RS-7	DUPAGE	661	628
* 290,355		CONTRACT NO. 60G51		
FED. ROAD DIST. NO.		[ILLINOIS] FED. AID PROJECT		