


SIGN DETAIL
1:75

WB-TR-10
STA. 28+40

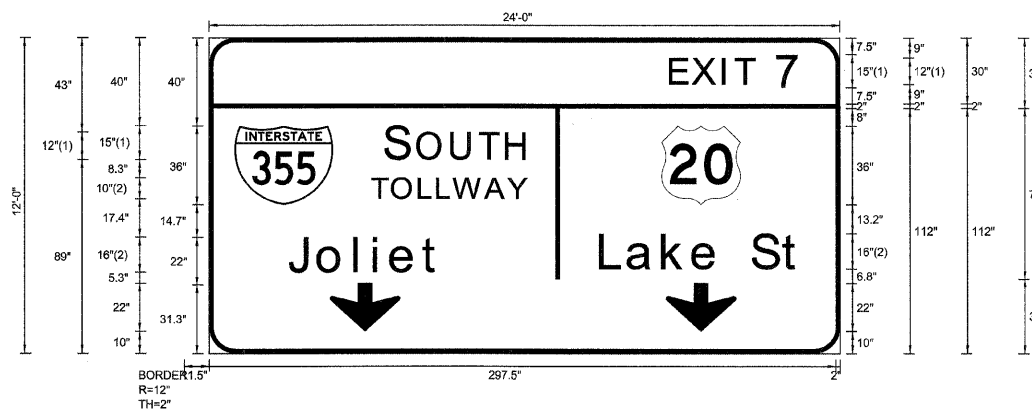

| | |
|---------------|--|
| SIGN NUMBER | name |
| WIDTH x HGHT. | 24'-0" x 12'-0" |
| BORDER WIDTH | 2" |
| CORNER RADIUS | 12" |
| MOUNTING | Overhead |
| BACKGROUND | TYPE: Reflective COLOR: Green |
| LEGEND/BORDER | TYPE: Reflective COLOR: White/White |

| SYMBOL | ROT | X | Y | WID | HT |
|--------|-----|-------|----|-----|----|
| M1_1 | 0 | 11.5 | 68 | 45 | 36 |
| M1_4 | 0 | 206.5 | 68 | 36 | 36 |
| ARDOWN | 0 | 55.1 | 10 | 32 | 22 |
| ARDOWN | 0 | 208.5 | 10 | 32 | 22 |

Panel Style: sign_default.ssi
Dimensions are in inches.tenths

FONT:
(1) ClearviewHwy-5-W
(2) ClearviewHwy-5-W-R

Letter locations are panel edge to lower left corner

LETTER POSITIONS (X)

| | | | | | | | | | | | | LENGTH | SERIESSIZE |
|-------|-------|-------|-------|-------|-------|-------|--|--|--|--|--|--------|--------------------|
| E | X | I | T | 7 | | | | | | | | | ClearviewHwy-5-W |
| 211 | 221.3 | 234.9 | 240.9 | 259.5 | | | | | | | | 59 | 12,15 |
| S | O | U | T | H | | | | | | | | | ClearviewHwy-5-W |
| 80.8 | 95.5 | 111 | 123.8 | 136.1 | | | | | | | | 64.4 | 15,12 |
| T | O | L | L | W | A | Y | | | | | | | ClearviewHwy-5-W-R |
| 74.3 | 83.5 | 95.7 | 104.2 | 111.6 | 126.1 | 136.5 | | | | | | 70.9 | 10 |
| L | a | k | e | S | t | | | | | | | | ClearviewHwy-5-W-R |
| 178.9 | 191.3 | 207.3 | 221.1 | 232.9 | 248.2 | 262.3 | | | | | | 91.2 | 1613 |
| J | o | l | i | e | t | | | | | | | | ClearviewHwy-5-W-R |
| 36.5 | 50 | 66.8 | 75.3 | 83.2 | 97.8 | | | | | | | 69.1 | 1613 |

| | | |
|--------------------|----------------|-----------|
| FILE NAME = | DESIGNED - SEW | REVISED - |
| *FILEL* | DRAWN - SEW | REVISED - |
| USER NAME = *LSER* | CHECKED - FML | REVISED - |
| PLOT DATE = *DATE* | DATE - 12/2009 | REVISED - |



STATE OF ILLINOIS
DEPARTMENT OF TRANSPORTATION

SIGNING DETAILS

SCALE: N.T.S. SHEET NO. 49 OF 71 SHEETS STA. TO STA.

| | | | | |
|---------------------|---------------------|------------------|--------------|-----------|
| F.A.I. RTE. | SECTION | COUNTY | TOTAL SHEETS | SHEET NO. |
| * | 22(1, 1-1, 2&3)RS-7 | DUPAGE | 661 | 631 |
| * 290,355 | CONTRACT NO. 60G51 | | | |
| FED. ROAD DIST. NO. | ILLINOIS | FED. AID PROJECT | | |