


SIGN DETAIL
1:75

83-BM-17
STA. 205+25

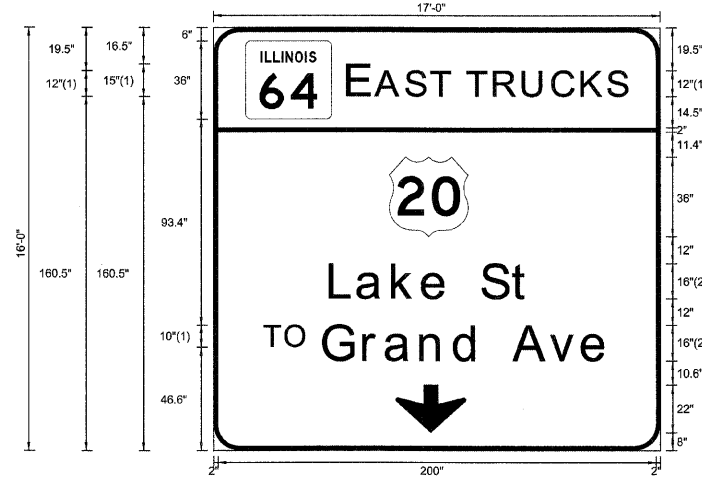

SIGN NUMBER	name
WIDTH x HGHT.	17'-0" x 16'-0"
BORDER WIDTH	2"
CORNER RADIUS	12"
MOUNTING	Overhead
BACKGROUND	TYPE: Reflective COLOR: Green
LEGEND/BORDER	TYPE: Reflective COLOR: White/White

SYMBOL	ROT	X	Y	WID	HT
M1-100A-2-22-10D		14.7	150	39.3	36
M1_4	0	80.3	96.6	36	36
ARDOWN	0	83.2	8	32	22

Panel Style: sign_default.ssi
Dimensions are in inches.tenths

FONT:
(1) ClearviewHwy-5-W
(2) ClearviewHwy-5-W-R

Letter locations are panel edge to lower left corner

LETTER POSITIONS (X)

										LENGTH	SERIESSIZE
E	A	S	T								ClearviewHwy-5-W
62	74.7	88.4	99.8							46.5	15,12
T	R	U	C	K	S						ClearviewHwy-5-W
116.5	128.7	141.8	155.4	168.8	180.7					72.9	12
L	a	k	e		S	t					ClearviewHwy-5-W-R
53.7	66	82	95.8	107.6	122.9	137				91.2	1613
T	O										ClearviewHwy-5-W
23.5	33.3									19.1	10
G	r	a	n	d		A	v	e			ClearviewHwy-5-W-R
50.5	68.9	79	95	110.5	122	137.5	154.1	168.8		130	1613

FILE NAME =	DESIGNED - SEW	REVISED -
FILEL	DRAWN - SEW	REVISED -
USER NAME = *USER*	CHECKED - FML	REVISED -
PLOT DATE = *DATE*	DATE - 12/2009	REVISED -



STATE OF ILLINOIS
DEPARTMENT OF TRANSPORTATION

SIGNING DETAILS

SCALE: N.T.S. SHEET NO. 57 OF 71 SHEETS STA. TO STA.

F.A.I. RTE.	SECTION	COUNTY	TOTAL SHEETS	SHEET NO.
22(1, 1-1, 2&3)RS-7	DUPAGE	661	639	
* 290,355		CONTRACT NO. 60C51		
FED. ROAD DIST. NO.		ILLINOIS FED. AID PROJECT		