


SIGN DETAIL
1:75

WB-TR-62
STA. 505+00

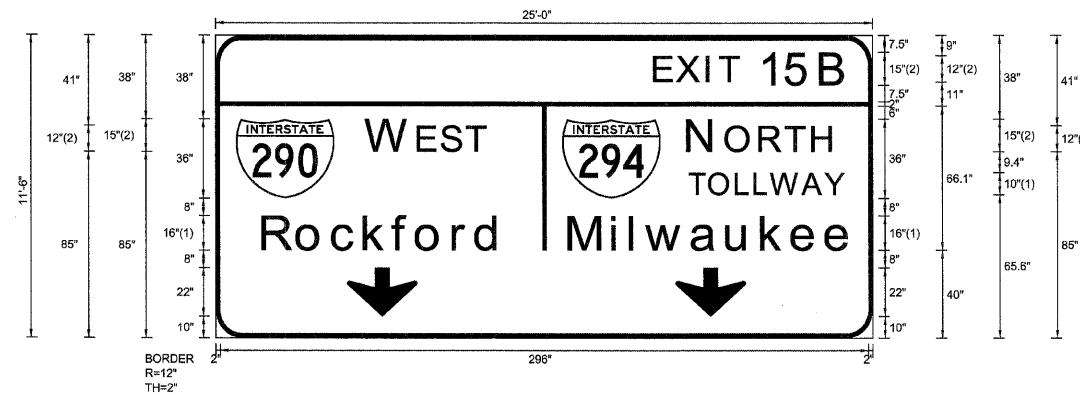

FONT:
(1) ClearviewHwy-S-W-R
(2) ClearviewHwy-S-W

Panel Style: sign_default.ssi
Dimensions are in inches.tenths

Letter locations are panel edge to lower left corner

SIGN NUMBER	name
WIDTH x HIGHT.	25'-0" x 11'-6"
BORDER WIDTH	2"
CORNER RADIUS	12"
MOUNTING	Overhead
BACKGROUND	TYPE: Reflective COLOR: Green
LEGEND/BORDER	TYPE: Reflective COLOR: White/White

SYMBOL	ROT	X	Y	WID	HT
M1_1	0	9.2	64	45	36
M1_1	0	158.2	64	45	36
ARDOWN	0	60	10	32	22
ARDOWN	0	210	10	32	22

LETTER POSITIONS (X)

LETTER	X	Y	WID	HT	SERIES/SIZE				
E	200.9	211.2	224.8	230.8	249.4	261.4	277.1	87.5	12,15
X									
I									
T									
1									
5									
B									
W	69.2	92.9	103.7	115.1				54.5	15,12
E									
S									
T									
N	216.3	233.5	248.9	260.8	273.1			65.9	15,12
O									
R									
T									
H									
T	216.3	225.5	237.8	246.2	253.6	268.1	278.5	70.9	10
O									
L									
L									
W									
A									
Y									
R	21.8	37.5	53.6	68.1	81.3	92	108.8	108.9	16/13
o									
c									
k									
f									
o									
r									
d									
M	161.7	181.3	189.7	196.9	217.7	233.7	249.6	263.5	279
i									
l									
w									
a									
u									
k									
e									
e									

FILE NAME =	DESIGNED - SEW	REVISED -
#FILE.#	DRAWN - SEW	REVISED -
USER NAME = #USER#	CHECKED - FML	REVISED -
PLOT DATE = #DATE#	DATE - 12/2009	REVISED -



STATE OF ILLINOIS
DEPARTMENT OF TRANSPORTATION

SIGNING DETAILS

SCALE: N.T.S. SHEET NO. 38 OF 77 SHEETS STA. TO STA.

F.A.I. RTE.	SECTION	COUNTY	TOTAL SHEETS	SHEET NO.
290	(3031.1, ETC., 3838)RS-5	COOK	413	366
FED. ROAD DIST. NO. ILLINOIS FED. AID PROJECT			CONTRACT NO. 60G52	