


SIGN DETAIL  
1:75

WB-TR-69  
STA. 546+40

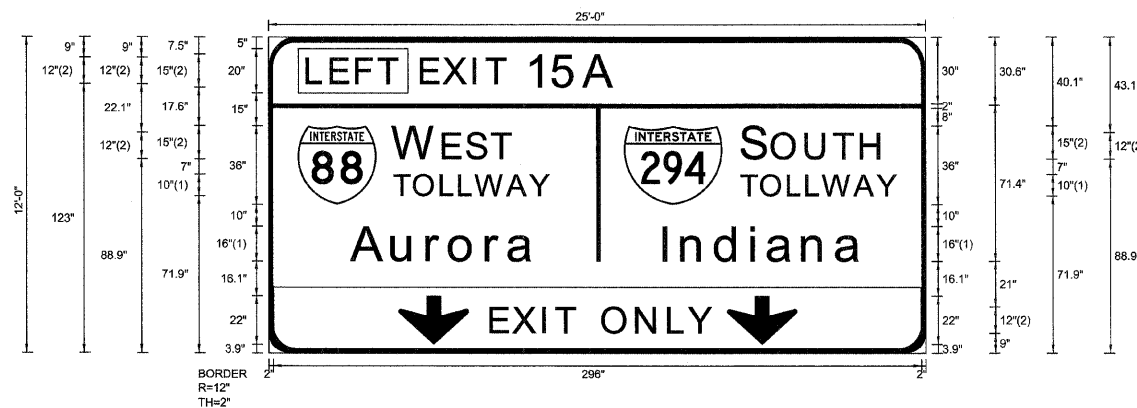

Panel Style: sign\_default.ssi  
Dimensions are in inches.tenths

FONT:  
(1) ClearviewHwy-S-W-R  
(2) ClearviewHwy-S-W

Letter locations are panel edge to lower left corner

SIGN NUMBER	name
WIDTH x HIGHT.	25'-0" x 12'-0"
BORDER WIDTH	2"
CORNER RADIUS	12"
MOUNTING	Overhead
BACKGROUND	TYPE: Reflective
	COLOR: Green
LEGEND/BORDER	TYPE: Reflective
	COLOR: White,Black/White

SYMBOL	ROT	X	Y	WID	HT
M1_1	0	13.2	68	36	36
M1_1	0	162.2	68	45	36
ARDOWN	0	59.3	3.9	32	22
ARDOWN	0	209.3	3.9	32	22

LETTER POSITIONS (X)

										LENGTH	SERIES/SIZE
L	E	F	T								ClearviewHwy-5-W
18	28.8	40.5	50.6							41.2	12
E	X	I	T	1	5	A					ClearviewHwy-5-W
70.1	80.4	94.1	100	118.6	130.6	144.7				88.6	12,15
W	E	S	T								ClearviewHwy-5-W
57.2	80.1	90.9	102.3							53.7	15,12
S	O	U	T	H							ClearviewHwy-5-W
216.5	230.4	245.8	258.7	270.9						63.6	15,12
T	O	L	L	W	A	Y					ClearviewHwy-5-W-R
57.2	66.4	78.7	87.1	94.6	109.1	119.4				70.9	10
T	O	L	L	W	A	Y					ClearviewHwy-5-W-R
215.9	225	237.3	245.7	253.2	267.7	278				70.9	10
A	u	r	o	r	a						ClearviewHwy-5-W-R
38.1	56.6	72.6	83	99.7	109.8					83.5	16/13
I	n	d	i	a	n	a					ClearviewHwy-5-W-R
180.5	188.9	204.4	220.7	228.2	244.2	259.4				90.8	16/13
E	X	I	T	O	N	L	Y				ClearviewHwy-5-W
101.7	112	125.6	131.6	140.2	152.9	168.3	182.9	192.2		101	12

FILE NAME =	DESIGNED - SEW	REVISED -
\$FILEL\$	DRAWN - SEW	REVISED -
USER NAME = \$USER\$	CHECKED - FML	REVISED -
PLOT DATE = \$DATE\$	DATE - 12/2009	REVISED -



STATE OF ILLINOIS  
DEPARTMENT OF TRANSPORTATION

SIGNING DETAILS

SCALE: N.T.S. SHEET NO. 44 OF 77 SHEETS STA. TO STA.

F.A.I. RTE.	SECTION	COUNTY	TOTAL SHEETS	SHEET NO.
290	(3031.1, ETC., 3838RS-5	COOK	413	372
FED. ROAD DIST. NO. ILLINOIS FED. AID PROJECT			CONTRACT NO. 60652	