


SIGN DETAIL
1:75

EB-BM-127
STA. 1184+20

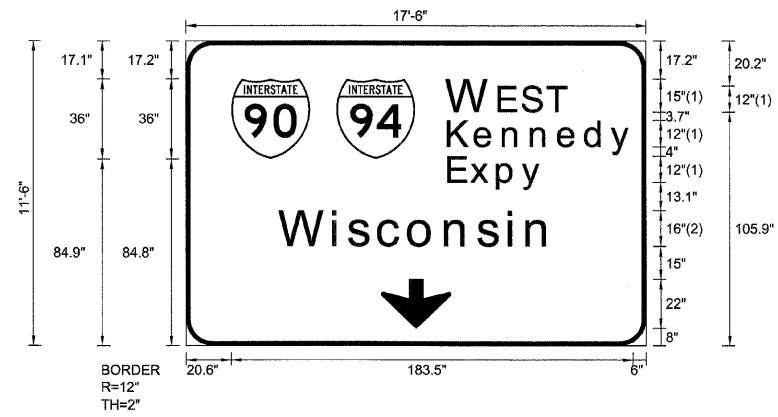

SIGN NUMBER	name
WIDTH x HGHT.	17'-6" x 11'-6"
BORDER WIDTH	2"
CORNER RADIUS	12"
MOUNTING	Overhead
BACKGROUND	TYPE: Reflective COLOR: Green
LEGEND/BORDER	TYPE: Reflective COLOR: White/White

SYMBOL	ROT	X	Y	WID	HT
M1_1	0	20.6	84.8	36	36
M1_1	0	68.6	84.9	36	36
ARDOWN	0	89	8	32	22

Panel Style: sign_default.ssi
Dimensions are in inches.tenths

FONT:
(1) ClearviewHwy-5-W
(2) ClearviewHwy-5-W-R

Letter locations are panel edge to lower left corner

LETTER POSITIONS (X)

										LENGTH	SERIESSIZE
W	E	S	T								ClearviewHwy-5-W
119.6	143.3	154	165.5							54.5	15,12
K	e	n	n	e	d	y					ClearviewHwy-5-W
120.3	132.5	145.3	158.2	170.5	182.9	194.7				83.8	129.8
E	x	p	y								ClearviewHwy-5-W
120.4	130.4	142.7	154							42.9	129.8
W	i	s	c	o	n	s	i	n			ClearviewHwy-5-W-R
42.9	67.4	74.5	88.2	102	118.8	133.5	147.5	156		124.1	1613

FILE NAME =	DESIGNED - SEW	REVISED -
#FILE#	DRAWN - SEW	REVISED -
USER NAME = #USER#	CHECKED - SEW	REVISED -
PLOT DATE = #DATE#	DATE - 12/2009	REVISED -



STATE OF ILLINOIS
DEPARTMENT OF TRANSPORTATION

SIGNING DETAILS

SCALE: N.T.S. SHEET NO. 26 OF 79 SHEETS STA. TO STA.

F.A.I. RTE.	SECTION	COUNTY	TOTAL SHEETS	SHEET NO.
290	(2828B,D, ETC., 3031, IRS-6	COOK	300	239
FED. ROAD DIST. NO. ILLINOIS FED. AID PROJECT			CONTRACT NO. 60653	