


SIGN DETAIL
1:75

EB-TR-29
STA. 335+40

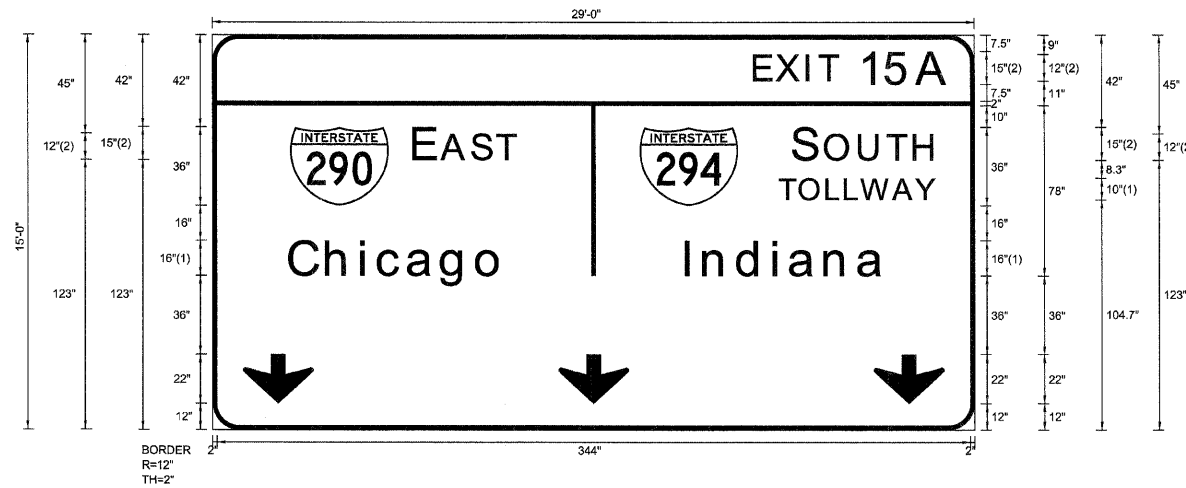

Panel Style: sign_default.ssi
Dimensions are in inches.tenths

FONT:
(1) ClearviewHwy-5-W-R
(2) ClearviewHwy-5-W

Letter locations are panel edge to lower left corner

SIGN NUMBER	name
WIDTH x HGHT.	29'-0" x 15'-0"
BORDER WIDTH	2"
CORNER RADIUS	12"
MOUNTING	Overhead
BACKGROUND	TYPE: Reflective
	COLOR: Green
LEGEND/BORDER	TYPE: Reflective
	COLOR: WhiteWhite

SYMBOL	ROT	X	Y	WID	HT
M1_1	0	35.5	102	45	36
M1_1	0	195	102	45	36
ARROW	0	14	12	32	22
ARROW	0	158	12	32	22
ARROW	0	302	12	32	22

LETTER POSITIONS (X)

							LENGTH	SERIESSIZE
E	X	I	T	1	5	A		ClearviewHwy-5-W
247.9	258.1	271.8	277.7	296.4	308.3	322.4	88.6	12,15
E	A	S	T					ClearviewHwy-5-W
92.5	105.2	119	130.4				46.5	15,12
S	O	U	T	H				ClearviewHwy-5-W
265.6	280.3	295.7	308.6	320.8			64.4	15,12
T	O	L	L	W	A	Y		ClearviewHwy-5-W-R
259.1	268.3	280.5	289	296.4	310.9	321.3	70.9	10
C	h	i	c	a	g	o		ClearviewHwy-5-W-R
35.5	52.3	68.2	76	89.5	104.9	121	97.8	1613
I	n	d	i	a	n	a		ClearviewHwy-5-W-R
216.2	224.6	240.1	256.5	264	280	295.2	90.8	1613

FILE NAME =	DESIGNED - SEW	REVISED -
FILEL	DRAWN - SEW	REVISED -
USER NAME = \$USERS	CHECKED - FML	REVISED -
PLOT DATE = \$DATE*	DATE - 12/2009	REVISED -



STATE OF ILLINOIS
DEPARTMENT OF TRANSPORTATION

SIGNING DETAILS

SCALE: N.T.S. SHEET NO. 8 OF 58 SHEETS STA. TO STA.

F.A.T. RTE.	SECTION	COUNTY	TOTAL SHEETS	SHEET NO.
290	2009-099BR	COOK/DUPAGE	394	336
FED. ROAD DIST. NO. ILLINOIS FED. AID PROJECT			CONTRACT NO. 60157	