


LEGEND	
	EXISTING COM ED POWER POLE
	SERVICE PEDESTAL
	PROPOSED LIGHTING CONTROLLER
	PROPOSED STREET LIGHT, 50W MH, DUAL DECORATIVE FIXTURE
	PROPOSED STREET LIGHT, 150W PMH, COBRAHEAD
	EXISTING STREET LIGHT
	1" UNIT DUCT 3*6 & 1*8 GROUND
	2" CONDUIT, PUSHED LENGTH AS SHOWN WITH 1" UNIT DUCT OR AS NOTED
	2" CONDUIT, TRENCHED LENGTH AS SHOWN WITH 3*2
	SB SETBACK FROM BACK OF CURB

ILLINOIS ROUTE 137 (SHERIDAN ROAD)

OSKAR K. AGUSTINSON
 62-059408
 REGISTERED
 PROFESSIONAL
 ENGINEER
 OF
 STATE OF ILLINOIS
Oskar K. Agustinson 10/19/09
 LICENSE EXPIRES 11/30/11

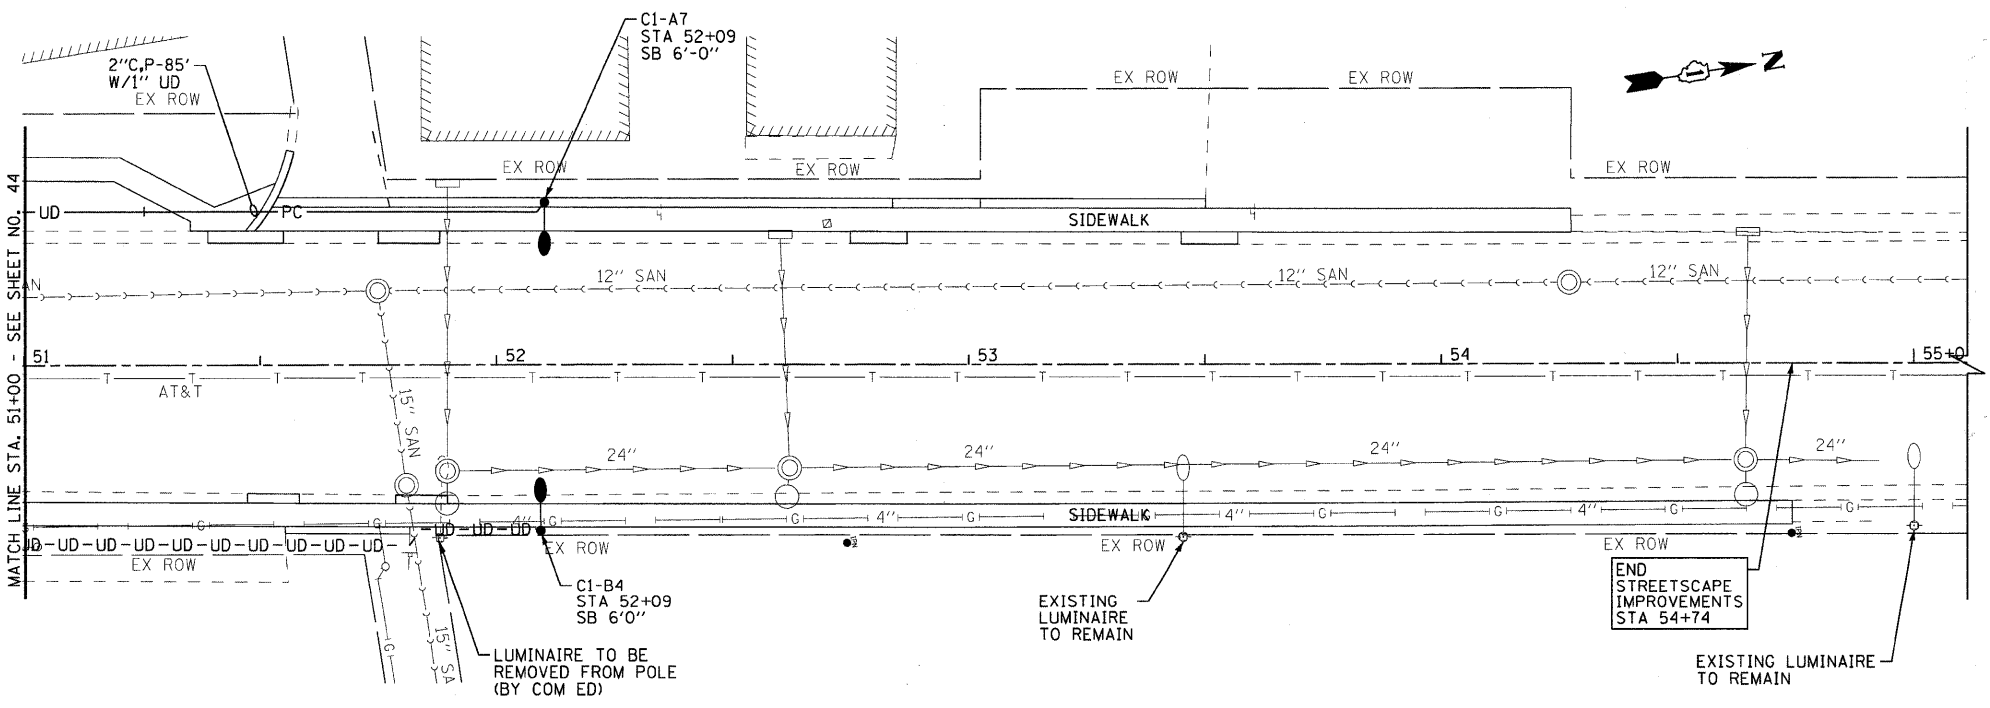

ILLINOIS ROUTE 137 (SHERIDAN ROAD)

COPYRIGHT © 2009 BY BAXTER & WOODMAN, INC.
 STATE OF ILLINOIS PROFESSIONAL DESIGN FIRM
 No. 06-00036-00-LS
 DATE: 10/19/2009
 FILE: 060807-lighting-3.sht



DESIGNED - OKA	REVISED - IDOT REVIEW 2/19/09
DRAWN - CJC	REVISED - IDOT REVIEW 4/22/09
CHECKED - JTB	REVISED - IDOT REVIEW 6/3/09
DATE - 8-1-08	FILE - 060807-lighting-3.sht

VILLAGE OF WINTHROP HARBOR, ILLINOIS
ILLINOIS ROUTE 137 (SHERIDAN ROAD) AND 7th STREET
STREETScape IMPROVEMENTS

STREET LIGHTING PLAN
ILLINOIS ROUTE 137 (SHERIDAN ROAD)

SCALE: 1" = 20'
 STA. 45+00 TO STA. 55+00

F.A.P. RTE.	SECTION	COUNTY	TOTAL SHEETS	SHEET NO.
	06-00036-00-LS	LAKE	70	43
FED. ROAD DIST. NO. 1		CONTRACT NO. 63167		
JOB NO. C-91-197-10		ILLINOIS FED. AID PROJECT ARA-0001810		