


**WHITNEY AVENUE**

BEGIN STREETScape IMPROVEMENTS STA 6+44

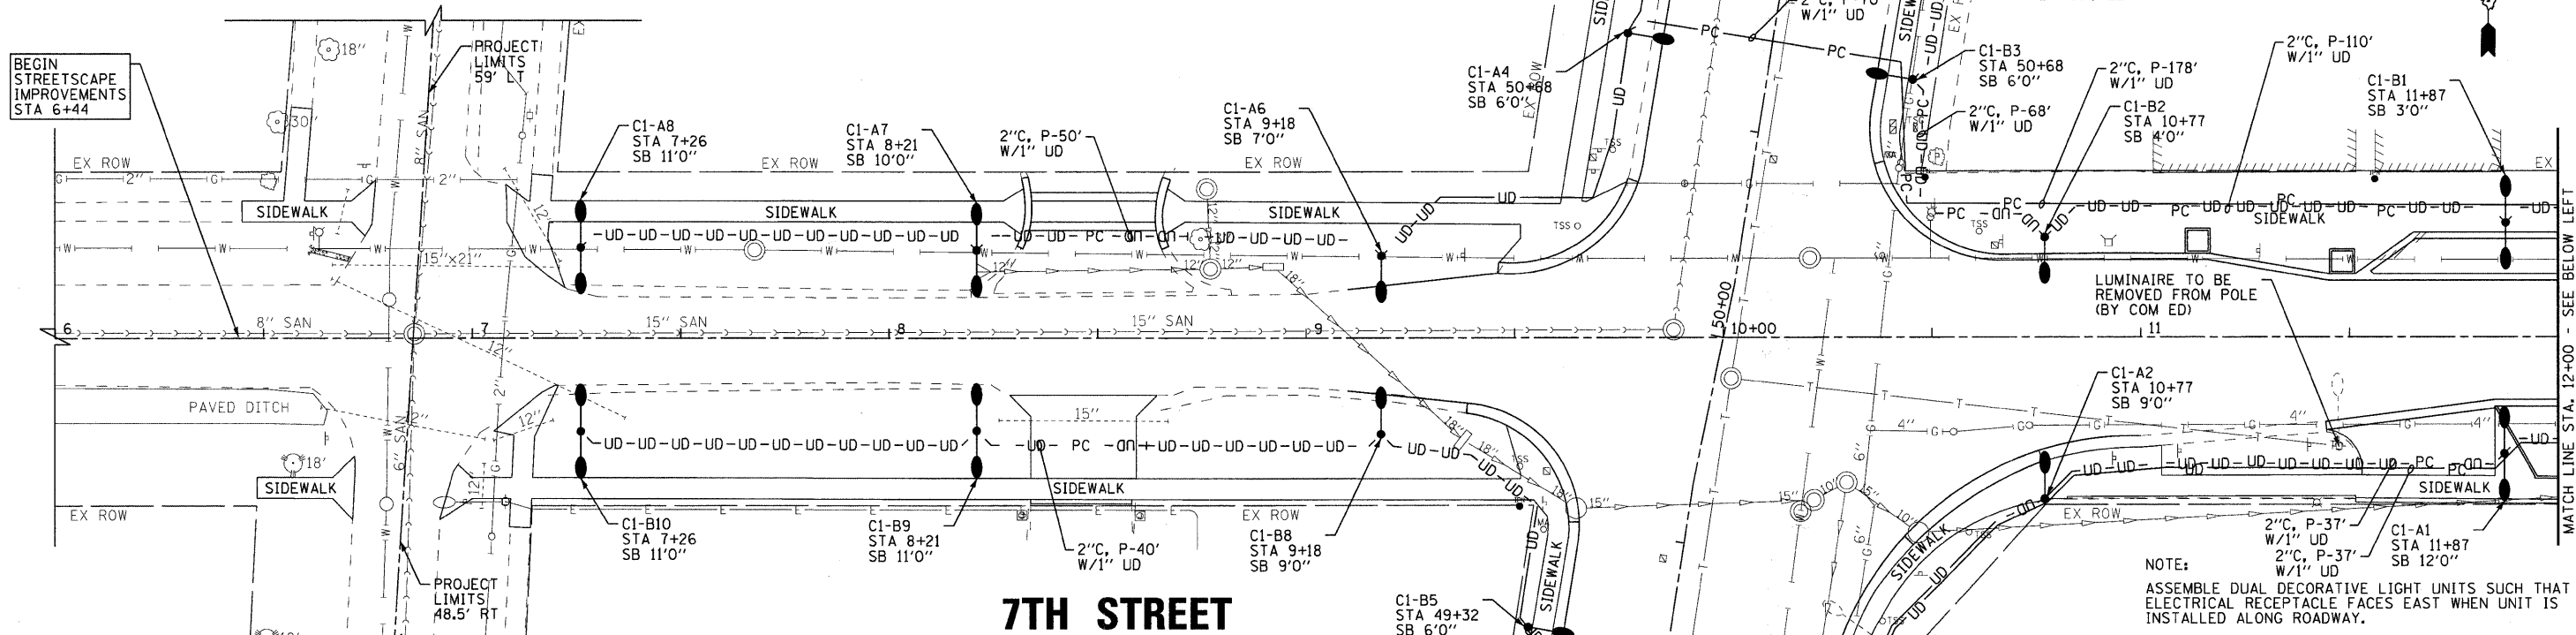



**7TH STREET**

**WHITNEY AVENUE**

**LEGEND**

- ⊕ EXISTING COM ED POWER POLE
- SERVICE PEDESTAL
- UD— 1" UNIT DUCT 3\*6 & 1\*8 GROUND
- PC— 2" CONDUIT, PUSHED LENGTH AS SHOWN WITH 1" UNIT DUCT OR AS NOTED
- U— 2" CONDUIT, TRENCHED LENGTH AS SHOWN WITH 3\*2
- PROPOSED STREET LIGHT, 150W PMH, COBRAHEAD
- EXISTING STREET LIGHT
- ⊠ PROPOSED LIGHTING CONTROLLER
- PROPOSED STREET LIGHT, 50W MH, DUAL DECORATIVE FIXTURE
- SB SETBACK FROM BACK OF CURB

NOTE:  
ASSEMBLE DUAL DECORATIVE LIGHT UNITS SUCH THAT ELECTRICAL RECEPTACLE FACES EAST WHEN UNIT IS INSTALLED ALONG ROADWAY.

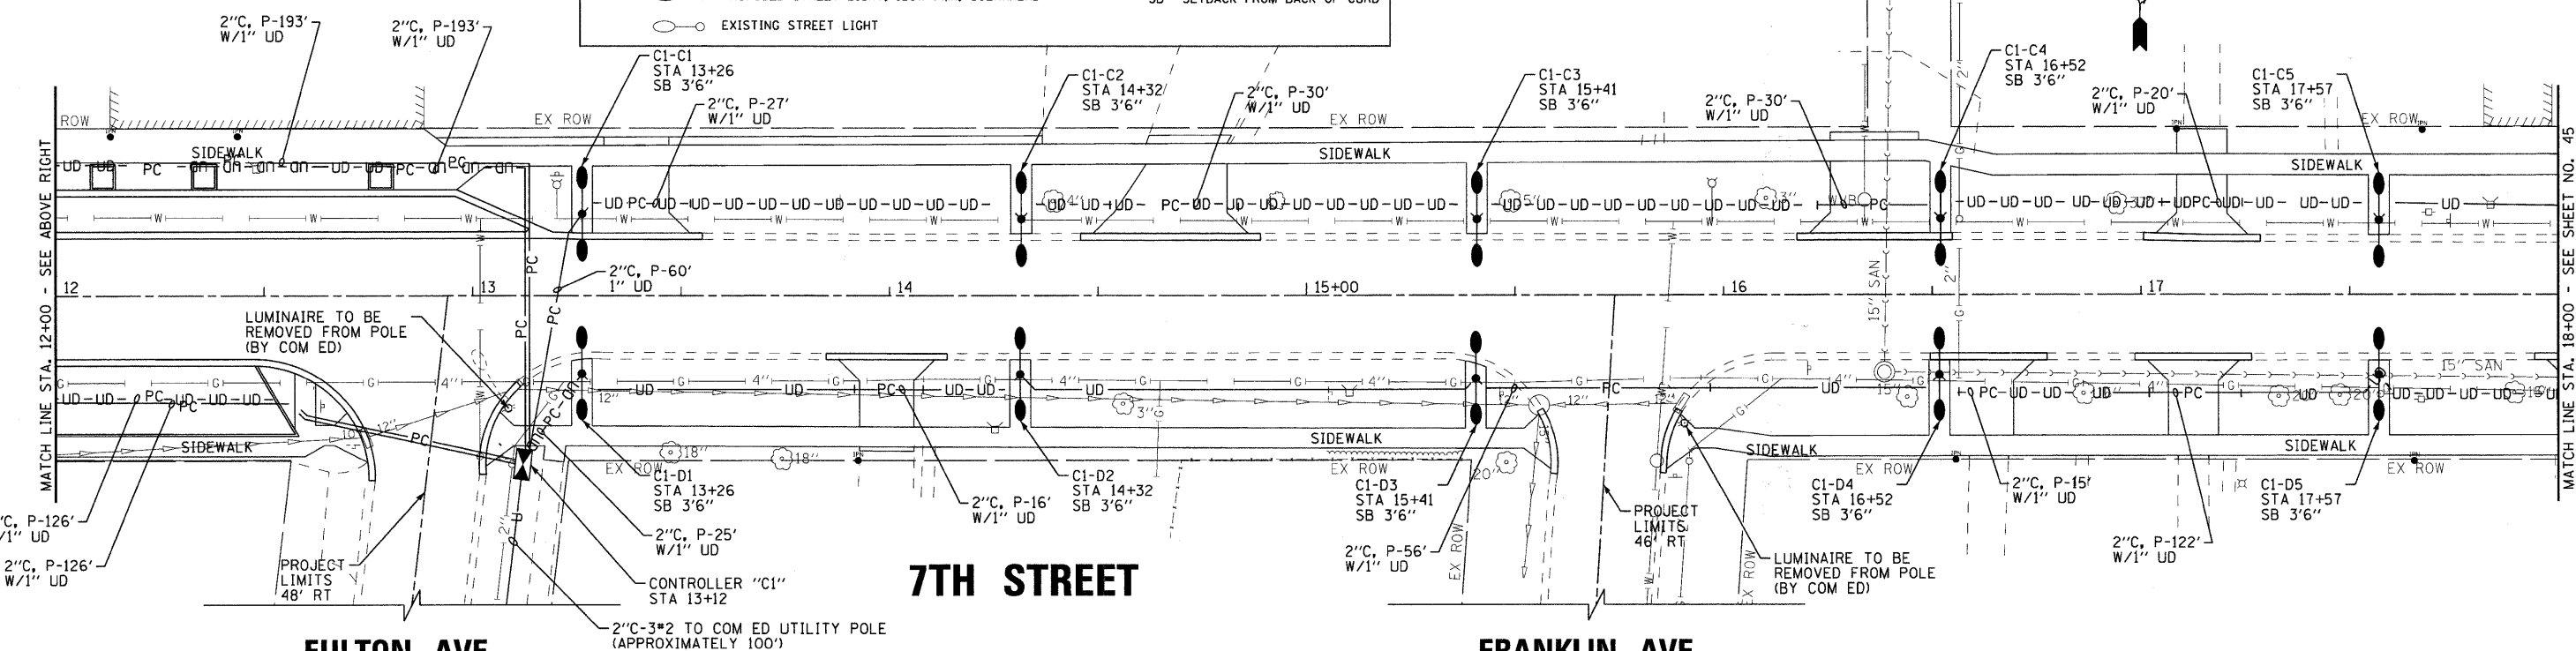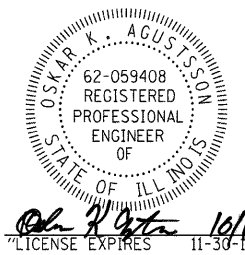

**7TH STREET**

**FULTON AVE**

**FRANKLIN AVE**

**VILLAGE OF WINTHROP HARBOR, ILLINOIS  
ILLINOIS ROUTE 137 (SHERIDAN ROAD) AND 7th STREET  
STREETScape IMPROVEMENTS**

**STREET LIGHTING PLAN  
7TH STREET**

F.A.P. 352 ILLINOIS ROUTE 137 (SHERIDAN ROAD)

DESIGNED - MWH	REVISED - IDOT REVIEW 2/19/09
DRAWN - CJC	REVISED - IDOT REVIEW 4/22/09
CHECKED - JTB	REVISED - IDOT REVIEW 6/3/09
DATE - 8-1-08	FILE - 060807-lighting-1.sht

SCALE: 1" = 20'  
STA. 6+00 TO STA. 18+00

F.A.P. RTE.	SECTION	COUNTY	TOTAL SHEETS	SHEET NO.
•	06-00036-00-LS	LAKE	70	44
FED. ROAD DIST. NO. 1		CONTRACT NO. 63167		
JOB NO. C-91-197-10		ILLINOIS FED. AID PROJECT ARA-00D18101		

COPYRIGHT © 2009 BY BAXTER & WOODMAN, INC.  
 STATE OF ILLINOIS - PROFESSIONAL DESIGN FIRM  
 111 W. Wacker Drive, Suite 2000, Chicago, IL 60601-4141  
 H. Whitney, 060807-lighting-1.sht, 8/1/08, 10/19/09

