

STATE OF ILLINOIS
DEPARTMENT OF TRANSPORTATION
DIVISION OF HIGHWAYS

PLANS FOR PROPOSED FEDERAL AID HIGHWAY

F. A. U. NO.	SECTION	COUNTY	TOTAL SHEETS	SHEET NO.
1597	09-00119-00-LT	COOK	12	1
STA. 11+00		TO STA. 81+00		
FED. ROAD DIST. NO. 1	ILLINOIS	FED. AID PROJECT AREA - 9003 (334)		



CONTRACT #63287

- INDEX OF SHEETS
1. COVER SHEET
 2. SUMMARY OF QUANTITIES
 - 3.-6. STREET LIGHTING PLANS
 7. SINGLE LINE DIAGRAM
 - 8.-12. DETAIL DRAWINGS

STATE STANDARDS

- 000001-05 STANDARD SYMBOLS, ABBREVIATIONS AND PATTERNS
- 701501-05 URBAN LANE CLOSURE, 2L, 2W, UNDIVIDED
- 701606-06 URBAN LANE CLOSURE, MULTILANE, 2W, WITH MOUNTABLE MEDIAN
- 701701-06 URBAN LANE CLOSURE, MULTILANE INTERSECTION
- 701801-04 LANE CLOSURE, MULTILANE 1W OR 2W CROSSWALK OR SIDEWALK CLOSURE
- 701901-01 TRAFFIC CONTROL DEVICES


FAU 1597 (138TH STREET)
STREET LIGHTING
HALSTED STREET (FAU 3730) TO INDIANA AVENUE (FAU 2906)
SECTION NO.: 09-00119-00-LT
C-91-651-09
VILLAGE of RIVERDALE
COOK COUNTY
ARA-9003 (334)

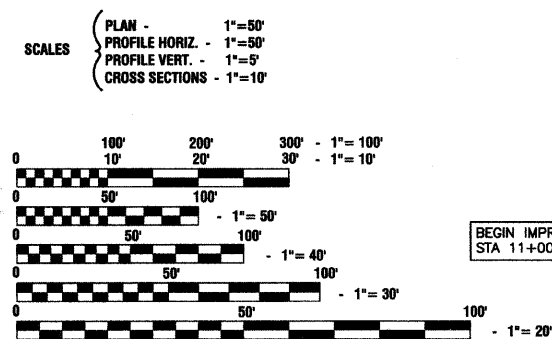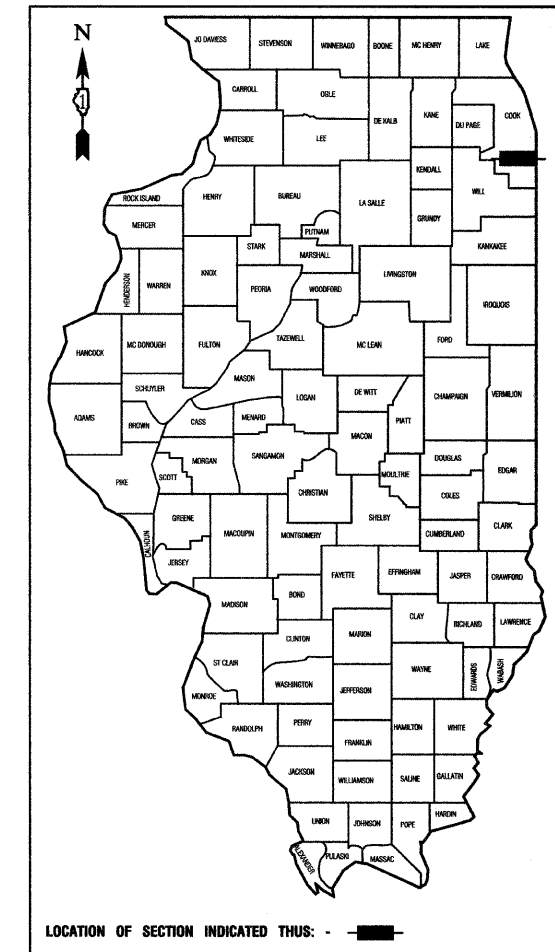

FULL SIZE PLANS HAVE BEEN PREPARED USING STANDARD ENGINEERING SCALES, REDUCED SIZED PLANS WILL NOT CONFORM TO STANDARD SCALES, IN MAKING MEASUREMENTS ON REDUCED PLANS, THE ABOVE SCALES MAY BE USED.

J. U. L. I. E.
JOINT UTILITY LOCATION INFORMATION FOR EXCAVATION
1-800-892-0123 or 811

CONTRACT NO. 63287

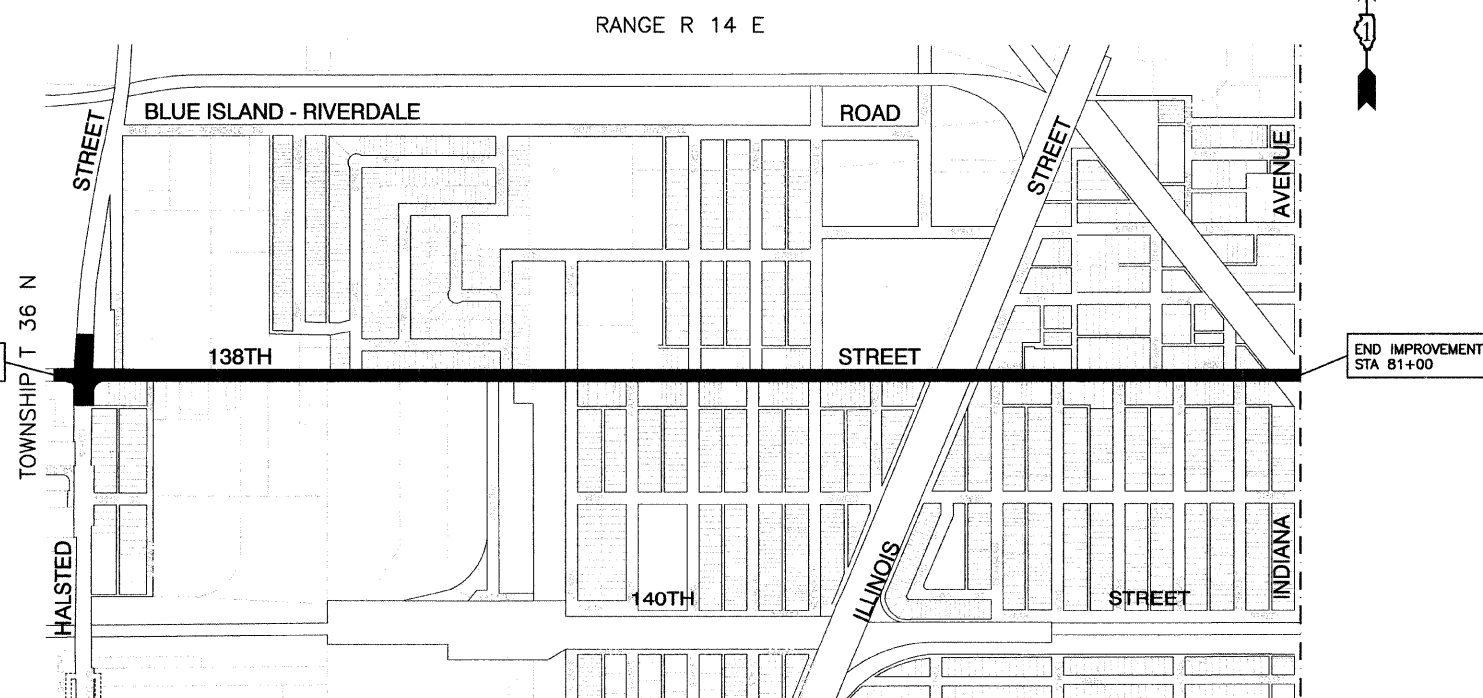

LOCATION MAP

GROSS LENGTH=7,000 FEET=1.33 MILES
NET LENGTH=7,000 FEET=1.33 MILES



STATE OF ILLINOIS DEPARTMENT OF TRANSPORTATION
DIVISION OF HIGHWAYS


Approved: 10/15/2009
[Signature]
President, Village of Riverdale

Passed: OCTOBER 27, 2009
[Signature]
District 1 Engineer of Local Roads & Streets

Released for Bid Based on Limited Review: OCTOBER 24, 2009
[Signature]
Deputy Director of Highways, Region 1 Engineer

PRINTED BY THE AUTHORITY OF
THE STATE OF ILLINOIS

PREPARED BY OR UNDER THE DIRECT SUPERVISION OF:
[Signature]
10/16/09

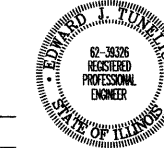

LICENSE EXPIRES: 11/30/11

FIELD ENGINEER: MELCHOR MANGOBA 847-705-4408
CONSULTANTS: ROBINSON ENGINEERING, LTD. 708-331-6700