


PLAN	REVISIONS	DATE
	PLOTTED	BY
NOTE BOOK NO.	ALIGNMENT CHECKED	
	CAUD FILE NAME	


PROFILE	REVISIONS	DATE
	PLOTTED	BY
NOTE BOOK NO.	GRADES CHECKED	
	IS.M. NOTED	

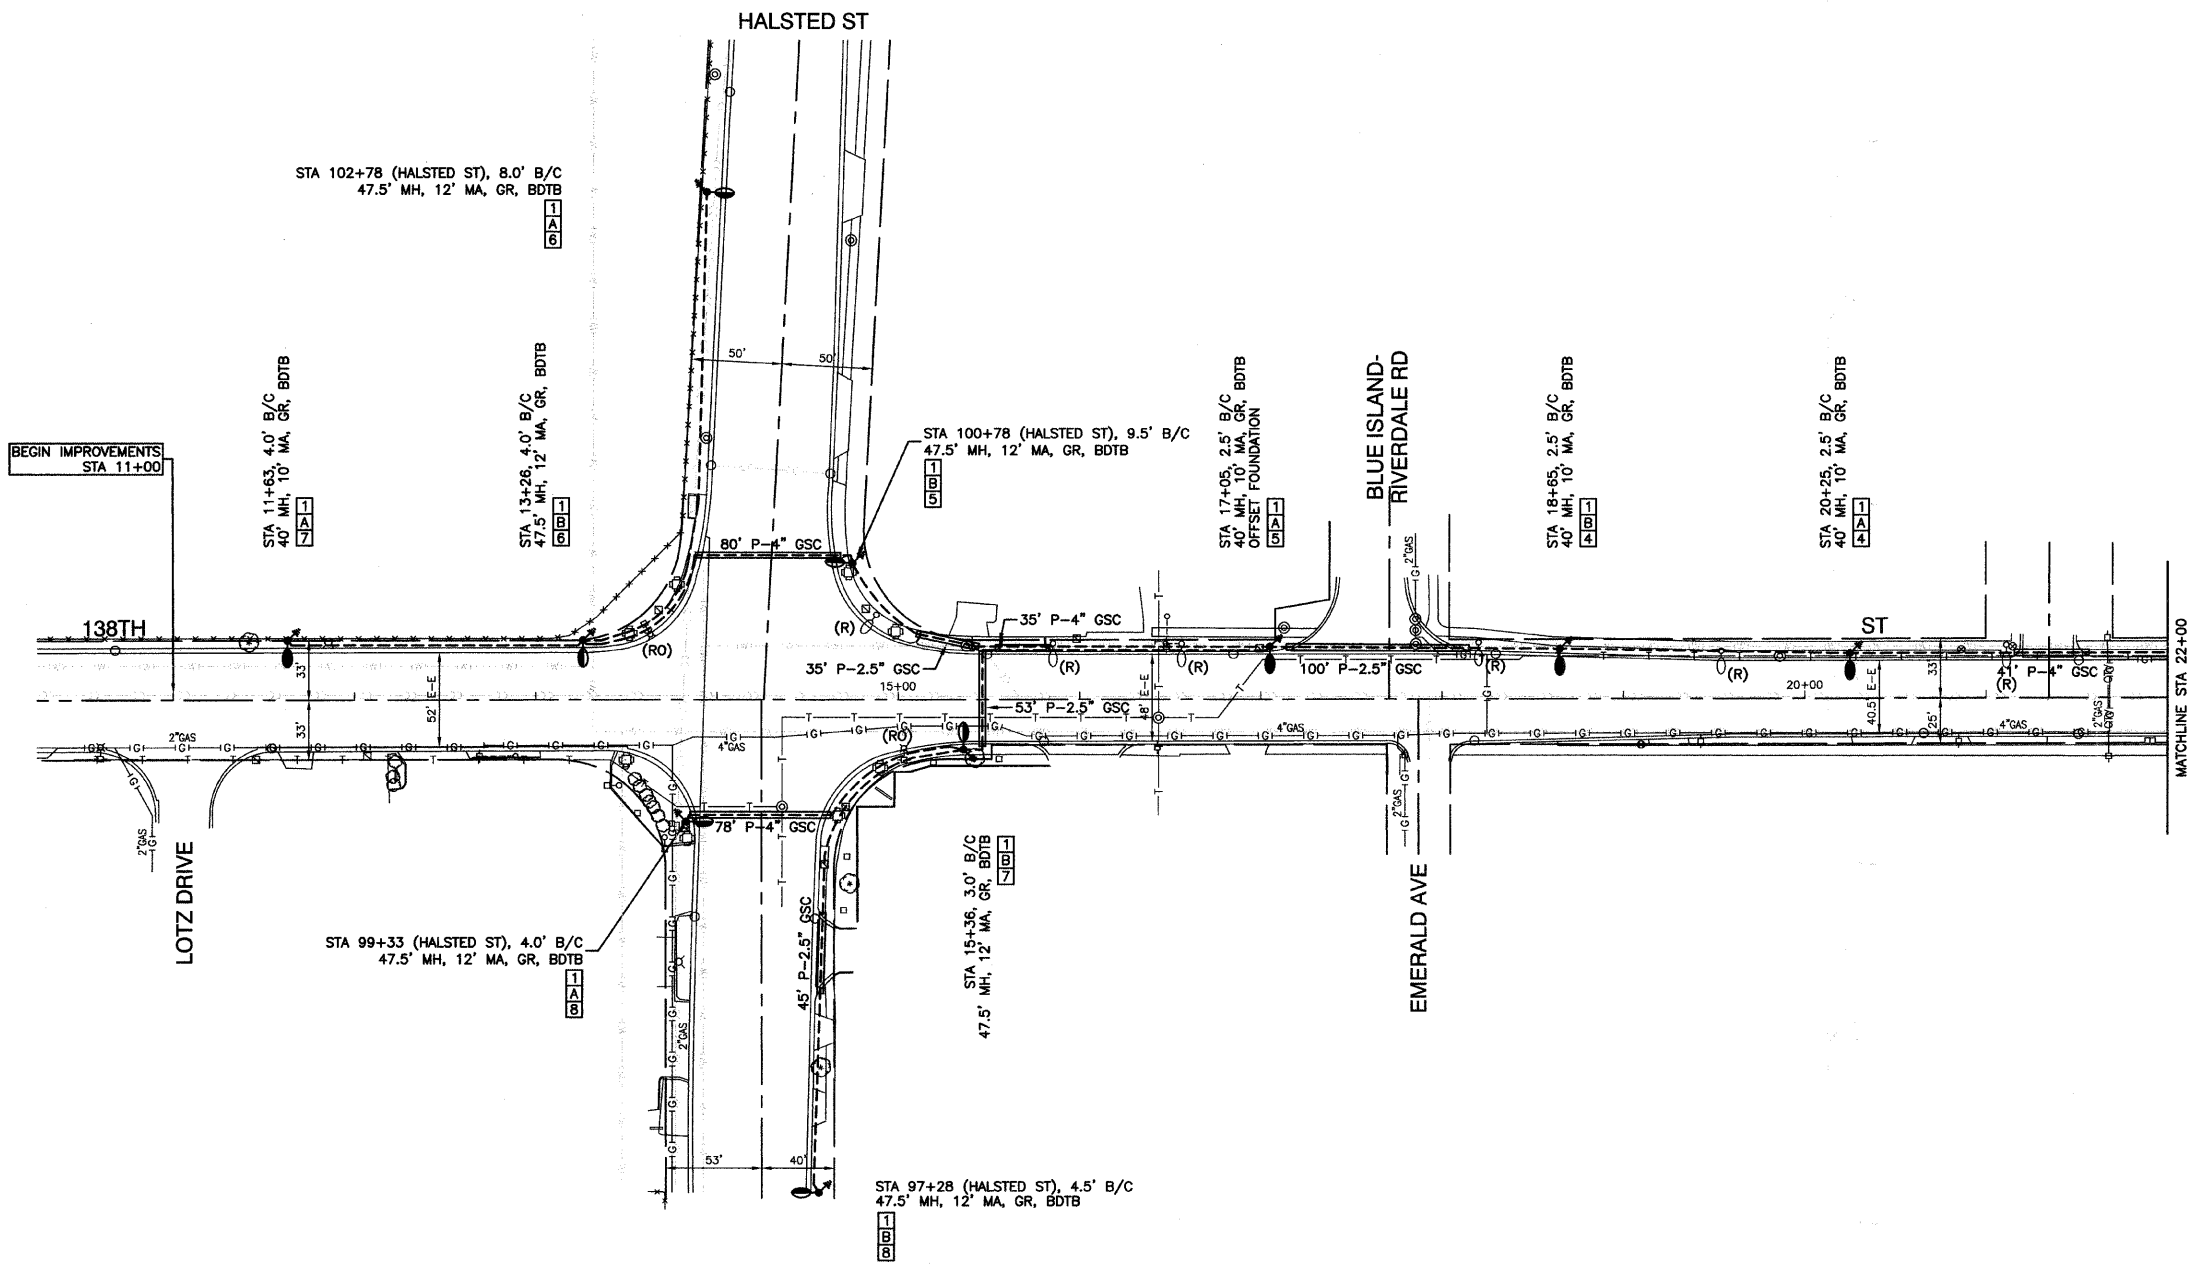

LEGEND:

- EXISTING STREET LIGHT-250W HPS
- PROPOSED STREET LIGHT-400W HPS
- PROPOSED STREET LIGHT-250W HPS
- EXISTING CONTROLLER
- PROPOSED CONTROLLER, CONSOLE TYPE
- COMED POWER POLE FOR SERVICE CONNECTION
- CONDUIT, PUSHED, GALVANIZED STEEL
- CONDUIT, TRENCHED, GALVANIZED STEEL
- UNIT DUCT, 600V, 3-1C NO.4, 1/C NO.6 GROUND, (XLP-TYPE USE), 1-1/4" DIA., POLYETHYLENE
- ELECTRIC CABLE IN CONDUIT, 600V (XLP-TYPE USE) 3-1/C NO. 1/0
- ⊗ GR GROUND ROD, 5/8" DIA. x 10'
- (R) REMOVAL OF EXISTING STREET LIGHT (NO SALVAGE)
- (RO) REMOVAL OF EXISTING STREET LIGHT (BY OTHERS)
- LT LEFT
- RT RIGHT
- MH MOUNTING HEIGHT
- MA MAST ARM
- B/C BACK OF CURB
- B/EP BEHIND EDGE OF PAVEMENT
- BDTB BREAKAWAY DEVICE, TRANSFORMER BASE, 15" BOLT CIRCLE

 POLE IDENTIFICATION



FILE NAME = 06306-PLAN-01 - IDOT P01	USER NAME =	DESIGNED -- DWS	REVISED --	STATE OF ILLINOIS DEPARTMENT OF TRANSPORTATION	138TH STREET STREET LIGHTING PLAN SHEET		F.A.U. RTE. 1597	SECTION 09-00119-00-LT	COUNTY COOK	TOTAL SHEETS 12	SHEET NO. 3	
PLOT SCALE = 1"=50'	DRAWN -- MJD	CHECKED -- EJT	REVISED --		SCALE: 1"=50'	SHEET NO. 3 OF 12 SHEETS	STA. 11+00 TO STA. 22+00	CONTRACT NO. 63287				
PLOT DATE = 10-15-09	CHECKED -- PAP	DRAWN -- MJD	REVISED --		FED. ROAD DIST. NO. 1 ILLINOIS FED. AID PROJECT ARA - 9003 (334)							