

 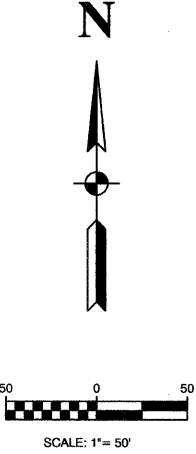


PLAN	REVISIONS	DATE
NO.	PLOTTED	
	ALIGNMENT CHECKED	
	GRADES CHECKED	
	CAO FILE NAME	

PROFILE	REVISIONS	DATE
NO.	PLOTTED	
	GRADES CHECKED	
	S.M. NOTED	

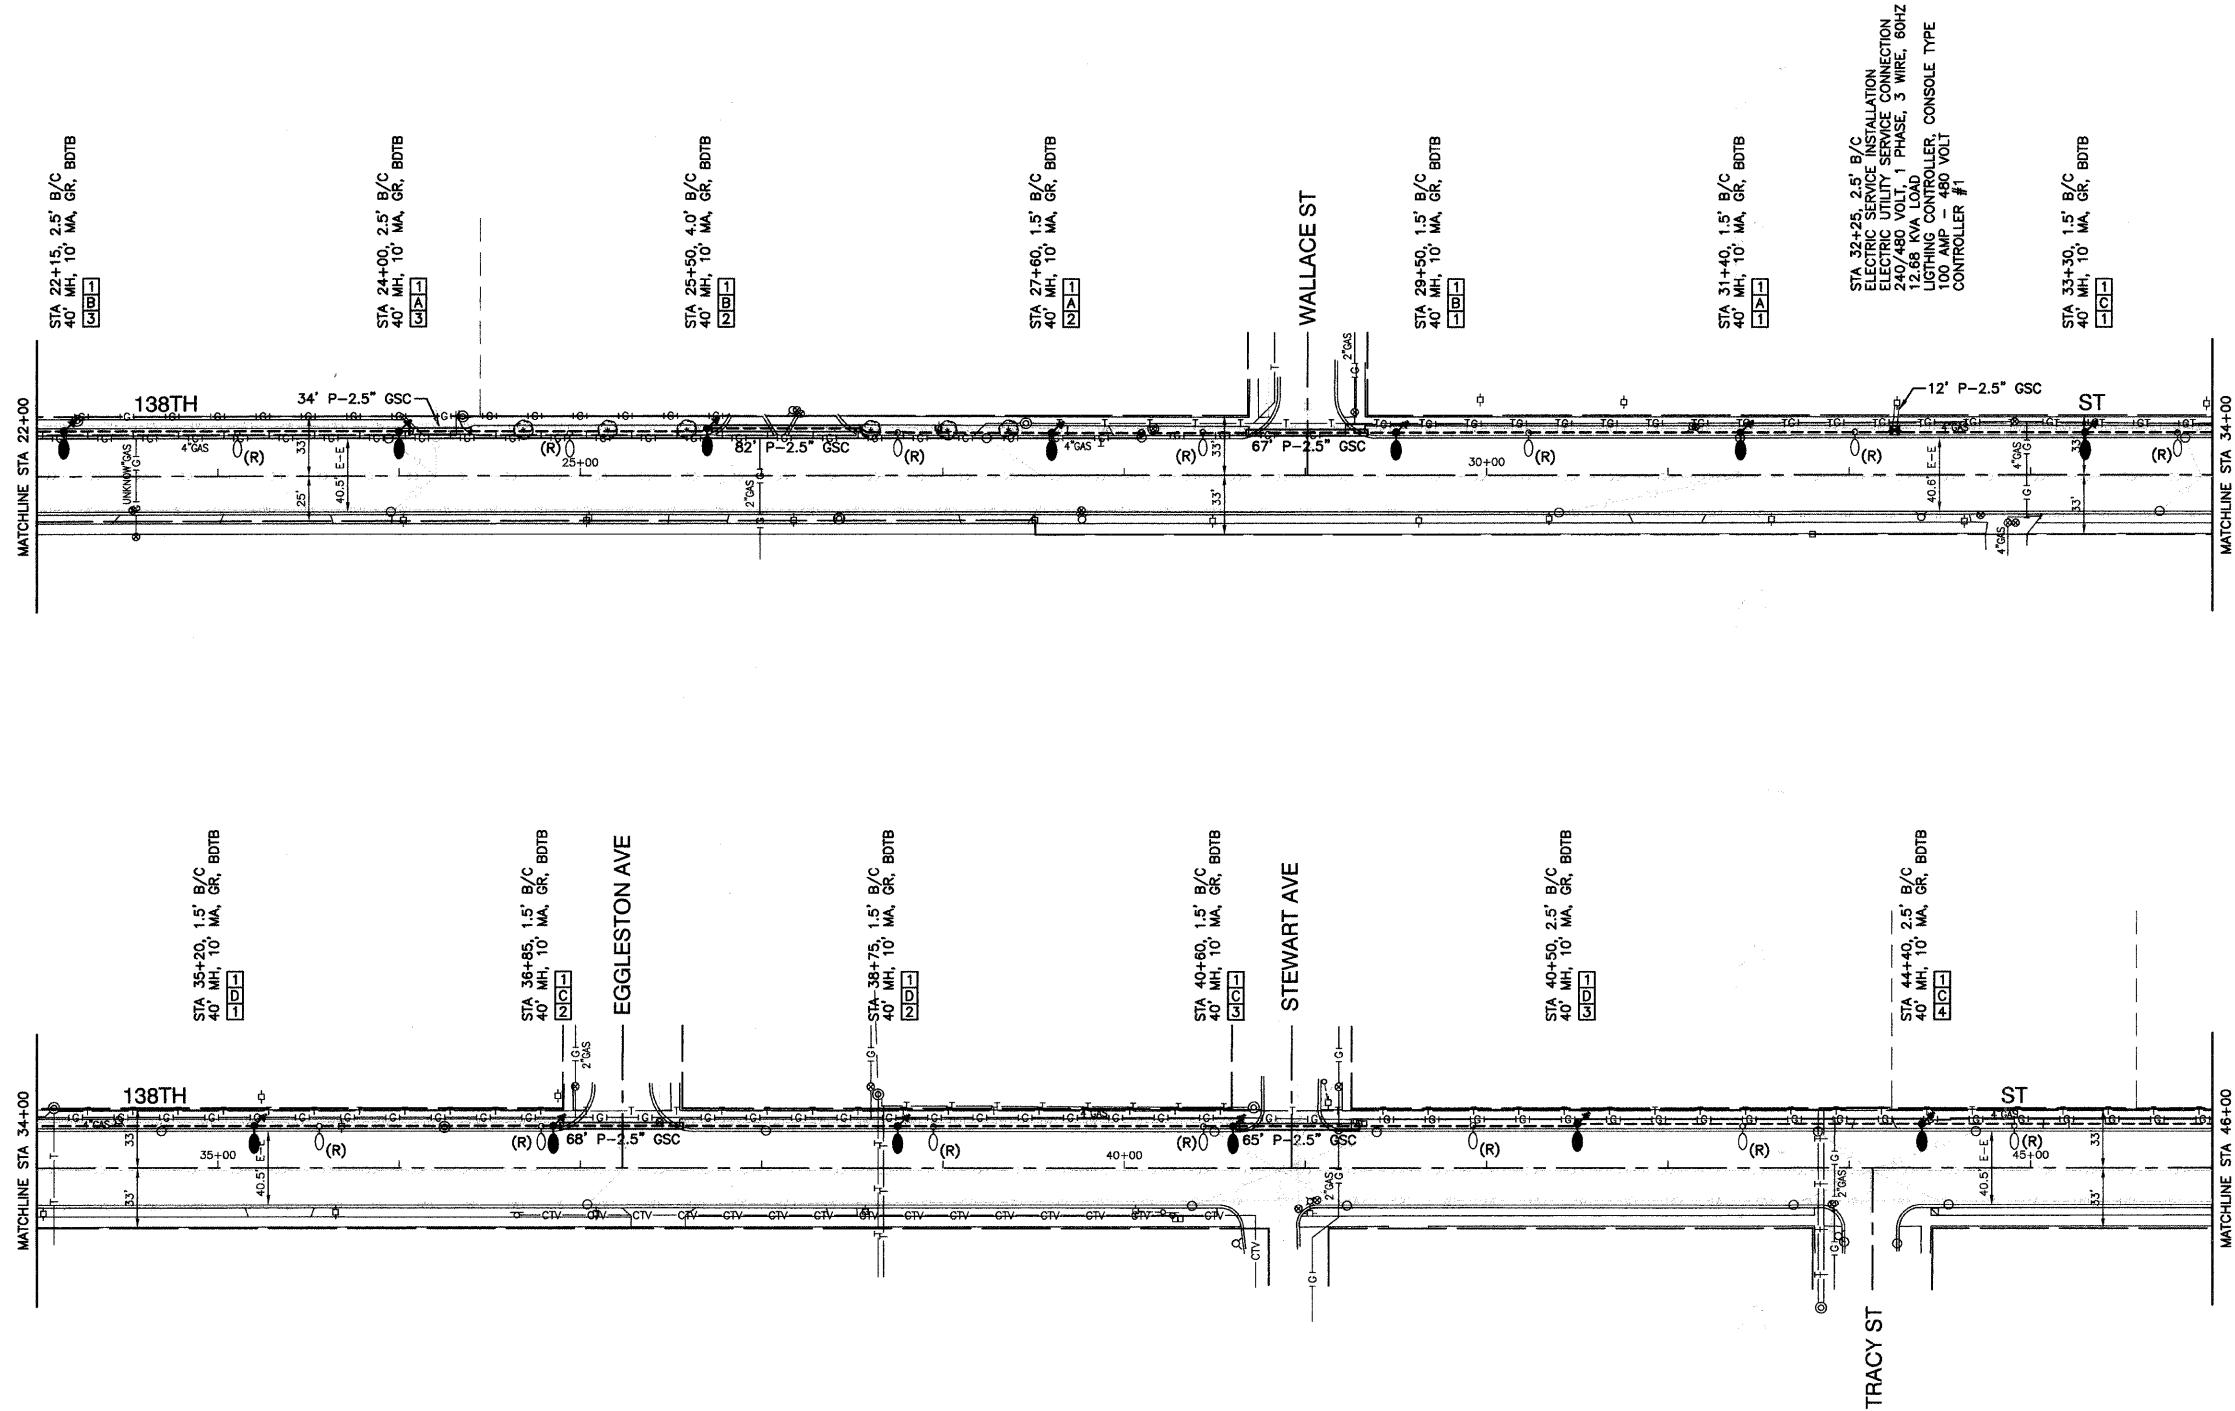

**POLE IDENTIFICATION**



- EXISTING STREET LIGHT-250W HPS
- PROPOSED STREET LIGHT-400W HPS
- PROPOSED STREET LIGHT-250W HPS
- EXISTING CONTROLLER
- PROPOSED CONTROLLER, CONSOLE TYPE
- COMED POWER POLE FOR SERVICE CONNECTION
- P — CONDUIT, PUSHED, GALVANIZED STEEL
- T — CONDUIT, TRENCHED, GALVANIZED STEEL
- U — UNIT DUCT, 600V, 3-1C NO.4, 1/C NO.6 GROUND, (XLP-TYPE USE), 1-1/4\"/>
- E — ELECTRIC CABLE IN CONDUIT, 600V (XLP-TYPE USE) 3-1/C NO. 1/0

**LEGEND:**

- GR GROUND ROD, 5/8\"/>
- (R) REMOVAL OF EXISTING STREET LIGHT (NO SALVAGE)
- (RO) REMOVAL OF EXISTING STREET LIGHT (BY OTHERS)
- LT LEFT
- RT RIGHT
- MH MOUNTING HEIGHT
- MA MAST ARM
- B/C BACK OF CURB
- B/EP BEHIND EDGE OF PAVEMENT
- BDTB BREAKAWAY DEVICE, TRANSFORMER BASE, 15\"/>

FILE NAME = 09309-PLAN-01 - IDOT P02

USER NAME =	DESIGNED — DWS	REVISED —
	CHECKED — EJT	REVISED —
PLOT SCALE = 1\"/>		
PLOT DATE = 10-15-09	CHECKED — PAP	REVISED —

STATE OF ILLINOIS  
DEPARTMENT OF TRANSPORTATION

138TH STREET STREET LIGHTING PLAN SHEET		F.A.U. RTE. 1597	SECTION 09-00119-00-LT	COUNTY COOK	TOTAL SHEETS 12	SHEET NO. 4
SCALE: 1\"/>						
SHEET NO. 4 OF 12 SHEETS		STA. 22+00	TO STA. 46+00			
FED. ROAD DIST. NO. 1		ILLINOIS		FED. AID PROJECT ARA - 9003 (334)		

