 

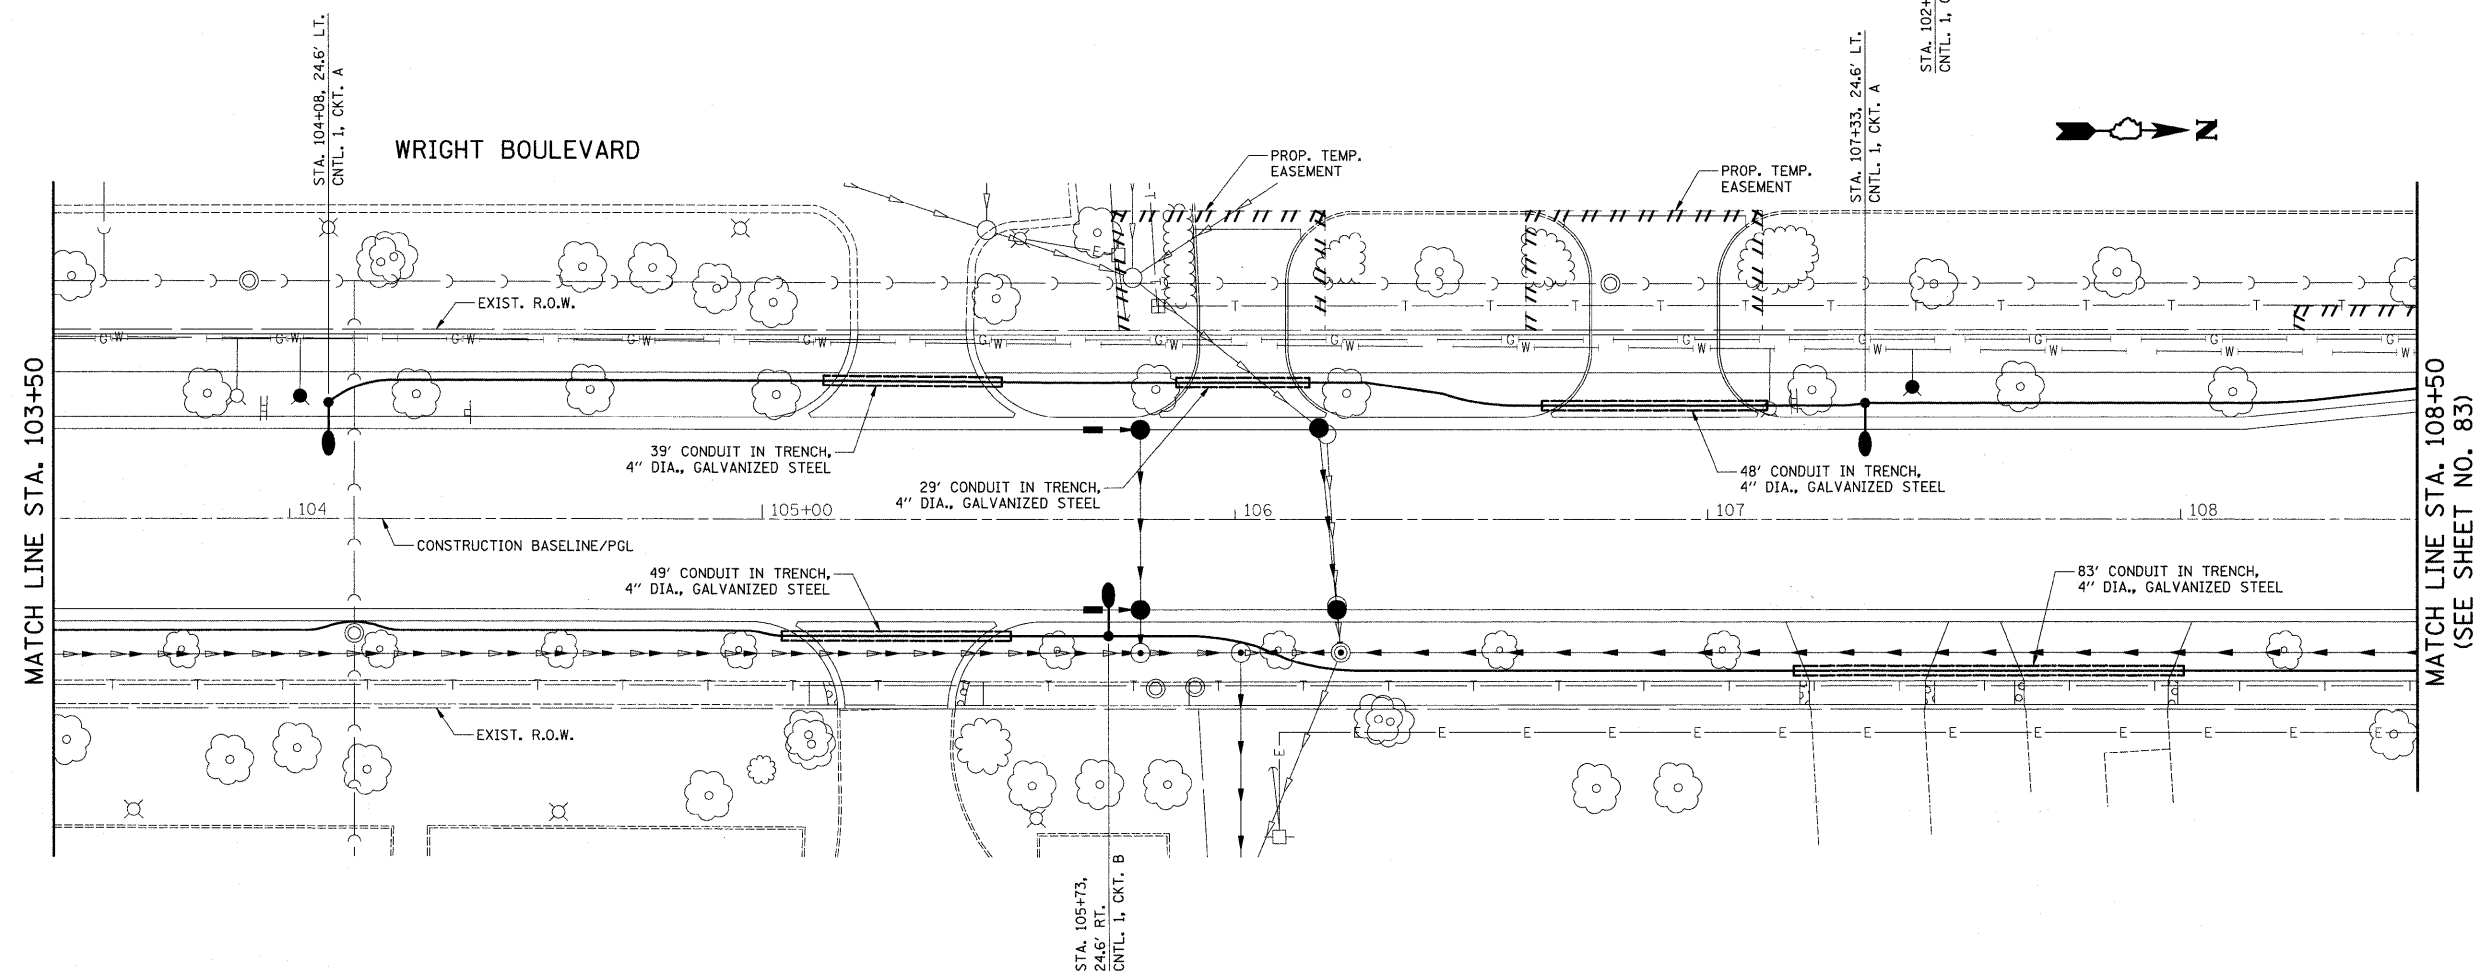


| | | |
|------|--------------------------|------|
| PLAN | SURVEYED | DATE |
| | PLOTTED | |
| | GRADES CHECKED | |
| | STRUCTURE NOTATIONS CHKD | |
| | NOTE BOOK NO. | |
| | BY | |
| | DATE | |

| | | |
|---------|--------------------------|------|
| PROFILE | SURVEYED | DATE |
| | PLOTTED | |
| | GRADES CHECKED | |
| | STRUCTURE NOTATIONS CHKD | |
| | NOTE BOOK NO. | |
| | BY | |
| | DATE | |

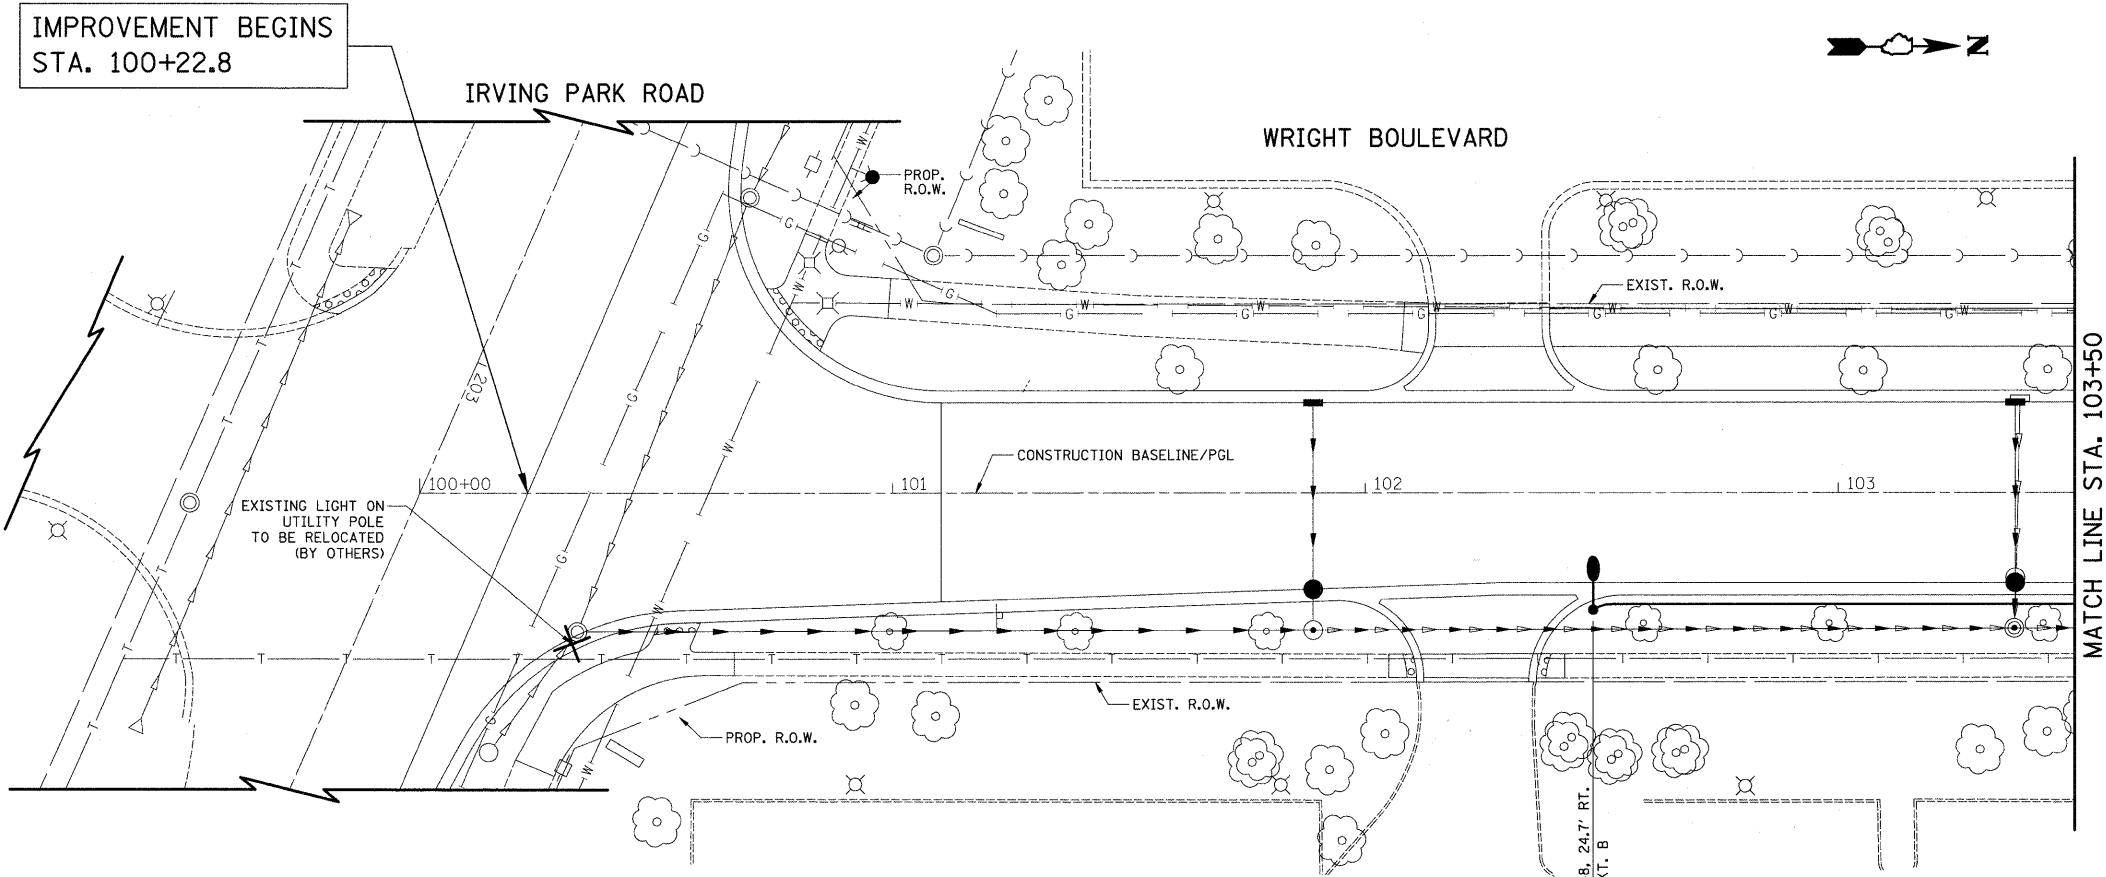

FILE NAME = J:\2215\oad\shets\2215_Light_01.dgn

USER NAME = jet
 PLOT SCALE = 28.0000' / IN.
 PLOT DATE = 10/15/2009

DESIGNED - SJC
 DRAWN - CDC
 CHECKED - DNM
 DATE - 10-16-09

REVISED -
 REVISED -
 REVISED -
 REVISED -

**STATE OF ILLINOIS
 DEPARTMENT OF TRANSPORTATION**

**WRIGHT BOULEVARD
 LIGHTING PLAN**

SHEET NO. 1 OF 5 SHEETS STA. 100+22.8 TO STA. 108+50

| | | | | |
|--|----------------|--------|--------------|-----------|
| F.A.U. RTE. | SECTION | COUNTY | TOTAL SHEETS | SHEET NO. |
| 1351 | 06-00090-00-PV | COOK | 137 | 95 |
| CONTRACT NO. 63378 | | | | |
| FED. ROAD DIST. NO. 1 ILLINOIS FED. AID PROJECT ARA-M-8003 (809) | | | | |