 

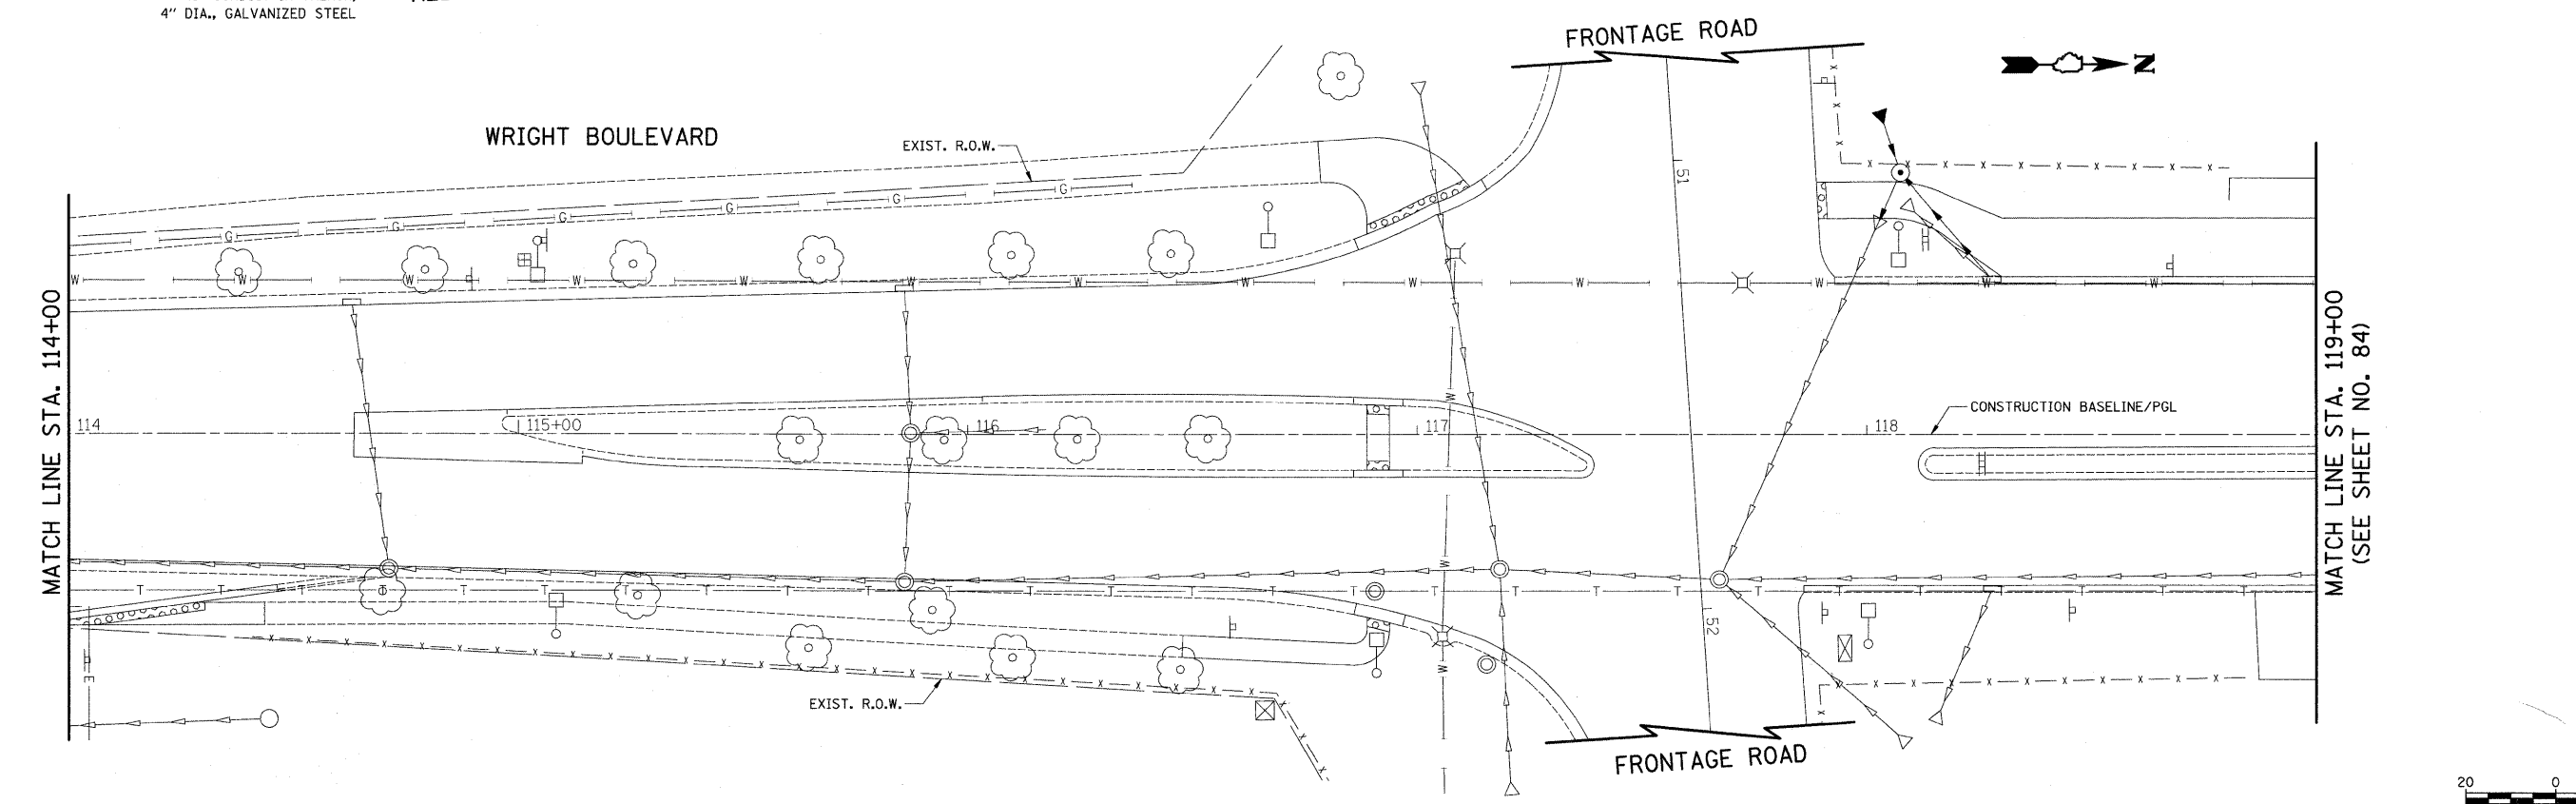


PLAN	DATE
BY	
REVISIONS	
NO.	
DATE	
BY	
REVISIONS	
NO.	
DATE	
BY	
REVISIONS	
NO.	
DATE	
BY	
REVISIONS	
NO.	
DATE	

PROFILE	DATE
BY	
REVISIONS	
NO.	
DATE	
BY	
REVISIONS	
NO.	
DATE	
BY	
REVISIONS	
NO.	
DATE	
BY	
REVISIONS	
NO.	
DATE	

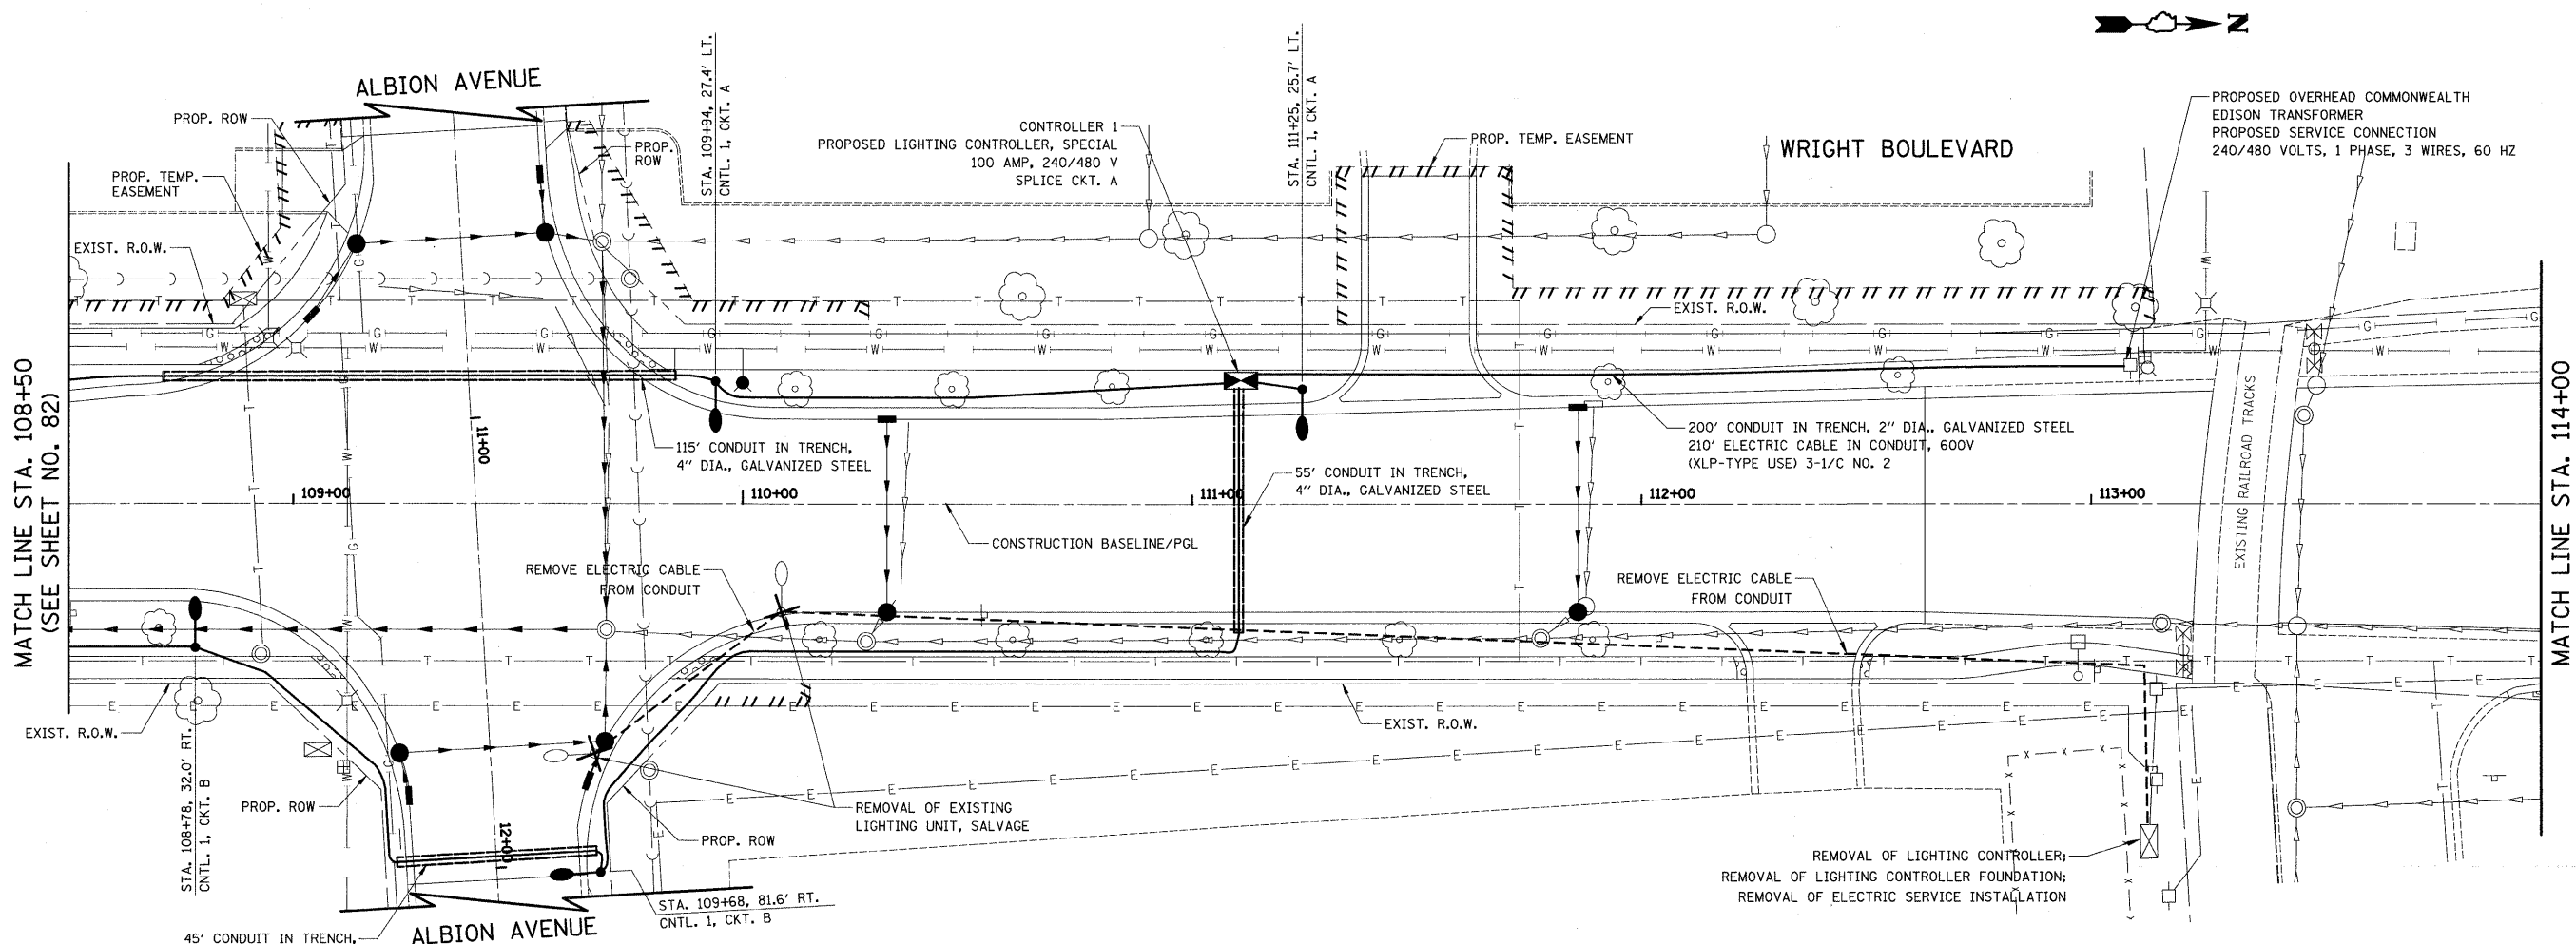

FILE NAME = J:\2215\oad\shets\2215_Light 02.dgn	USER NAME = jst	DESIGNED - SJC	REVISED -	<b>STATE OF ILLINOIS DEPARTMENT OF TRANSPORTATION</b>	<b>WRIGHT BOULEVARD LIGHTING PLAN</b>	F.A.U. RTE. 1351	SECTION 06-00090-00-PV	COUNTY COOK	TOTAL SHEETS 137	SHEET NO. 96		
PLOT SCALE = 20.0000' / IN.	CHECKED - DNM	REVISED -	SHEET NO. 2 OF 5 SHEETS			STA. 108+50 TO STA. 119+00	CONTRACT NO. 63378					
PLOT DATE = 10/15/2009	DATE - 10-16-09	REVISED -	FED. ROAD DIST. NO. 1 ILLINOIS FED. AID PROJECT ARA-M-8003 (809)									