


PLAN	SURVEYED	DATE
	PLOTTED	
	CHECKED	
	BY	
	NO. _____	
	NOTE BOOK	
	NO. _____	
	FILE NAME	
	CADD FILE NAME	


PROFILE	SURVEYED	DATE
	PLOTTED	
	CHECKED	
	BY	
	NO. _____	
	NOTE BOOK	
	NO. _____	
	FILE NAME	
	CADD FILE NAME	

MATCH LINE STA. 119+00  
(SEE SHEET NO. 83)

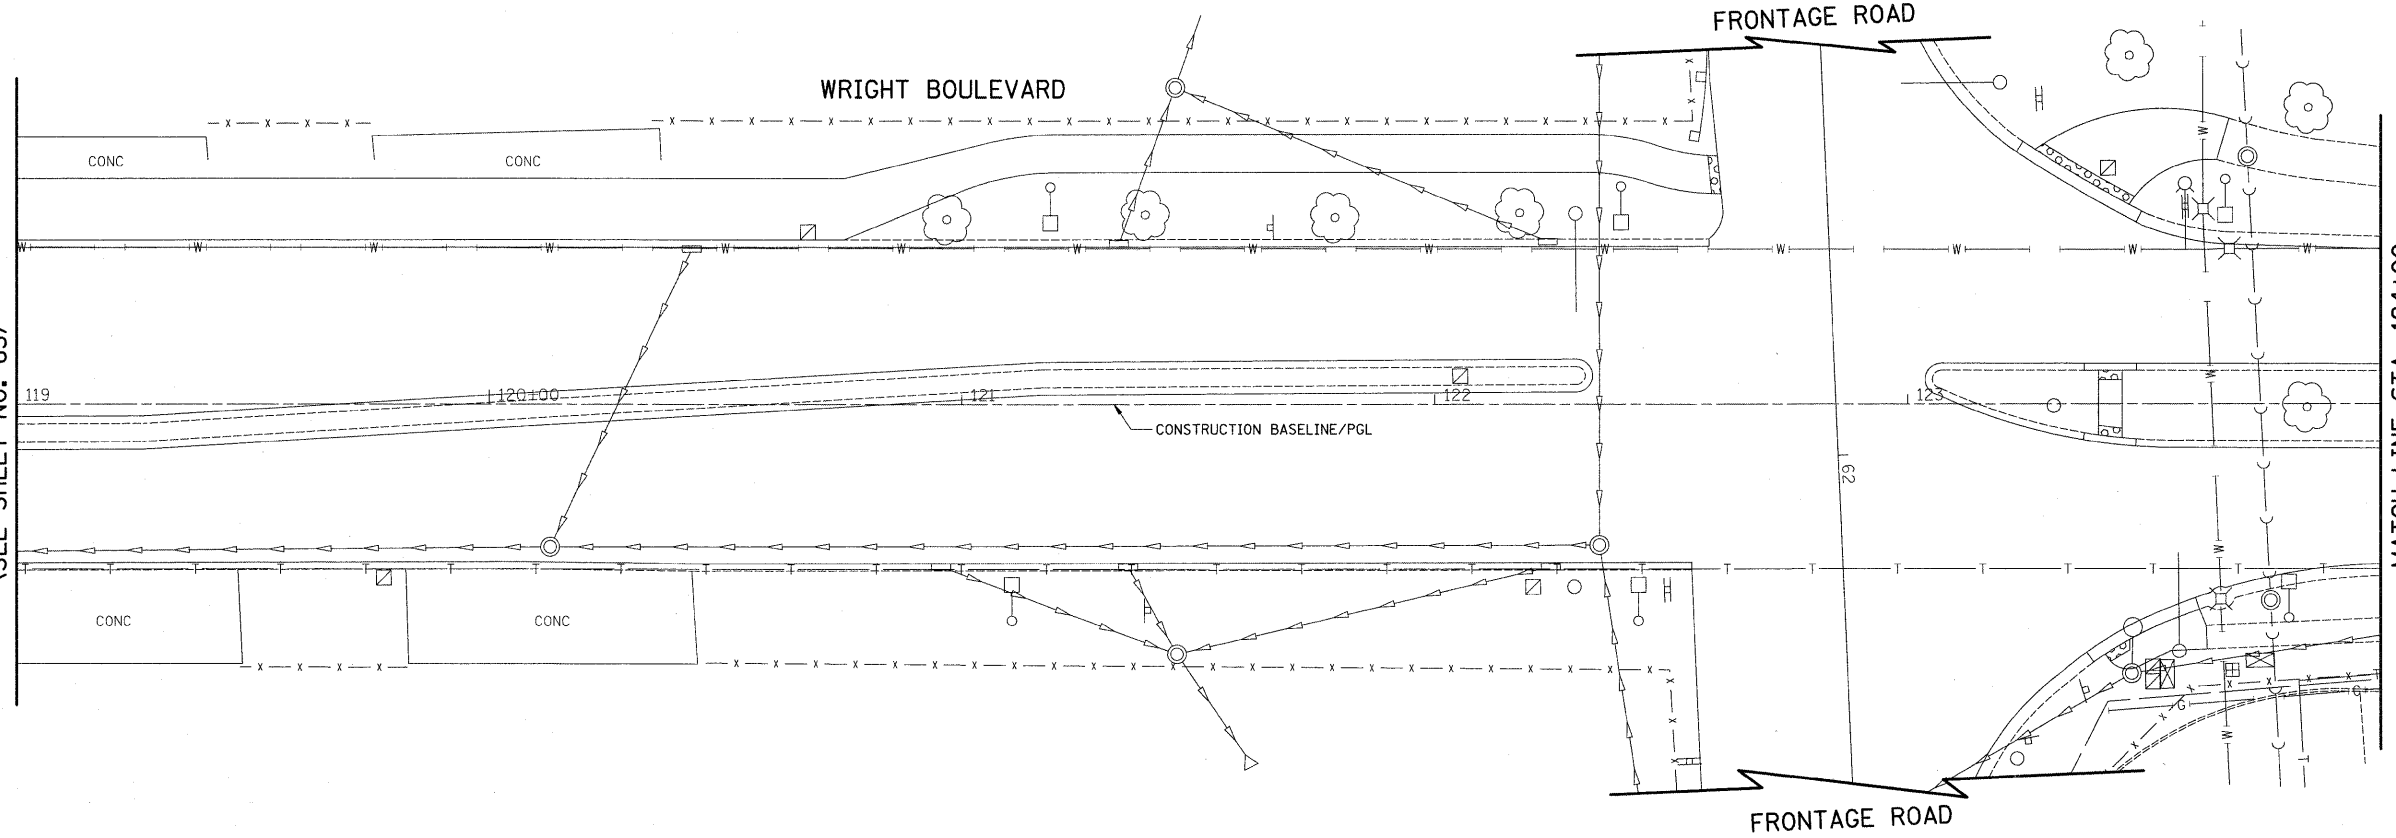


MATCH LINE STA. 124+00

MATCH LINE STA. 124+00

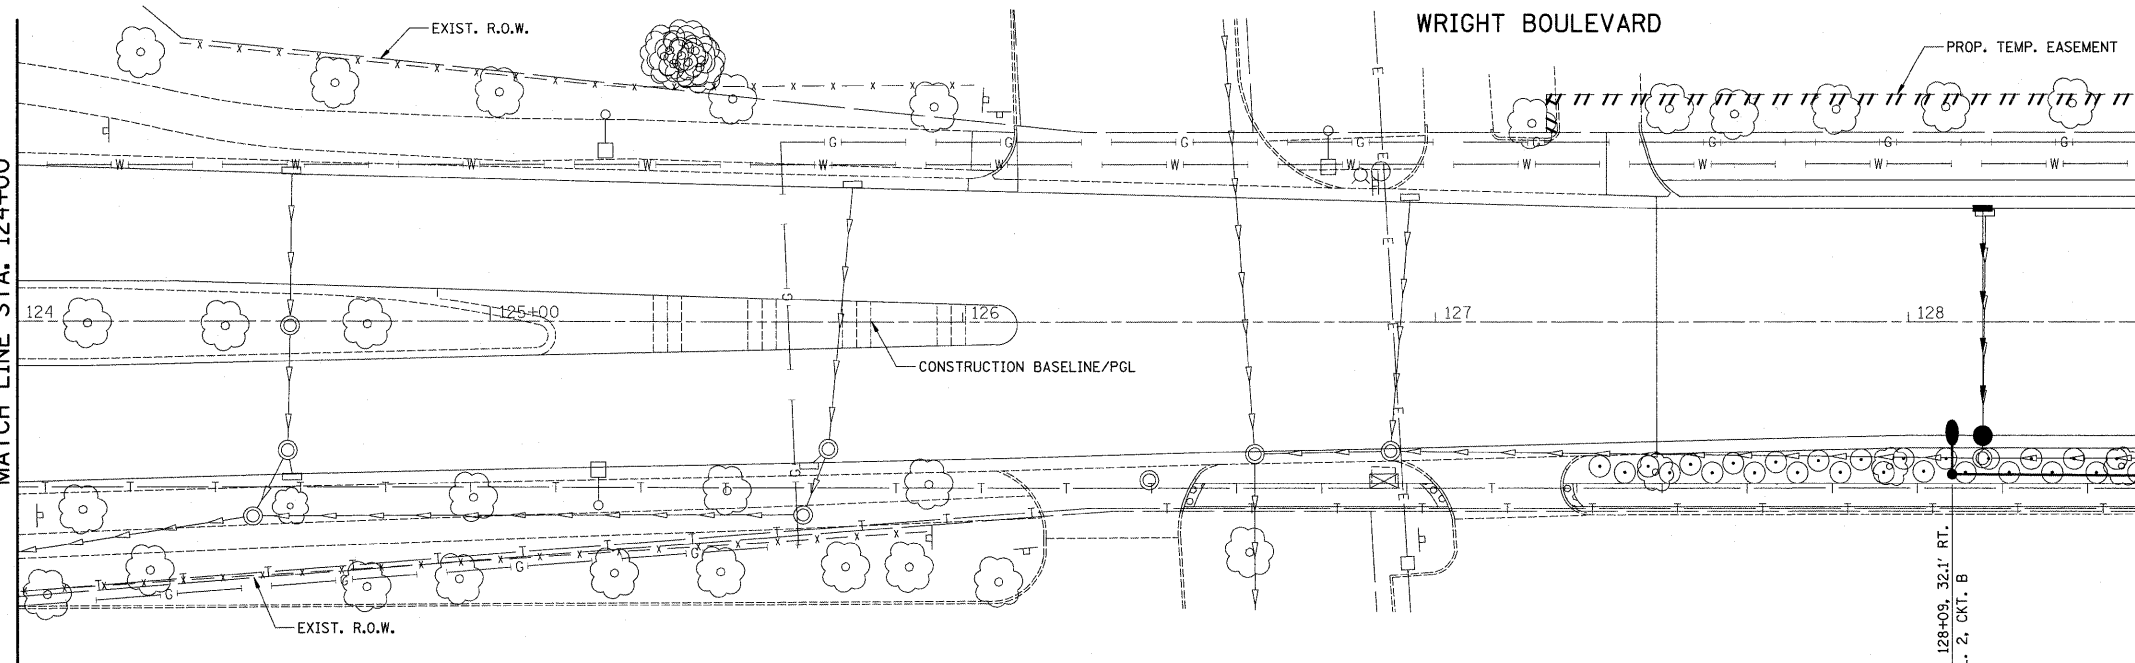

 MATCH LINE STA. 128+50  
(SEE SHEET NO. 85)



FILE NAME = J:\2215\cad\shets\2215\_Light 03.dgn

USER NAME = jat

DESIGNED - SJC  
DRAWN - CDC

REVISED -  
REVISED -

PLOT SCALE = 20.0000' / IN.  
PLOT DATE = 10/15/2009

CHECKED - DNM  
DATE - 10-16-09

REVISED -  
REVISED -

**STATE OF ILLINOIS  
DEPARTMENT OF TRANSPORTATION**

**WRIGHT BOULEVARD  
LIGHTING PLAN**

SHEET NO. 3 OF 5 SHEETS

STA. 119+00 TO STA. 128+50

F.A.U. RTL.	SECTION	COUNTY	TOTAL SHEETS	SHEET NO.
1351	06-00090-00-PV	COOK	137	97
CONTRACT NO. 63378				
FED. ROAD DIST. NO. 1 ILLINOIS FED. AID PROJECT ARA-M-8003 (809)				