 

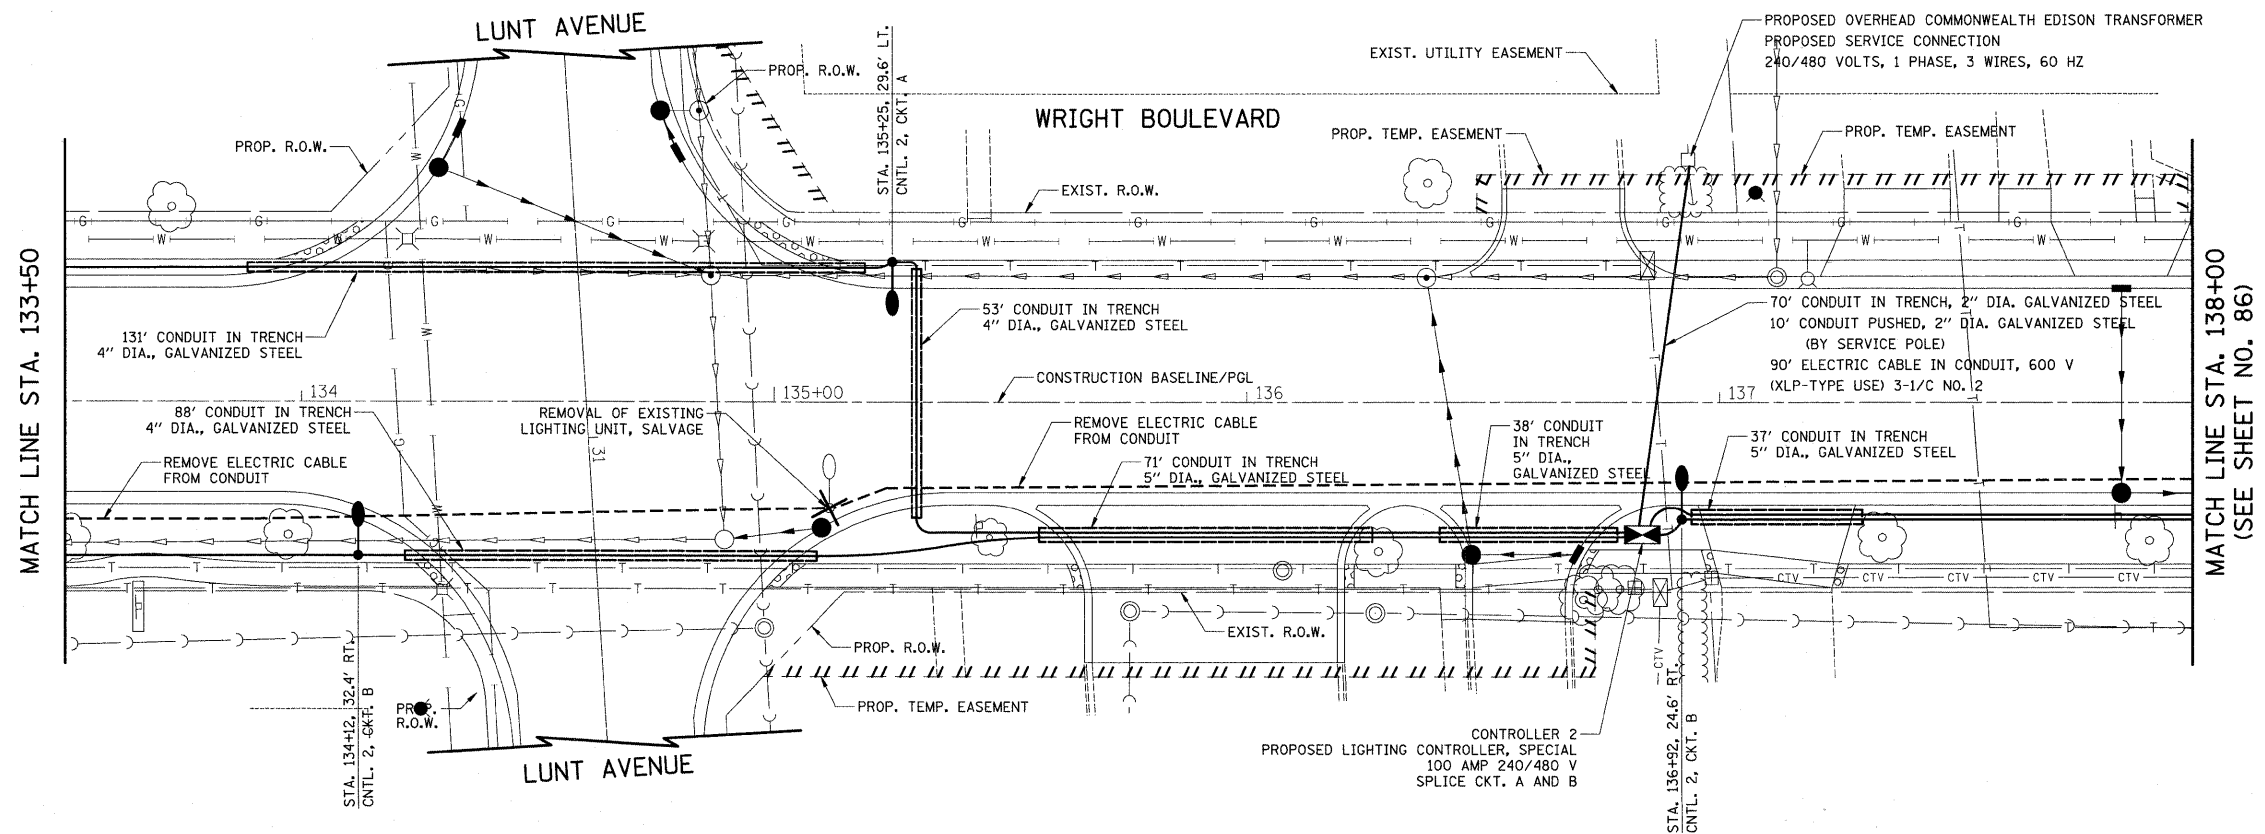


PLAN	SURVEYED	DATE
	PLOTTED	
	GRADES CHECKED	
	STRUCTURE NOTATIONS CHECKED	
	NOTE BOOK NO.	

PROFILE	SURVEYED	DATE
	PLOTTED	
	GRADES CHECKED	
	STRUCTURE NOTATIONS CHECKED	
	NOTE BOOK NO.	

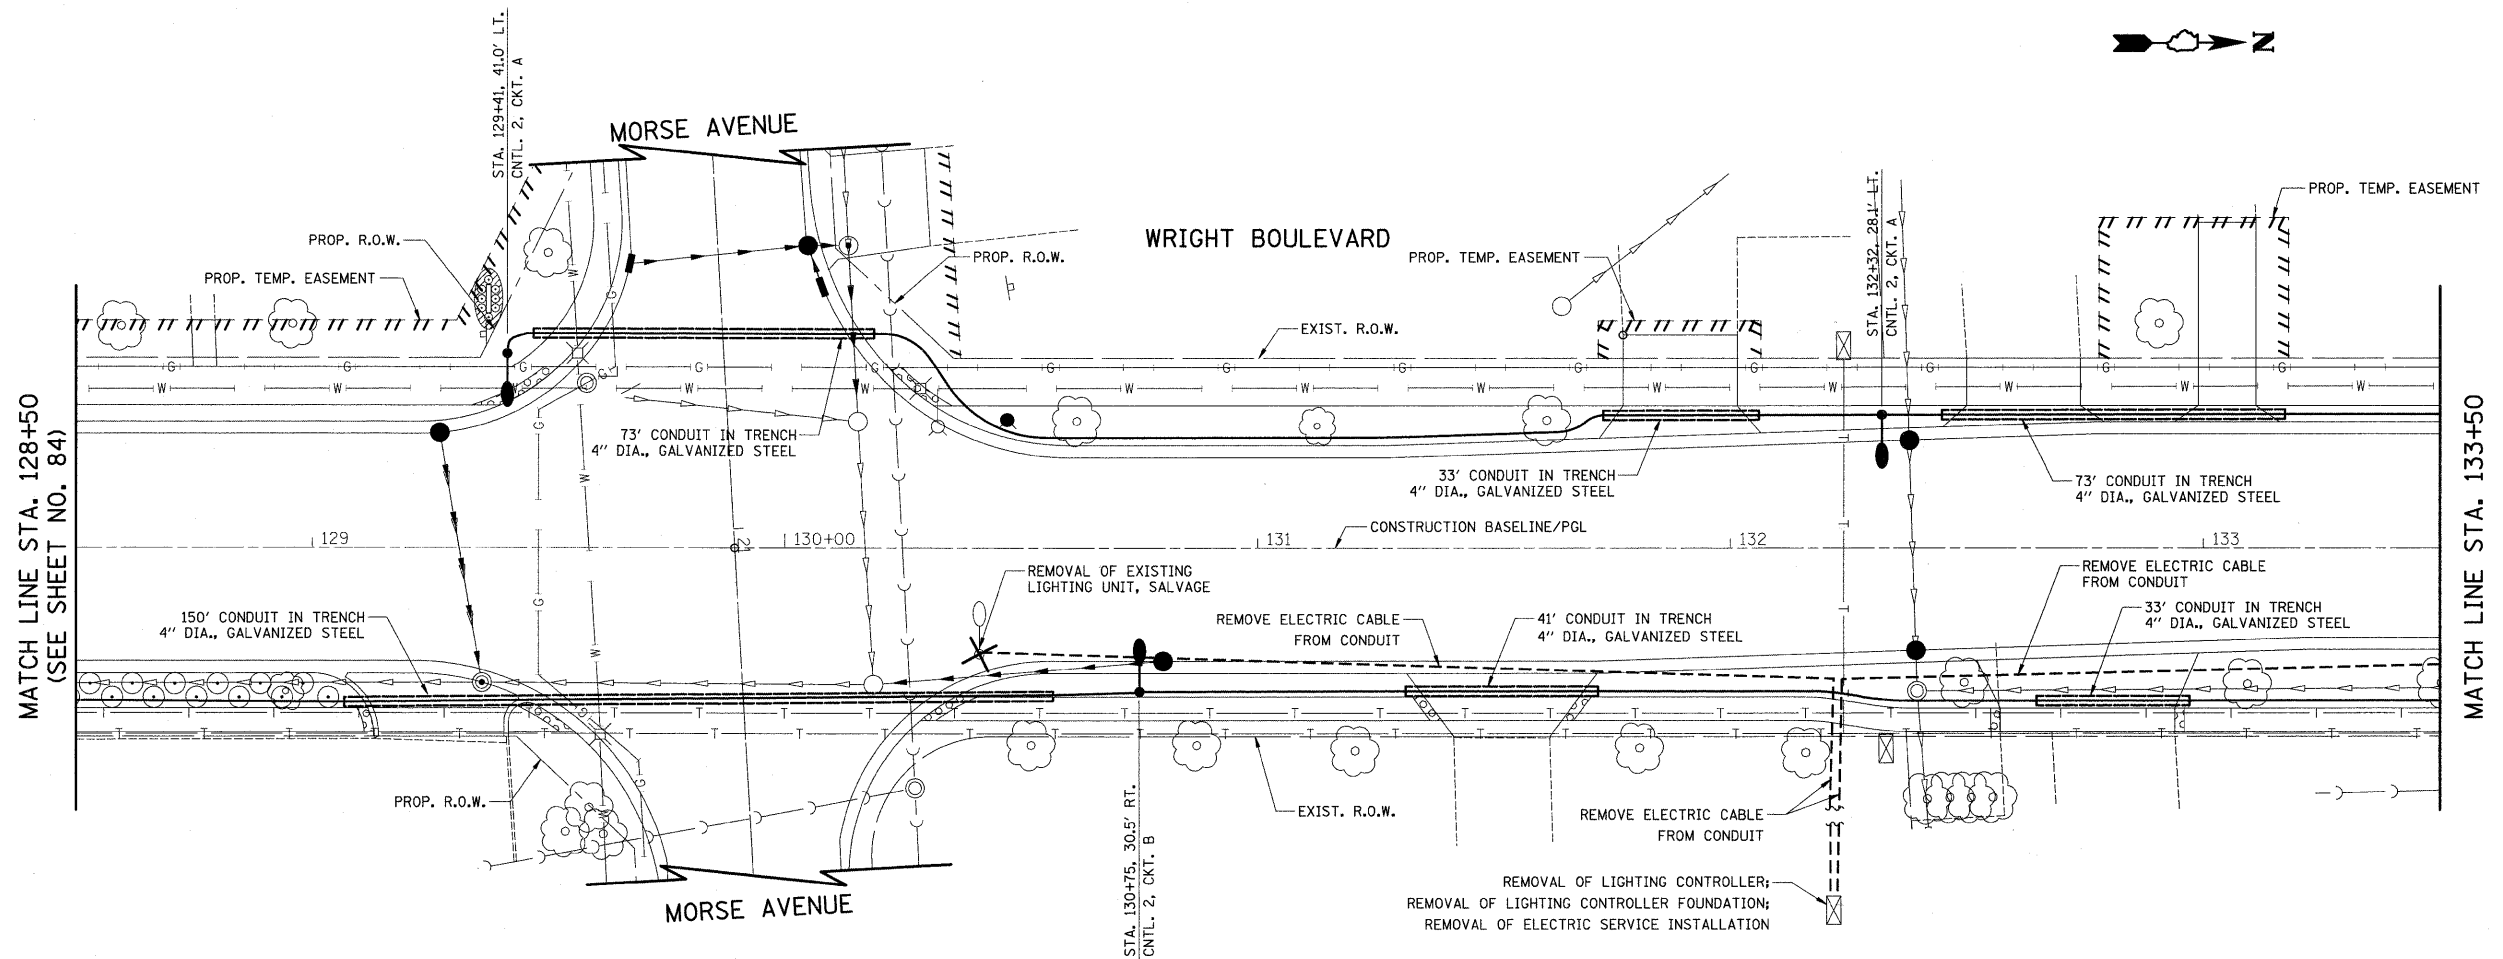

FILE NAME = J:\2215\oad\sheeta\2215_Light 04.dgn
 J:\2215\oad\sheeta\2215_Light 04.dgn

USER NAME = jat
 PLOT SCALE = 20,0000 ' / IN.
 PLOT DATE = 10/15/2009

DESIGNED - SJC
 DRAWN - CDC
 CHECKED - DNM
 DATE - 10-16-09

REVISED -
 REVISED -
 REVISED -
 REVISED -

**STATE OF ILLINOIS
 DEPARTMENT OF TRANSPORTATION**

**WRIGHT BOULEVARD
 LIGHTING PLAN**

SHEET NO. 4 OF 5 SHEETS STA. 128+50 TO STA. 138+00

F.A.U. RTE.	SECTION	COUNTY	TOTAL SHEETS	SHEET NO.
1351	06-00090-00-PV	COOK	137	98
CONTRACT NO. 63378				
FED. ROAD DIST. NO. 1 ILLINOIS FED. AID PROJECT ARA-M-8003 (809)				