 



PLAN	SURVEYED	DATE
	PLOTTED	BY
	GRADES CHECKED	
	STRUCTURE NOTATIONS CHECKED	
	NOTE BOOK NO.	
	CADD FILE NAME	

PROFILE	SURVEYED	DATE
	PLOTTED	BY
	GRADES CHECKED	
	STRUCTURE NOTATIONS CHECKED	
	NOTE BOOK NO.	
	CADD FILE NAME	

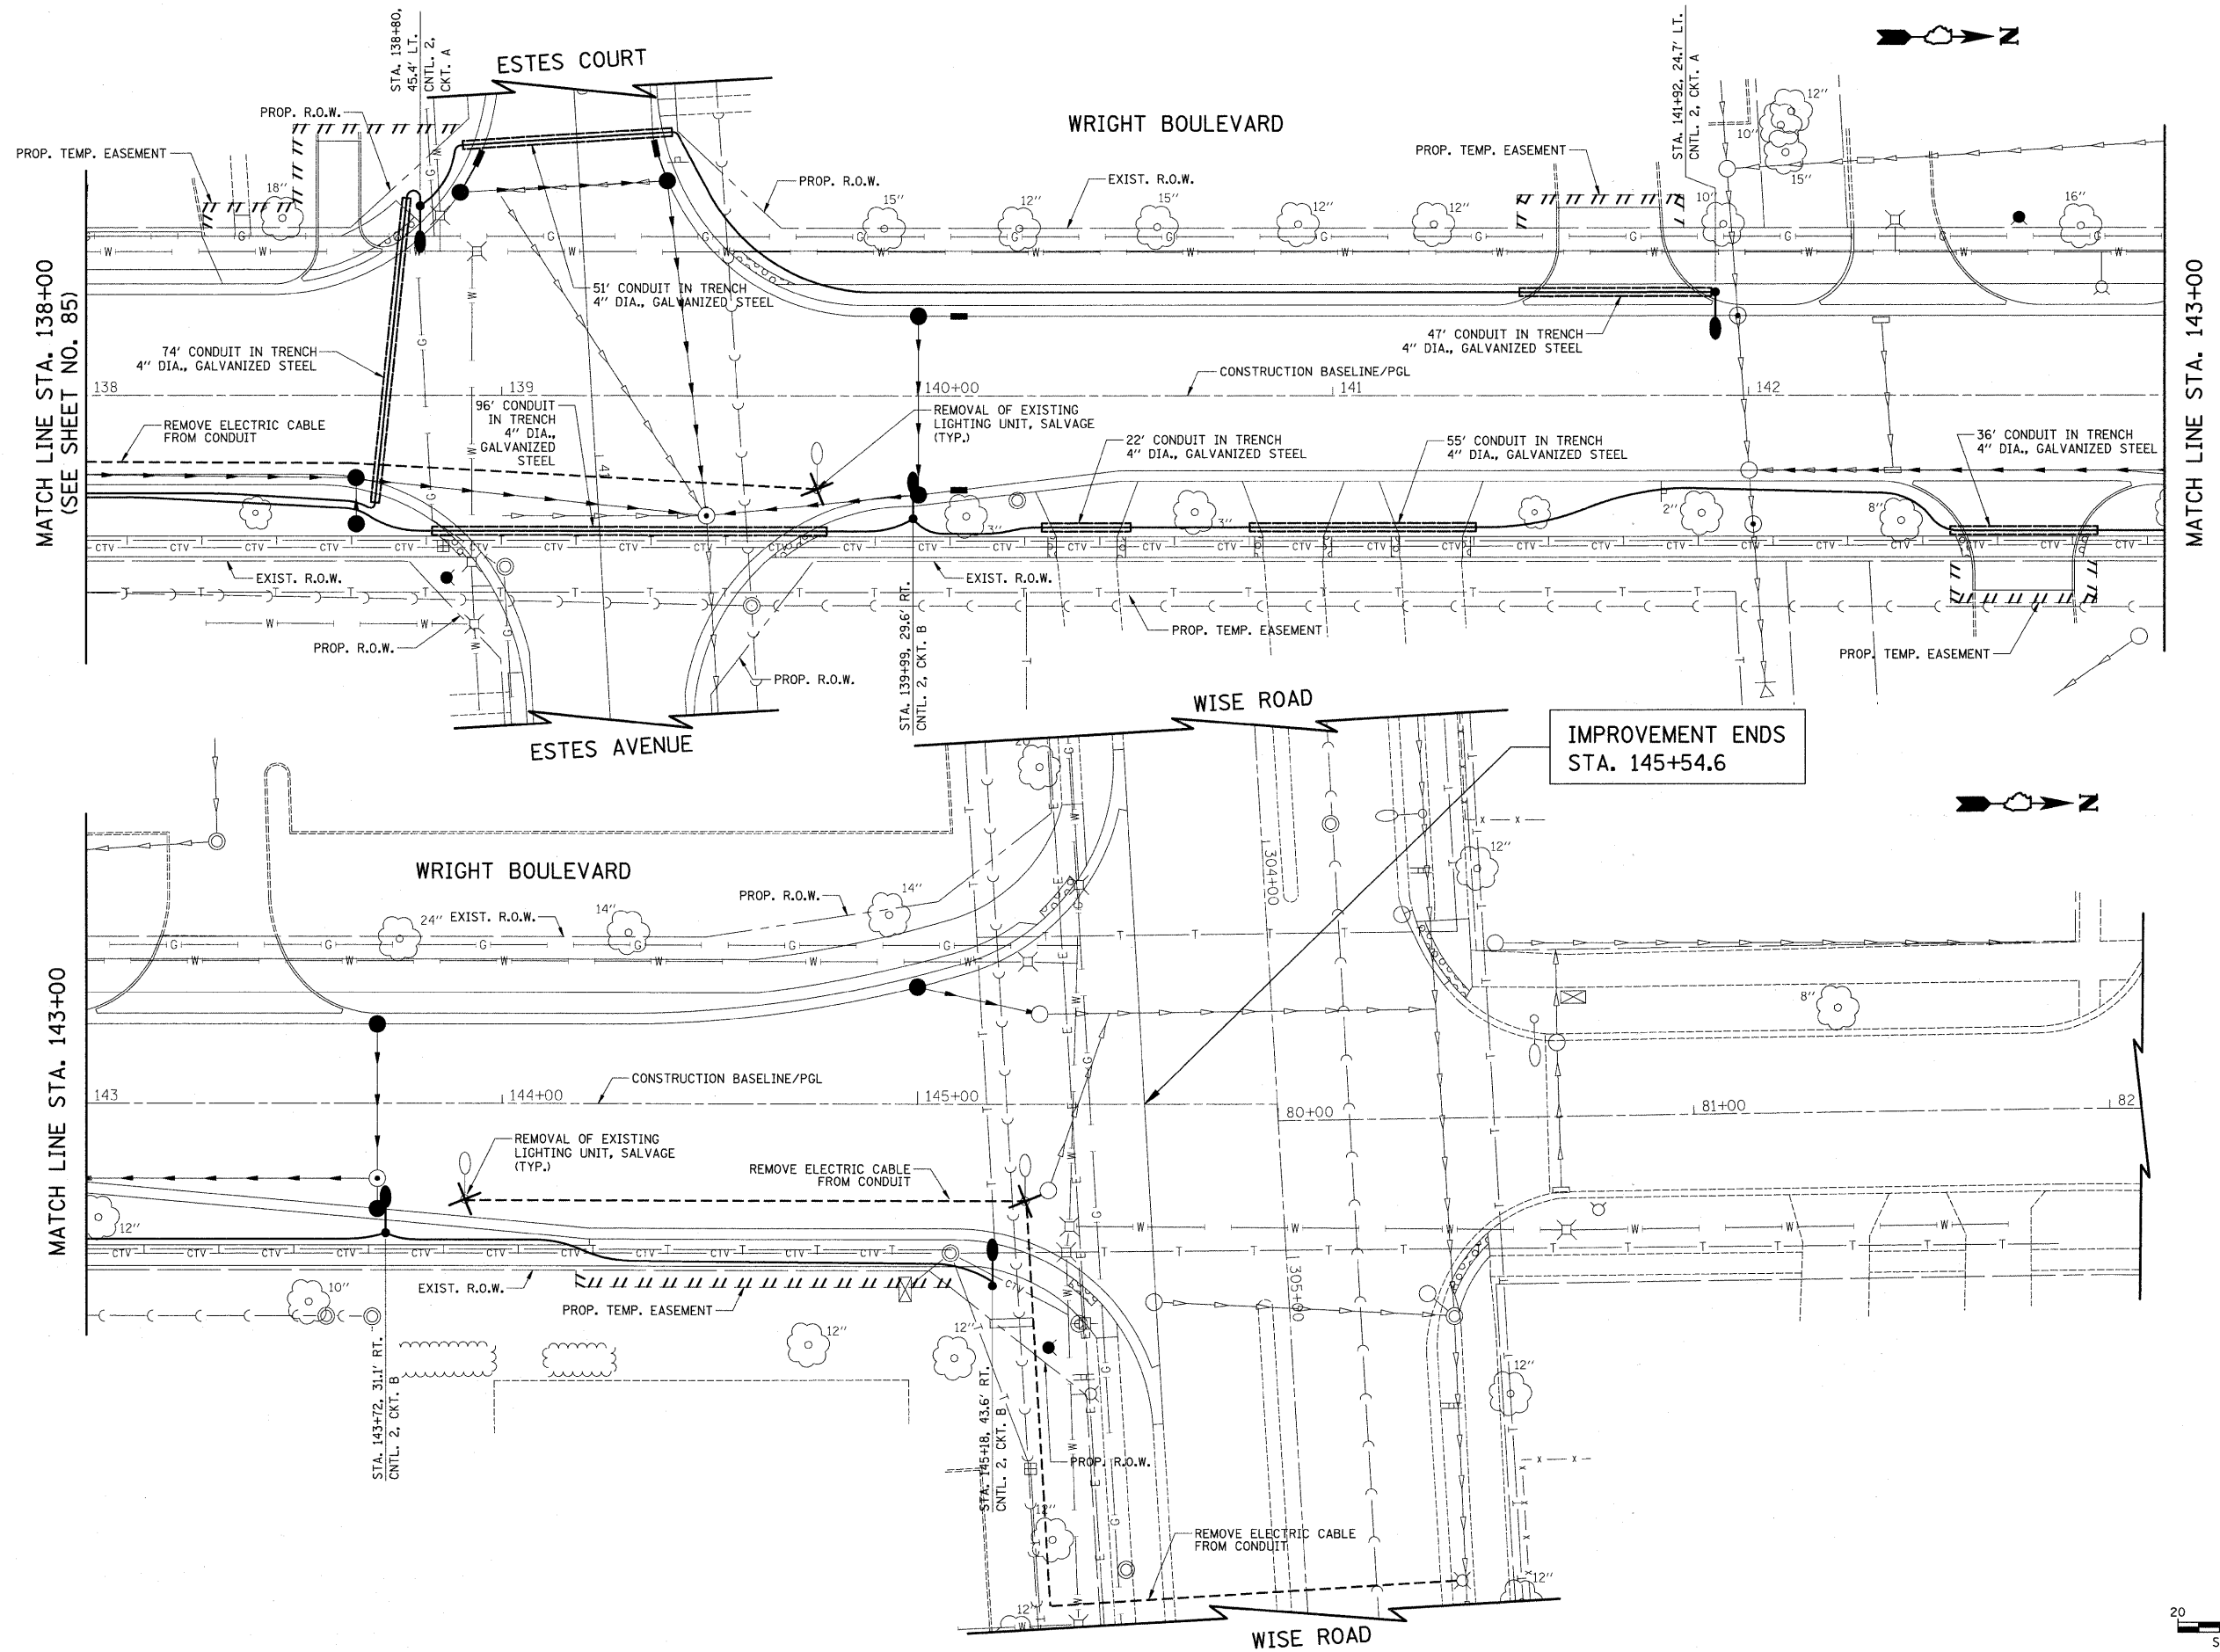

FILE NAME = J:\2215\road\sheet\2215.Lght 05.dgn

USER NAME = jat  
 PLOT SCALE = 20.0000' / IN.  
 PLOT DATE = 10/15/2009

DESIGNED - SJC  
 DRAWN - CDC  
 CHECKED - DNM  
 DATE - 10-16-09

REVISED -  
 REVISED -  
 REVISED -  
 REVISED -

**STATE OF ILLINOIS  
 DEPARTMENT OF TRANSPORTATION**

**WRIGHT BOULEVARD  
 LIGHTING PLAN**

SHEET NO. 5 OF 5 SHEETS      STA. 138+00 TO STA. 145+54.6

F.A.U. RTE.	SECTION	COUNTY	TOTAL SHEETS	SHEET NO.
1351	06-00090-00-PV	COOK	137	99
CONTRACT NO. 63378				
FED. ROAD DIST. NO. 1 ILLINOIS FED. AID PROJECT ARA-M-8003 (809)				