


BY: _____ DATE: _____
 SURVEYED _____
 PLOTTED _____
 CHECKED _____
 NOTE BOOK NO. _____
 ADD FILE NAME _____

BY: _____ DATE: _____
 SURVEYED _____
 PLOTTED _____
 CHECKED _____
 NOTE BOOK NO. _____
 ADD FILE NAME _____

10-14-2009 1618448 BONDHJUD
 C:\C:\WORKSPACE\BONDHJUD\M-FS-0844\JOB-TRANS.07\2282\28866-001\CTVIL\CA01\99 ALL CONTRACTS\CONV\SHETS\CONTRACT 03\03CONV-03-SHT-DRN\TLL-66800.DGN

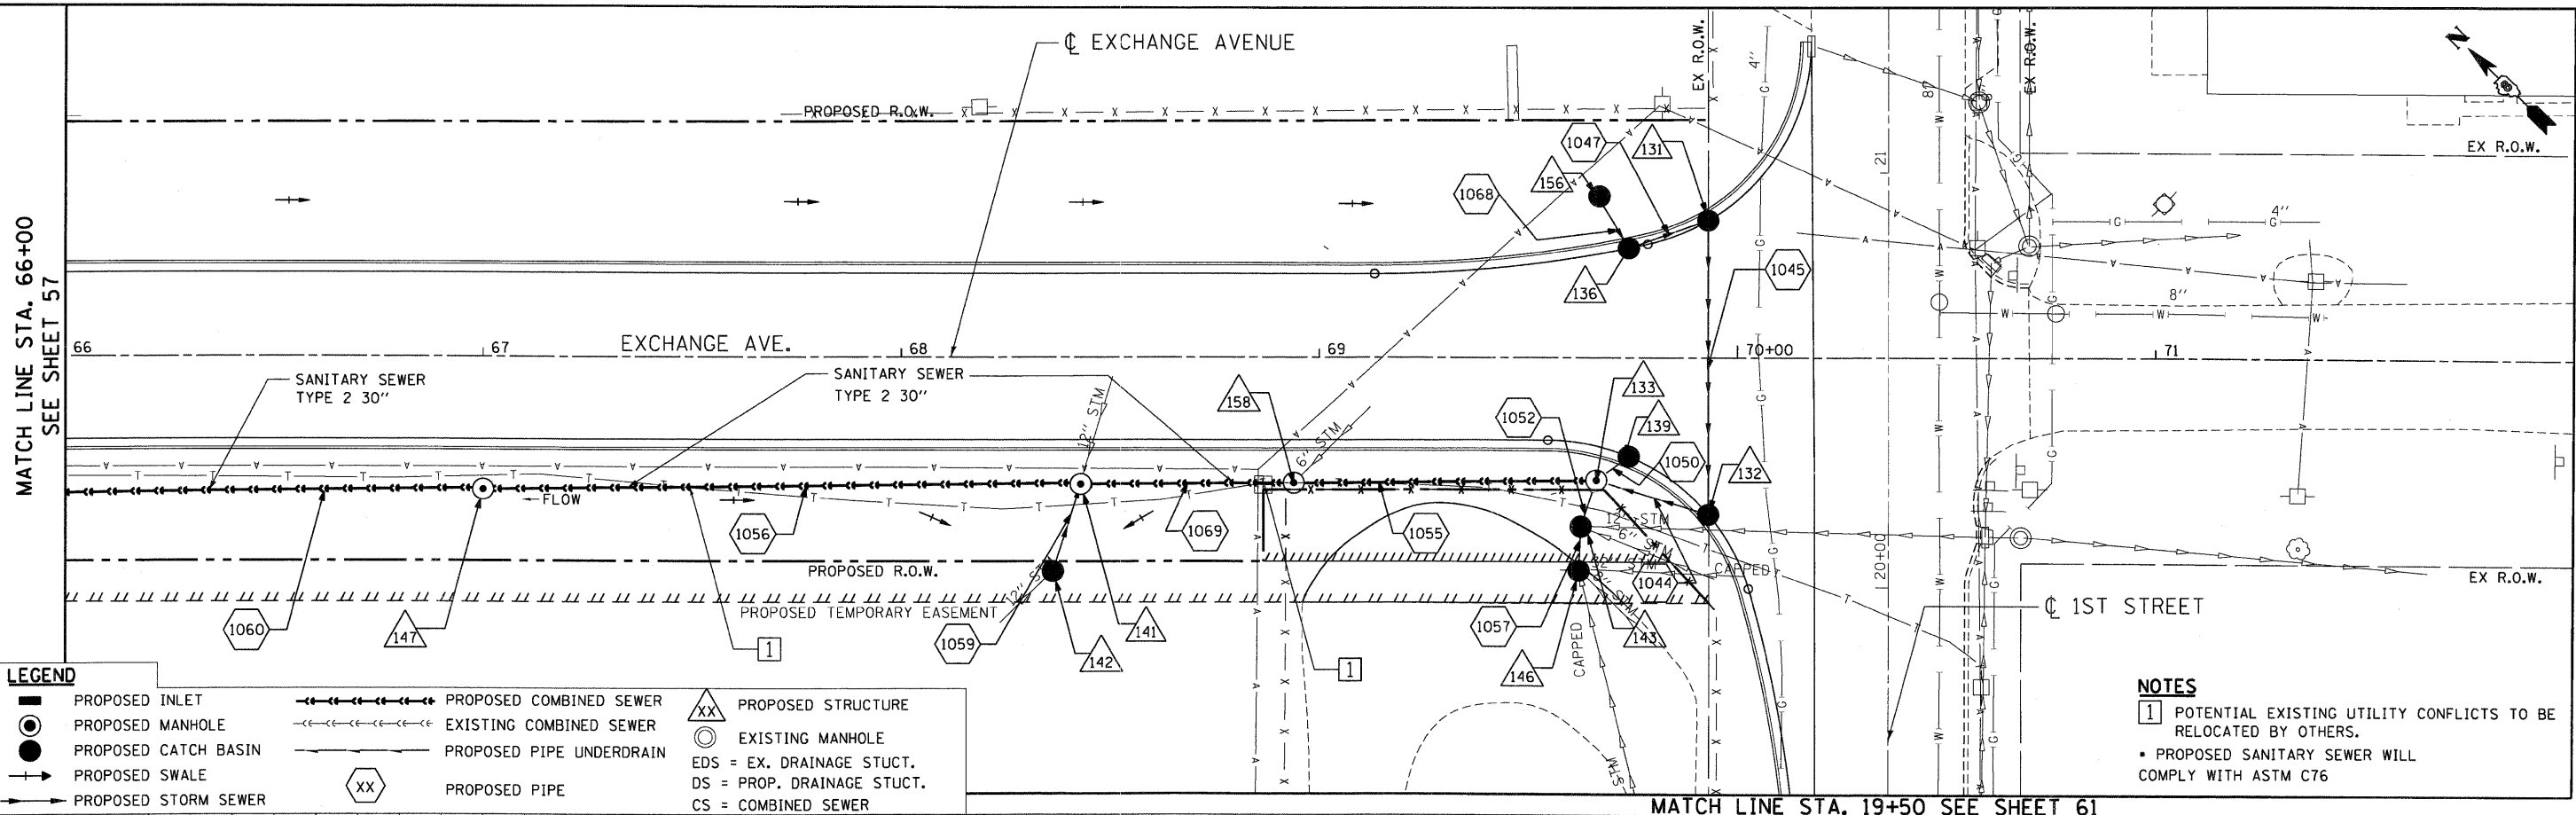


LEGEND

■	PROPOSED INLET	—●—●—●—●—	PROPOSED COMBINED SEWER	△XX	PROPOSED STRUCTURE
●	PROPOSED MANHOLE	—●—●—●—●—	EXISTING COMBINED SEWER	○	EXISTING MANHOLE
●	PROPOSED CATCH BASIN	—●—●—●—●—	PROPOSED PIPE UNDERDRAIN	EDS	EX. DRAINAGE STUCT.
+	PROPOSED SWALE	—●—●—●—●—	EXISTING PIPE UNDERDRAIN	DS	PROP. DRAINAGE STUCT.
→	PROPOSED STORM SEWER	XX	PROPOSED PIPE	CS	COMBINED SEWER

NOTES

1 POTENTIAL EXISTING UTILITY CONFLICTS TO BE RELOCATED BY OTHERS.

• PROPOSED SANITARY SEWER WILL COMPLY WITH ASTM C76

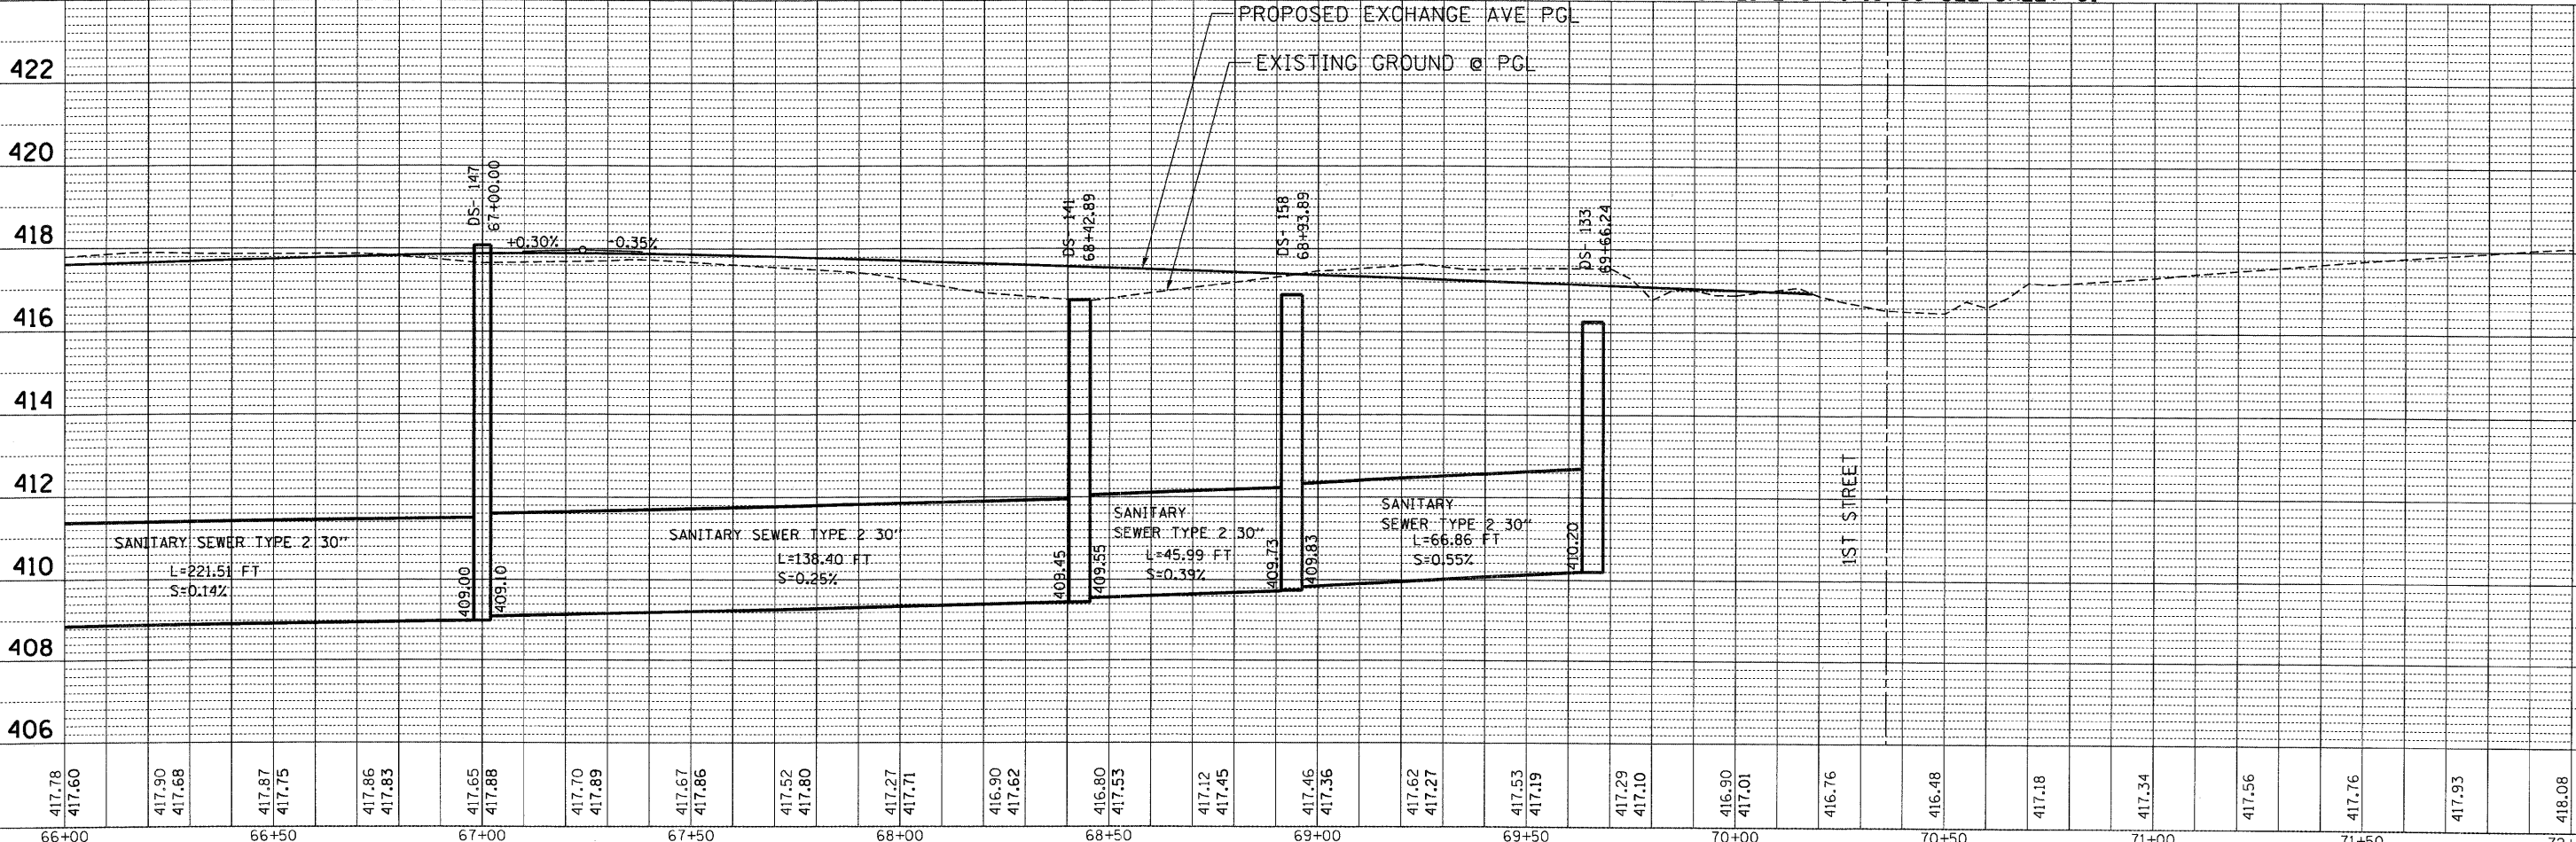

FILE NAME =	USER NAME = #USER*	DESIGNED - MMCG	REVISED -	STATE OF ILLINOIS DEPARTMENT OF TRANSPORTATION I-70 CONNECTION	PROPOSED DRAINAGE PLAN & PROFILE EXCHANGE AVENUE STA. 66+00.00 TO STA. 72+00.00	F.A.P. RTE.	SECTION	COUNTY	TOTAL SHEETS	SHEET NO.
\$FILEL\$	PLOT SCALE = #SCALE*	DRAWN - MMCG	REVISED -			9153	82-1K	ST. CLAIR	107	58
	CHECKED - TKL	REVISD -	REVISED -			CONTRACT NO. 76C40				
	PLOT DATE = #DATE*	DATE - 10/09/09	REVISED -			FED. ROAD DIST. NO. ILLINOIS FED. AID PROJECT				