


NOTES:

1. INTERCONNECT CONDUIT TO BE PLACE 1' BEHIND BACK OF CURB FROM 92+40 TO 106+38.
2. FIBER OPTIC CABLE TO BE PLACE BY OTHERS AS A PART OF A FUTURE CONTRACT.
3. HANDHOLES NOT LABELED WITH STATION OFFSET ARE GIVEN ON THE LIGHTING PLANS.

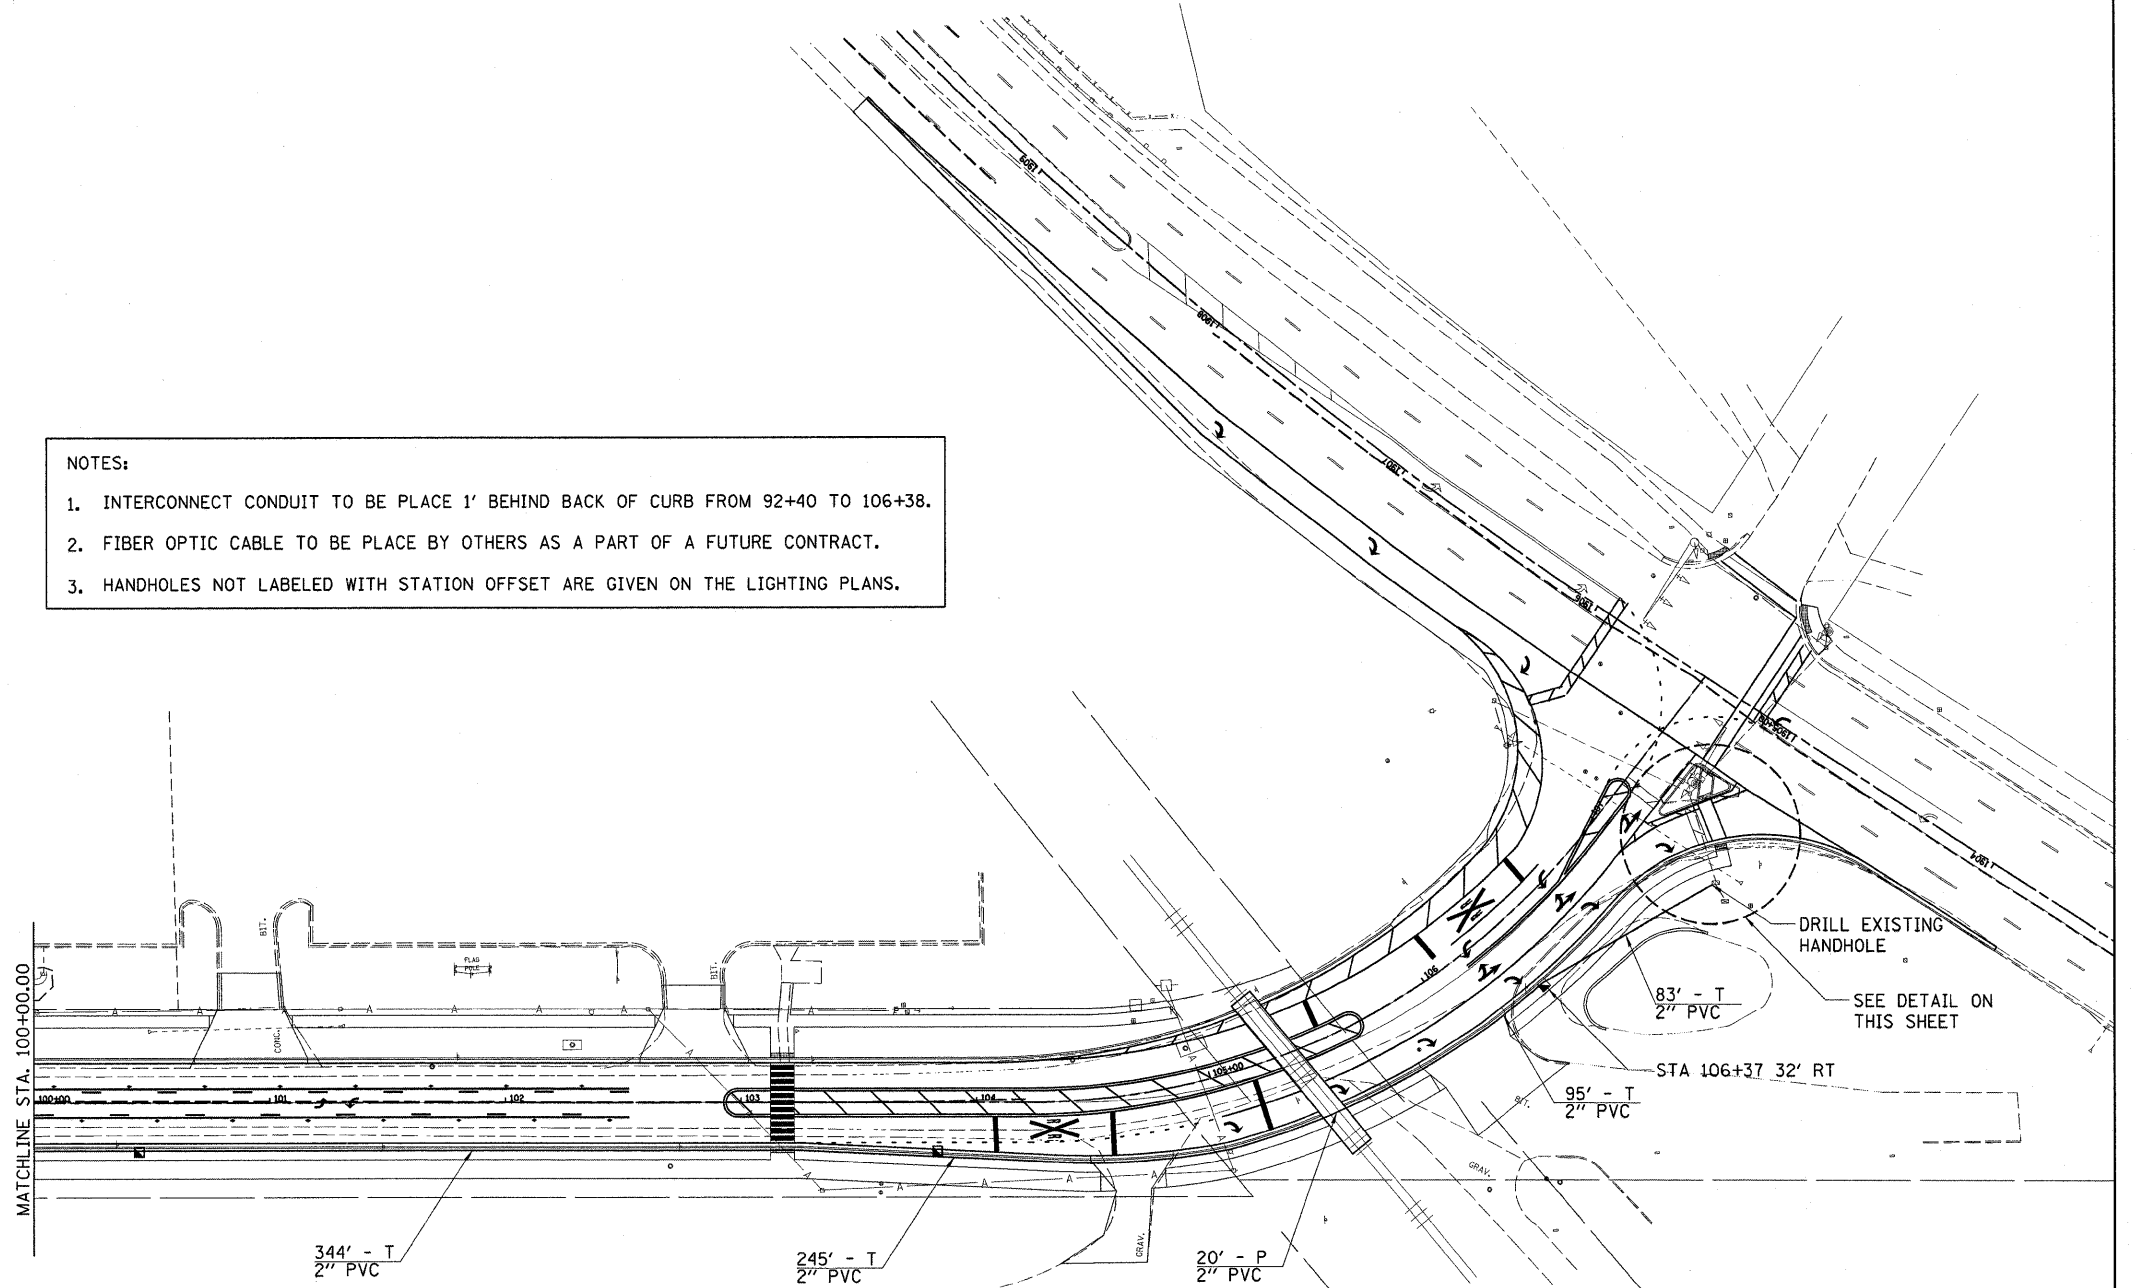

© Copyright Hanson Professional Services Inc. 2009
HANSON
 Hanson Professional Services Inc.

FILE NAME =	USER NAME = Ander-00846	DESIGNED - KNB	REVISED -	STATE OF ILLINOIS DEPARTMENT OF TRANSPORTATION	NORTHMOOR RD. INTERCONNECT CONDUIT PLAN	F.A.U. RTE.	SECTION	COUNTY	TOTAL SHEETS	SHEET NO.
I:\09\Jobs\09L0227B\CADD\Road\Sheet\c-101.dgn		DRAWN - KNB	REVISED -			6647	08-00302-00-PV	PEORIA	85	43
PLOT SCALE = 40.0000' / 1" =		CHECKED - TMA	REVISED -			09-00047-01-PV		CONTRACT NO. 89526		
PLOT DATE = 10/16/2009		DATE - 10/16/2009	REVISED -			SCALE: 1"=40'		SHEET NO. OF SHEETS STA. TO STA.		FED. ROAD DIST. NO. ILLINOIS FED. AID PROJECT ARA-M-5093(139)