


KEYED NOTES:

- 1 NEW 250 HPS LUMINAIRE MOUNTED ON NEW 40 FT. POLE.
- 2 2-1/C NO. 6, 600 XLP, 1-1/C NO. 6 G., 600 XLP, 2" PVC CONDUIT IN TRENCH.

SHEET NOTES:

- 1. SEE TRAFFIC SIGNAL PLANS FOR ALL REMOVAL ITEMS.
- 2. SEE TRAFFIC SIGNAL PLANS FOR PROPOSED LUMINAIRE LOCATIONS ON PROPOSED COMBINATION MAST ARM ASSEMBLY AND POLE.

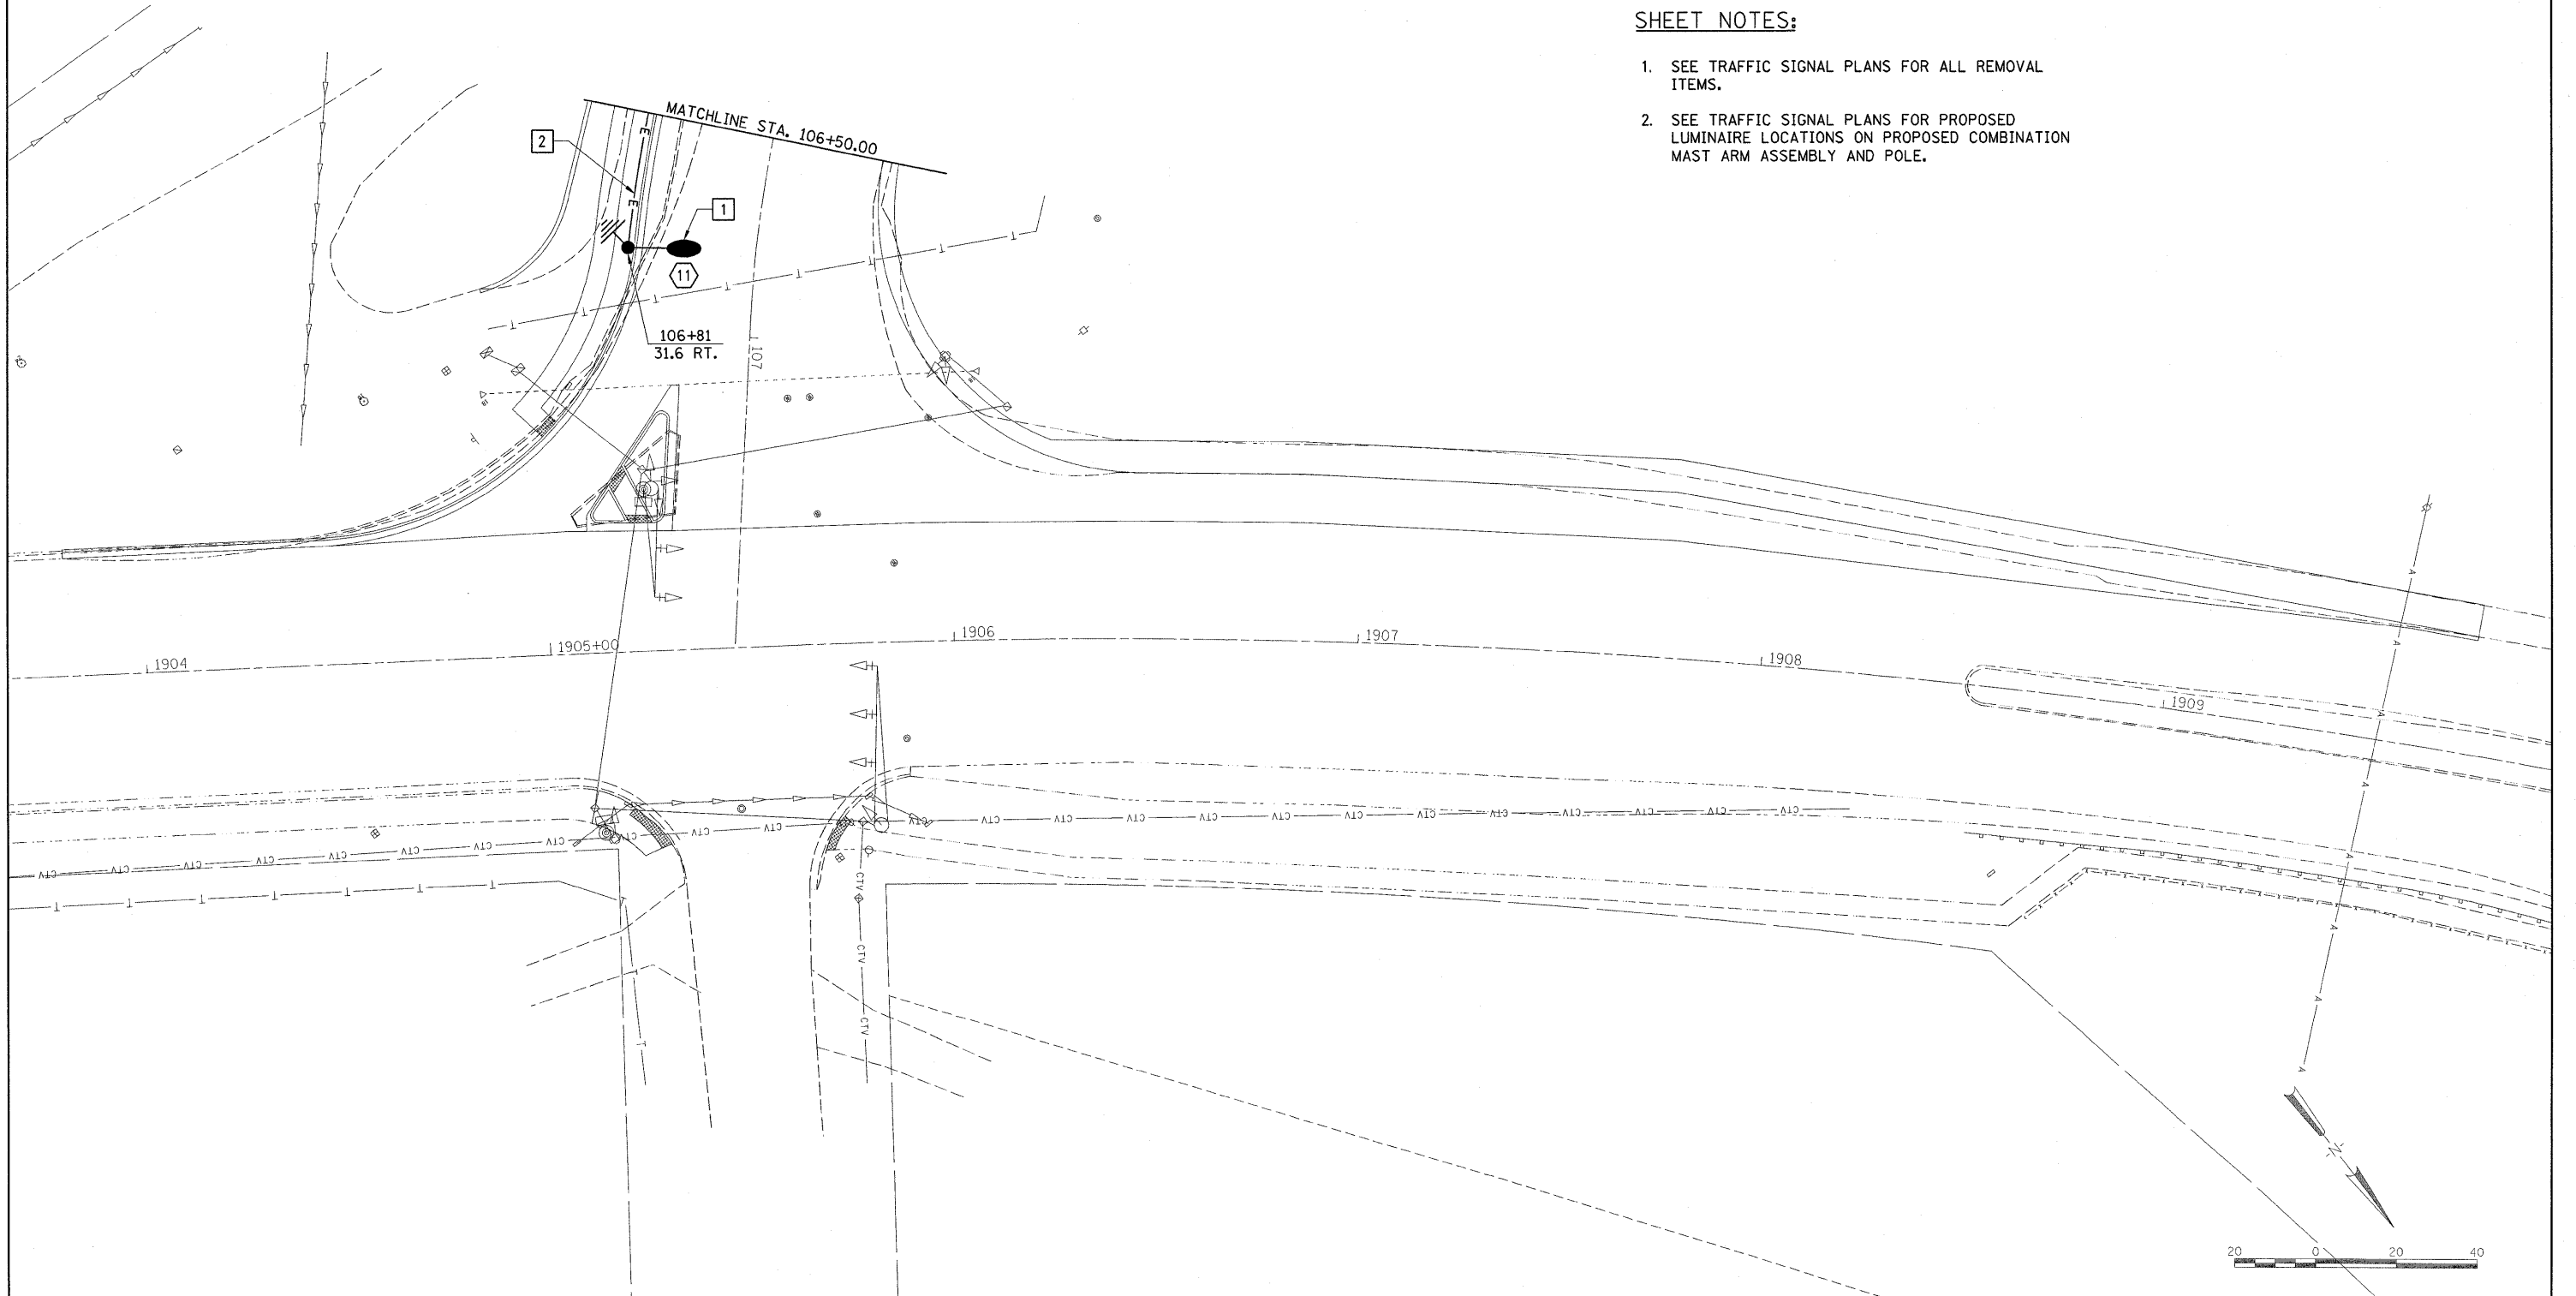

© Copyright Hanson Professional Services Inc. 2009
HANSON
 Hanson Professional Services Inc.



FILE NAME =	USER NAME = Ander00846	DESIGNED - PJG	REVISED -	STATE OF ILLINOIS DEPARTMENT OF TRANSPORTATION	LIGHTING PLAN NORTHMOOR ROAD STAGE 3 IMPROVEMENT			F.A.U. RTE.	SECTION	COUNTY	TOTAL SHEETS	SHEET NO.		
I:\09\Jobs\09L2027B\CADD\Elec\Sheet\04.dgn		DRAWN - ANC	REVISED -		SCALE: 1:20	SHEET NO. 5 OF	SHEETS	STA. 106+50	TO STA. 107+00	6647	08-00302-00-PV	PEORIA	85	50
		CHECKED - RDN	REVISED -								09-00047-01-PV	CONTRACT NO. 89526		
		DATE - 10/16/09	REVISED -					FED. ROAD DIST. NO.	ILLINOIS	FED. AID PROJECT	ARA-M-50931(139)			