
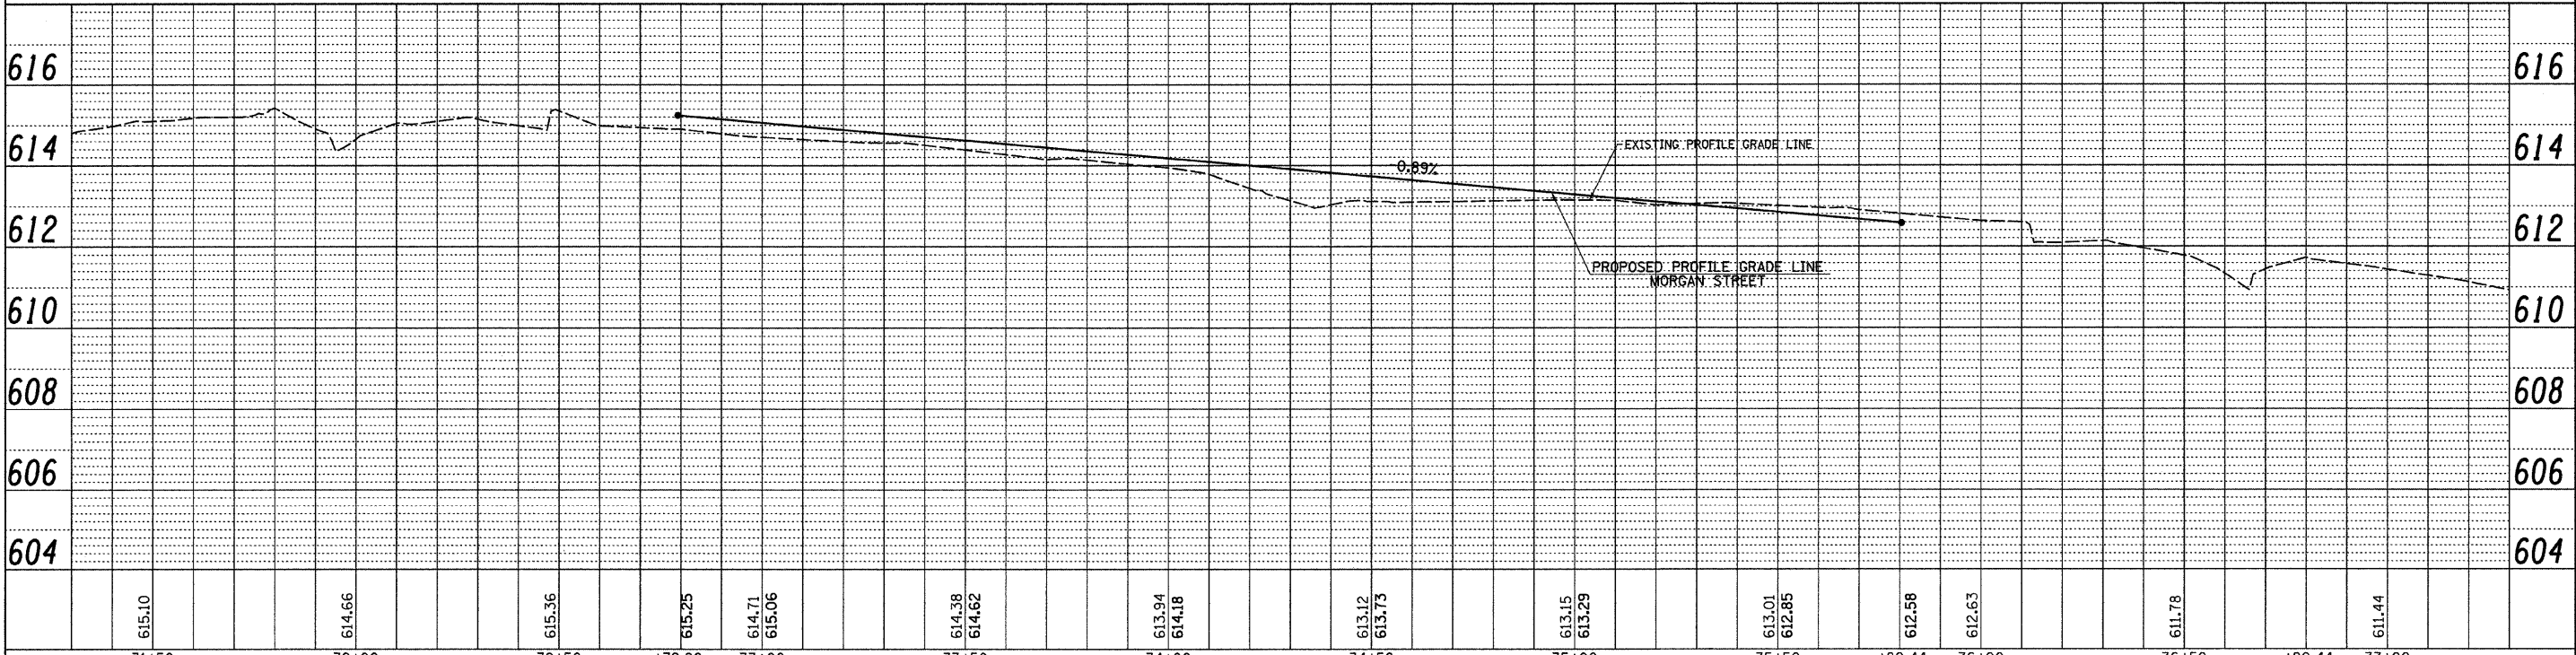
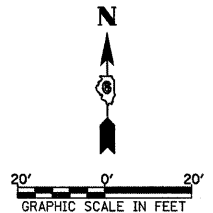


DATE: _____ BY: _____
 REVISIONS: _____
 PLAN: _____
 NO. _____

DATE: _____ BY: _____
 REVISIONS: _____
 PROFILE: _____
 NO. _____

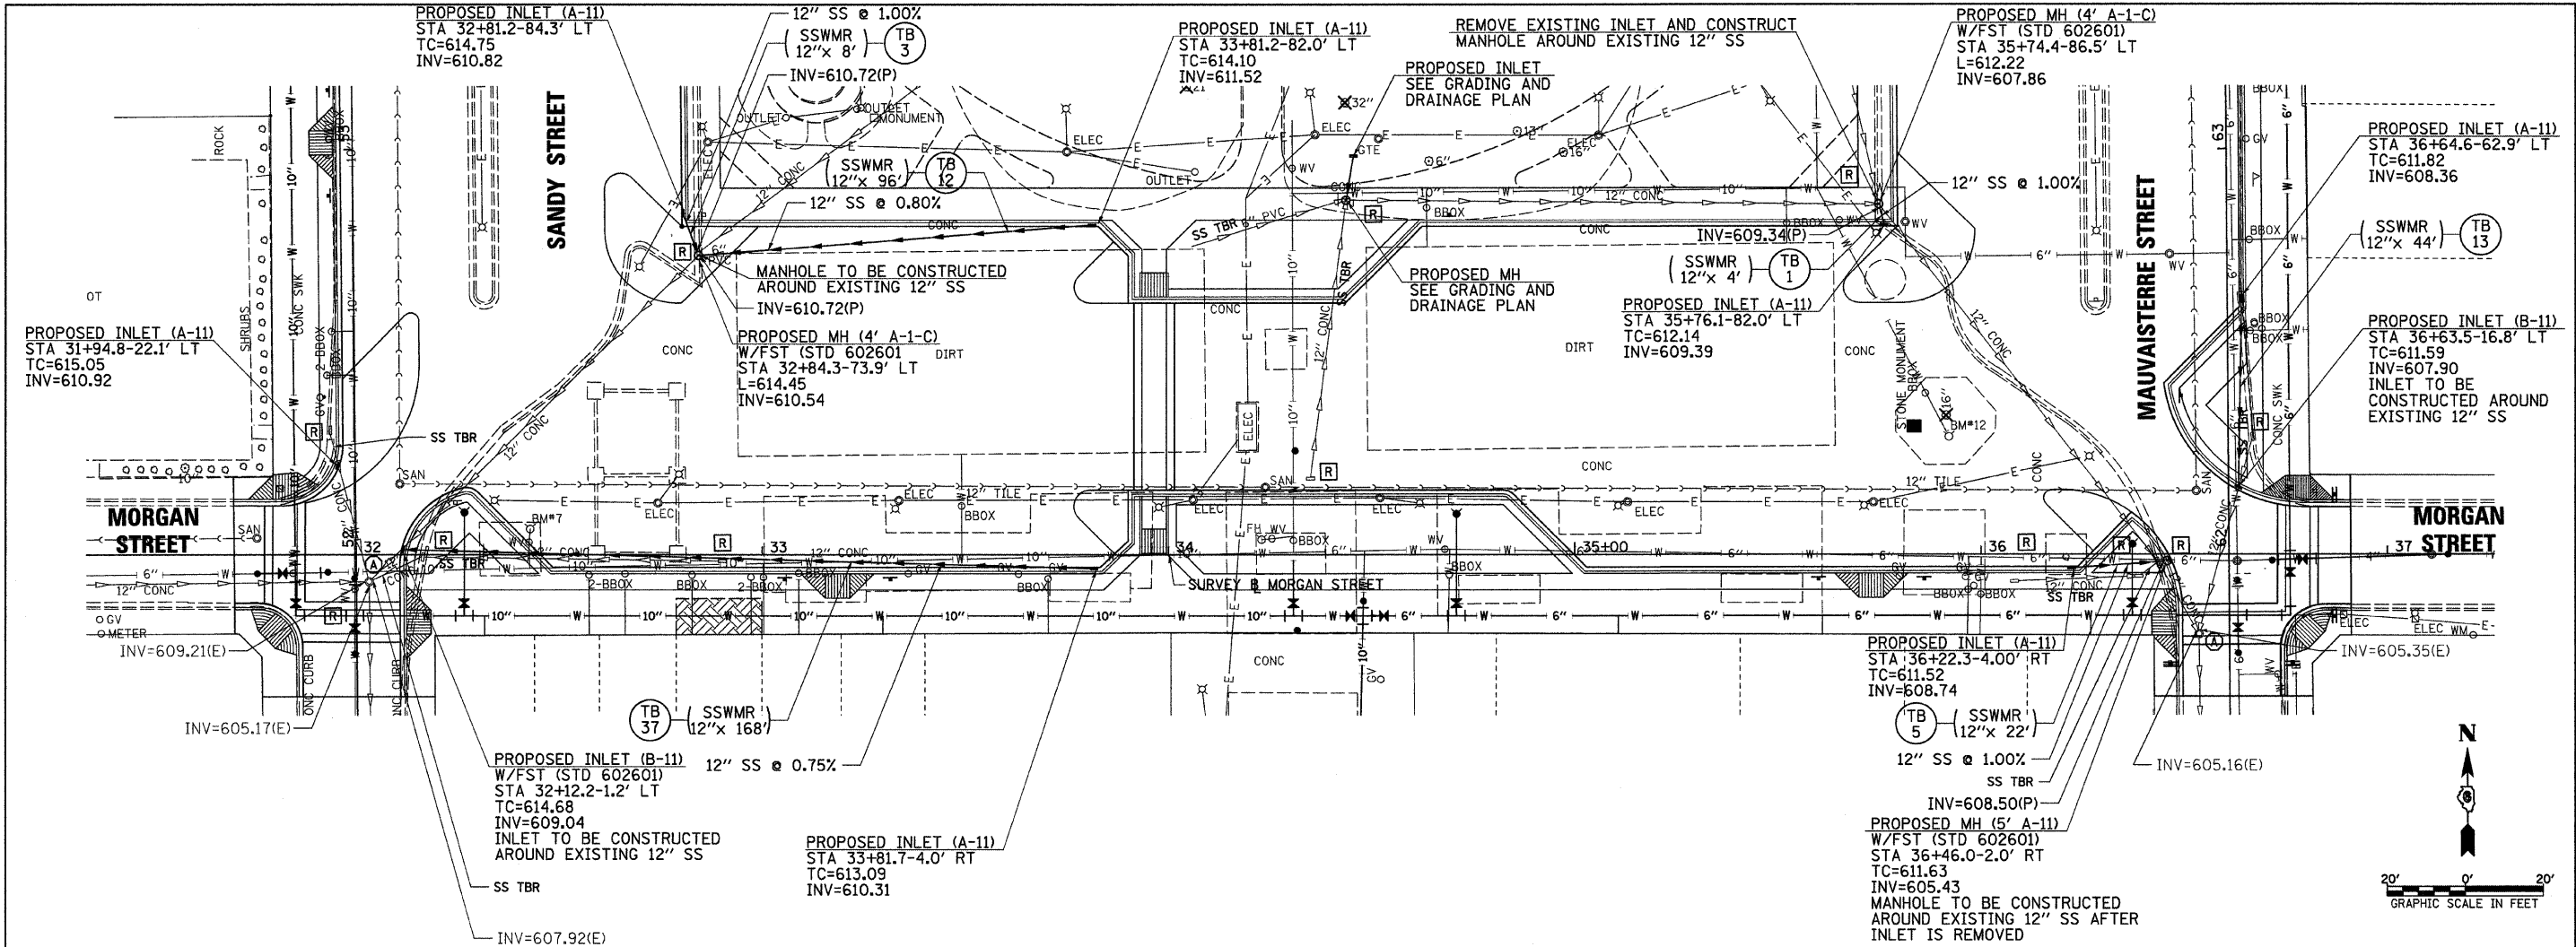

FILE NAME =	USER NAME = jwhite	DESIGNED - JRB	REVISED -	STATE OF ILLINOIS DEPARTMENT OF TRANSPORTATION	CITY OF JACKSONVILLE DOWNTOWN PLAZA STREETS RECONSTRUCTION MORGAN STREET DRAINAGE PLAN & PROFILE SHEET	F.A.U. / R.T.E.	SECTION	COUNTY	TOTAL SHEETS	SHEET NO.
vr\2522\plaza plans\MORGANDRAINPP1.dgn	DRAWN - JMO	REVISOR -	N/A			05-00121-00-PV	MORGAN	74	28	CONTRACT NO. 93504
PLOT SCALE = 28.0000' / IN.	CHECKED - JRB	REVISOR -	SCALE: 1" = 20'			SHEET NO. OF SHEETS	STA. 31+70.00 TO STA. 36+91.04	FED. ROAD DIST. NO. 6	ILLINOIS	FED. AID PROJECT
PLOT DATE = 9/25/2009	DATE - 09/25/09	REVISOR -								