


F.A.U. RTE.	SECTION	COUNTY
9314	09-00034-00-ES	MONROE

CONTRACT NO. 97403
FEDERAL AID PROJECT

SHEET NO.
15


Job No. 119-06-3
Date: 10/15/09
Scale: 1"=10'
Drawn by: BEC
Design by: BEC
Approved by: CMB
File Name: PLN

REVISIONS
5/27/08 RESURF IL 156
1/30/09 REVISED SITE PLAN
7/2/09 PLAN SPLIT

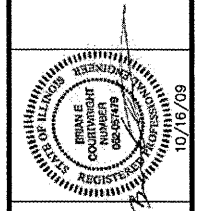

CBB Crawford, Bunte, Brammeier
Traffic and Transportation Engineers
St. Louis, Missouri / Glen Carbon, Illinois
314-878-6644 618-656-2612
Fax: 314-878-5876 E-Mail: cbb@cbbtraffic.com

ROADWAY
MAEYSTOWN RD SECTIONS
MONROE COUNTY
IL 156 & MAEYSTOWN ROAD
WATERLOO, ILLINOIS

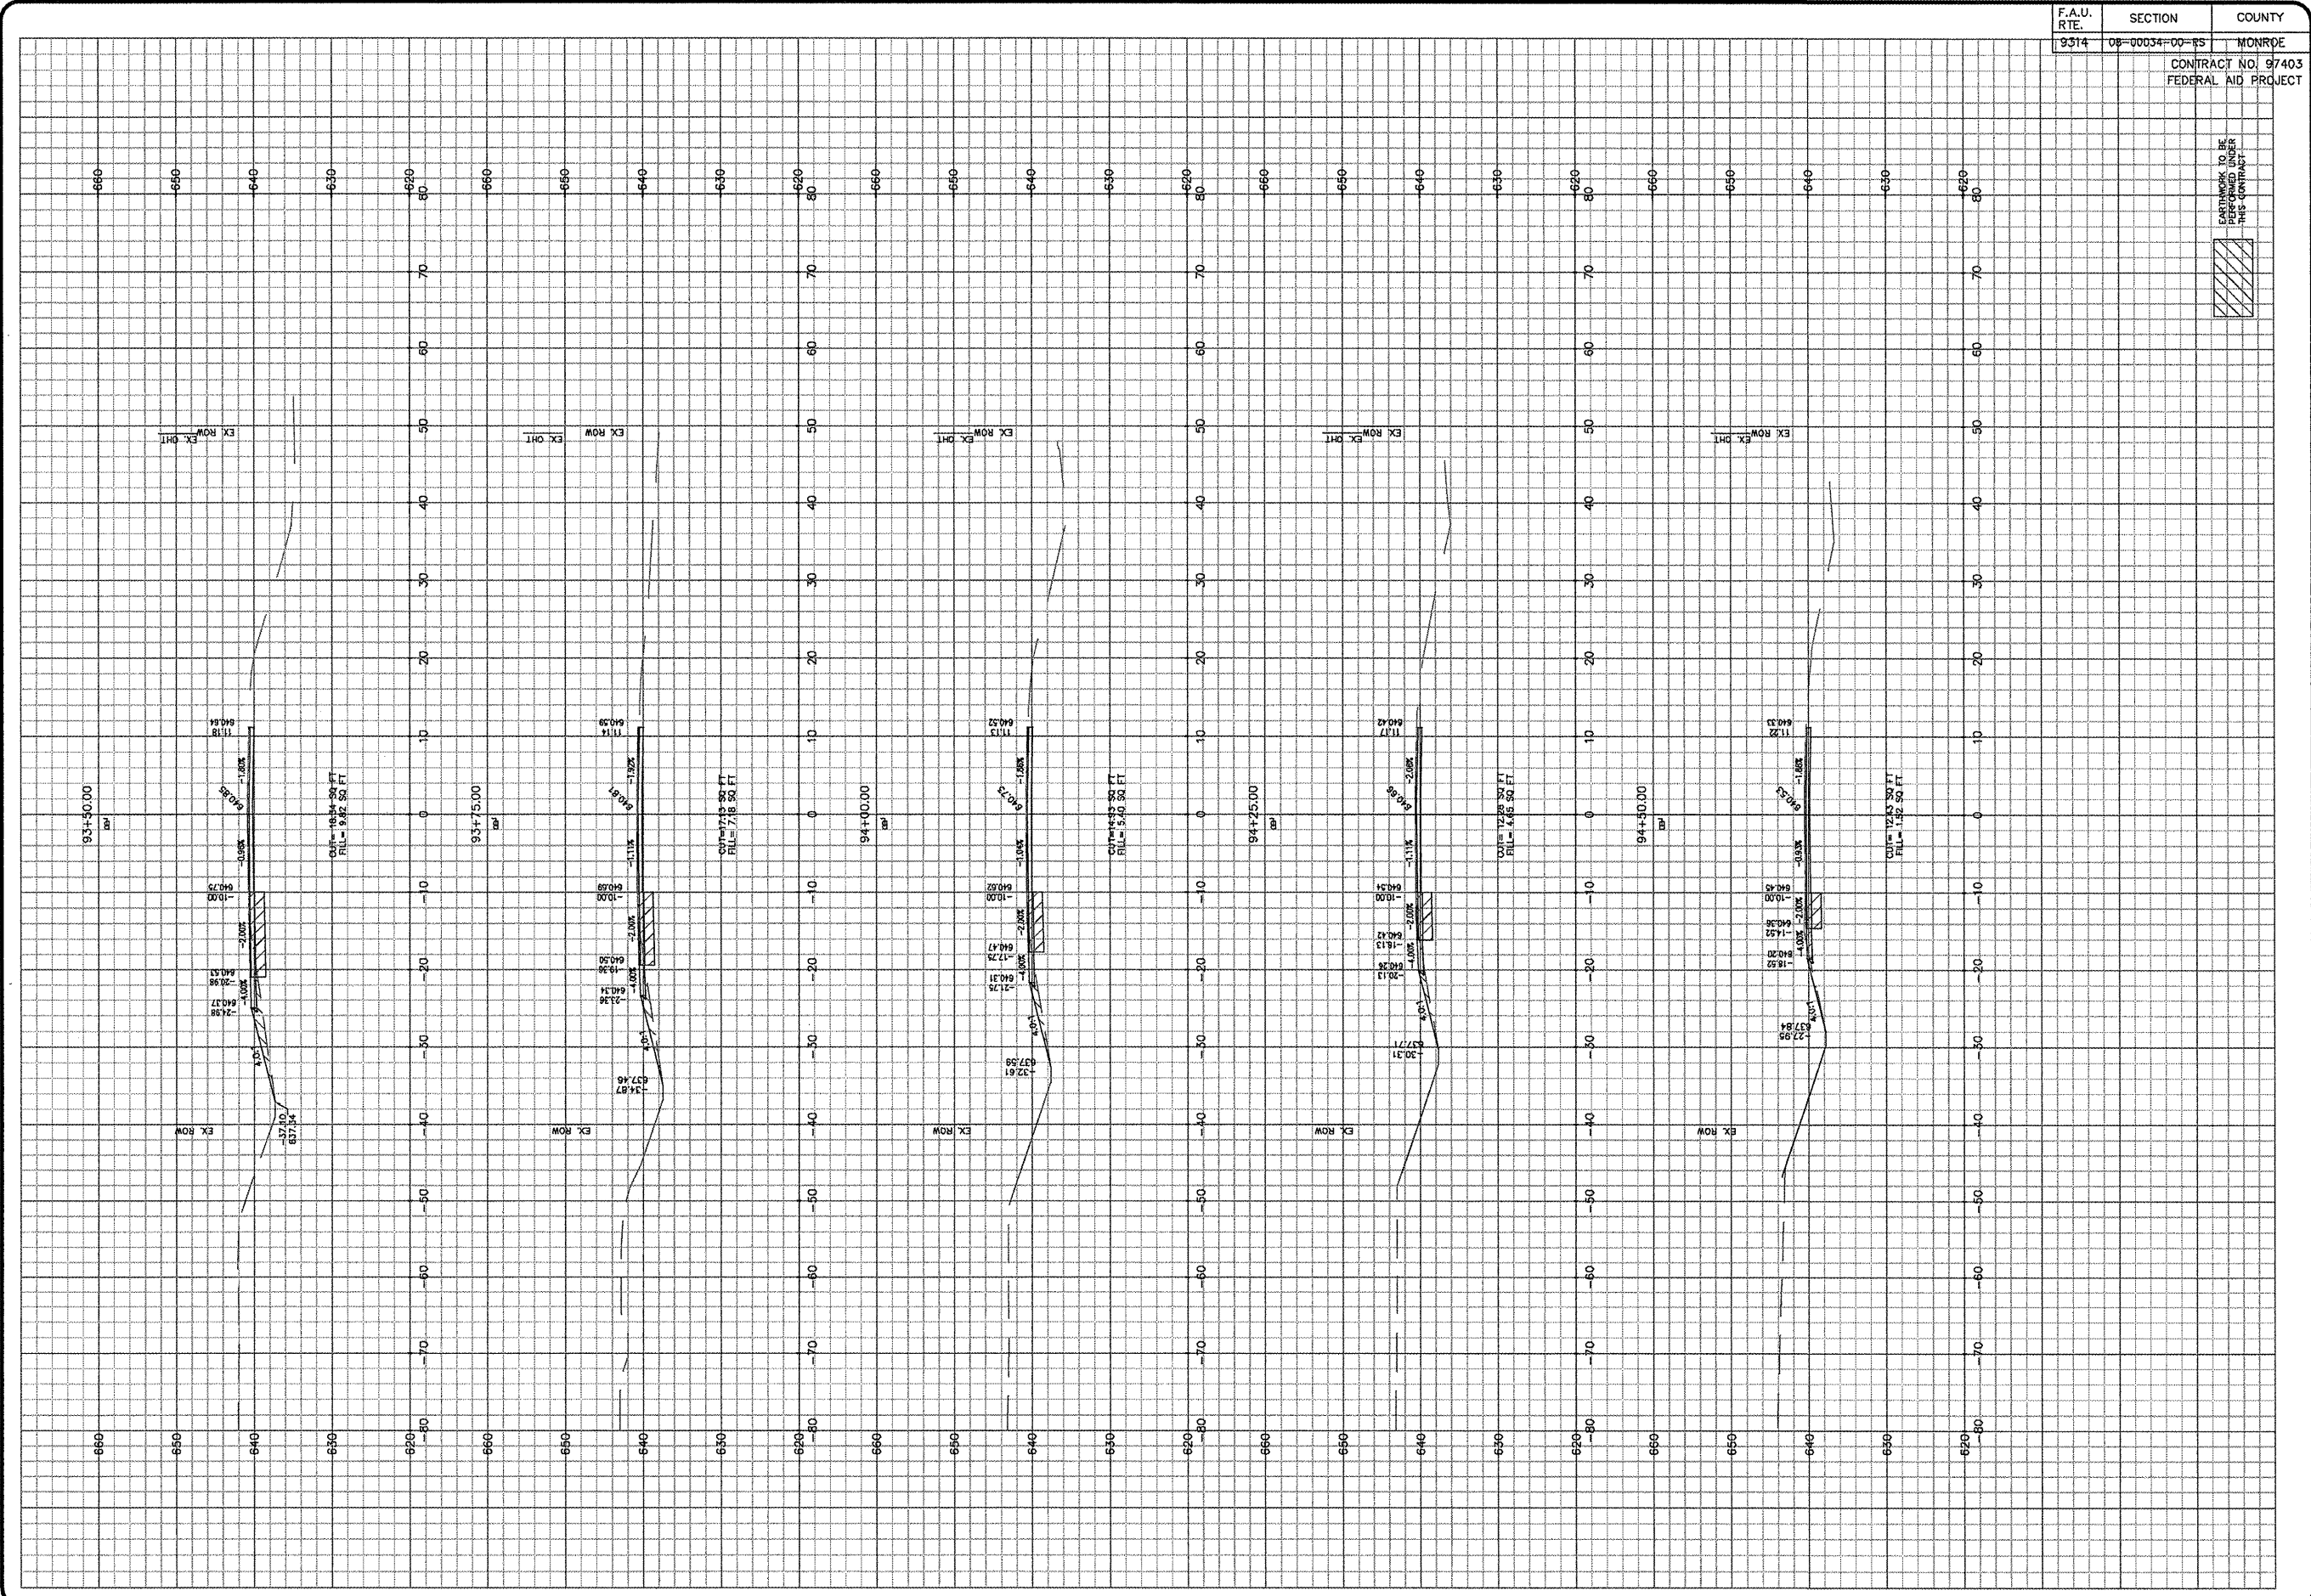

EARTHWORK TO BE CHECKED BY CONTRACTOR