


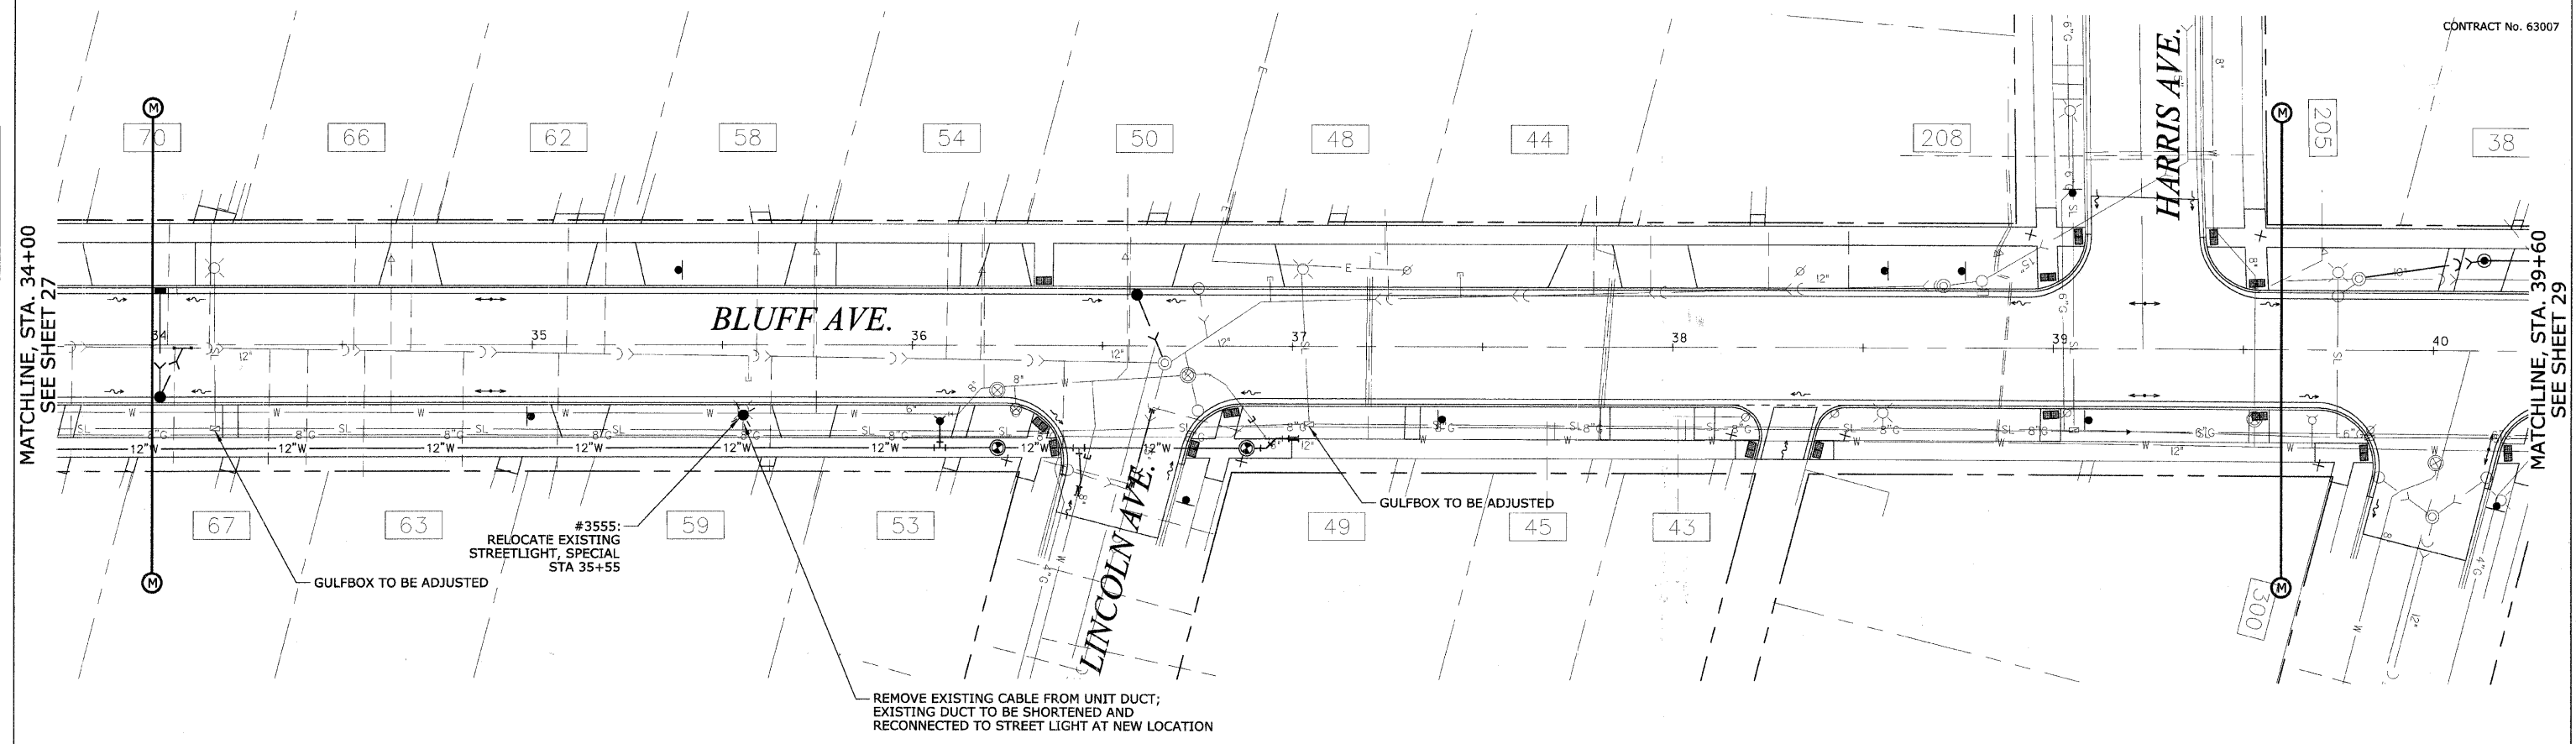

CONTRACT No. 63007



PLAN	DATE
BY	
REVISIONS	
NO.	
DATE	
BY	
REVISIONS	
NO.	
DATE	
BY	

PROFILE	DATE
BY	
REVISIONS	
NO.	
DATE	
BY	
REVISIONS	
NO.	
DATE	
BY	

REVISIONS	
NAME	DATE

ILLINOIS DEPARTMENT OF TRANSPORTATION  
**BLUFF AVENUE IMPROVEMENTS**  
**STAGE 1**  
**ELECTRICAL/STREETLIGHTING PLAN**

SCALE: 1" = 20' H (Full Size)  
1" = 44' H (Tabloid)

DATE 07/18/2008

DRAWN BY H&A  
CHECKED BY PFH