



AERIAL CABLE CONNECTION DETAIL
N.T.S.

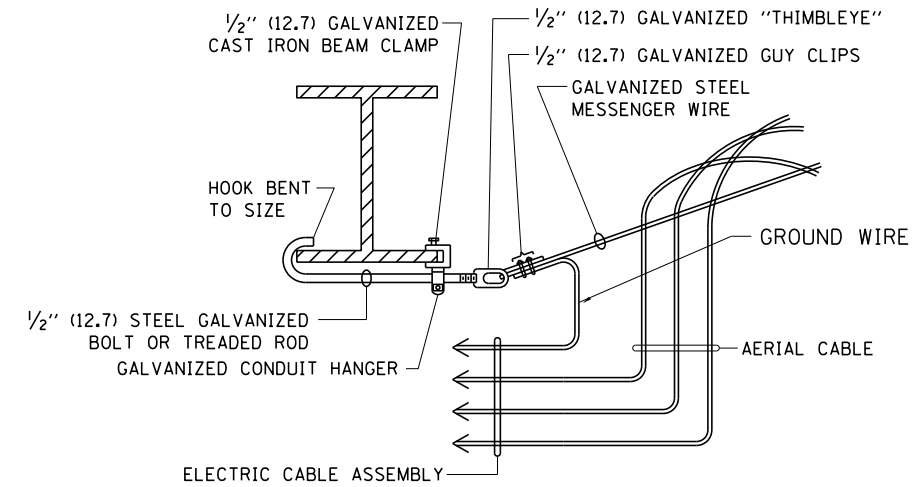

AERIAL CABLE ATTACHED TO STRUCTURE
NOT TO SCALE

NOTES:

1. ALL DIMENSIONS IN INCHES (MILLIMETERS) UNLESS OTHERWISE INDICATED.
2. SEE PROPOSED LIGHTING PLAN FOR CONDUIT, CABLE AND ROUTING.
3. THE CONTRACTOR SHALL PROVIDE INTERMEDIATE SUPPORTS TO MAINTAIN MINIMUM CLEARANCES. REFER TO AERIAL AERIAL CABLE ATTACHED TO STRUCTURE DETAIL.
4. COST OF SPLICES AND MOUNTING HARDWARE SHALL BE INCLUDED IN THE UNIT PRICE FOR AERIAL CABLE.

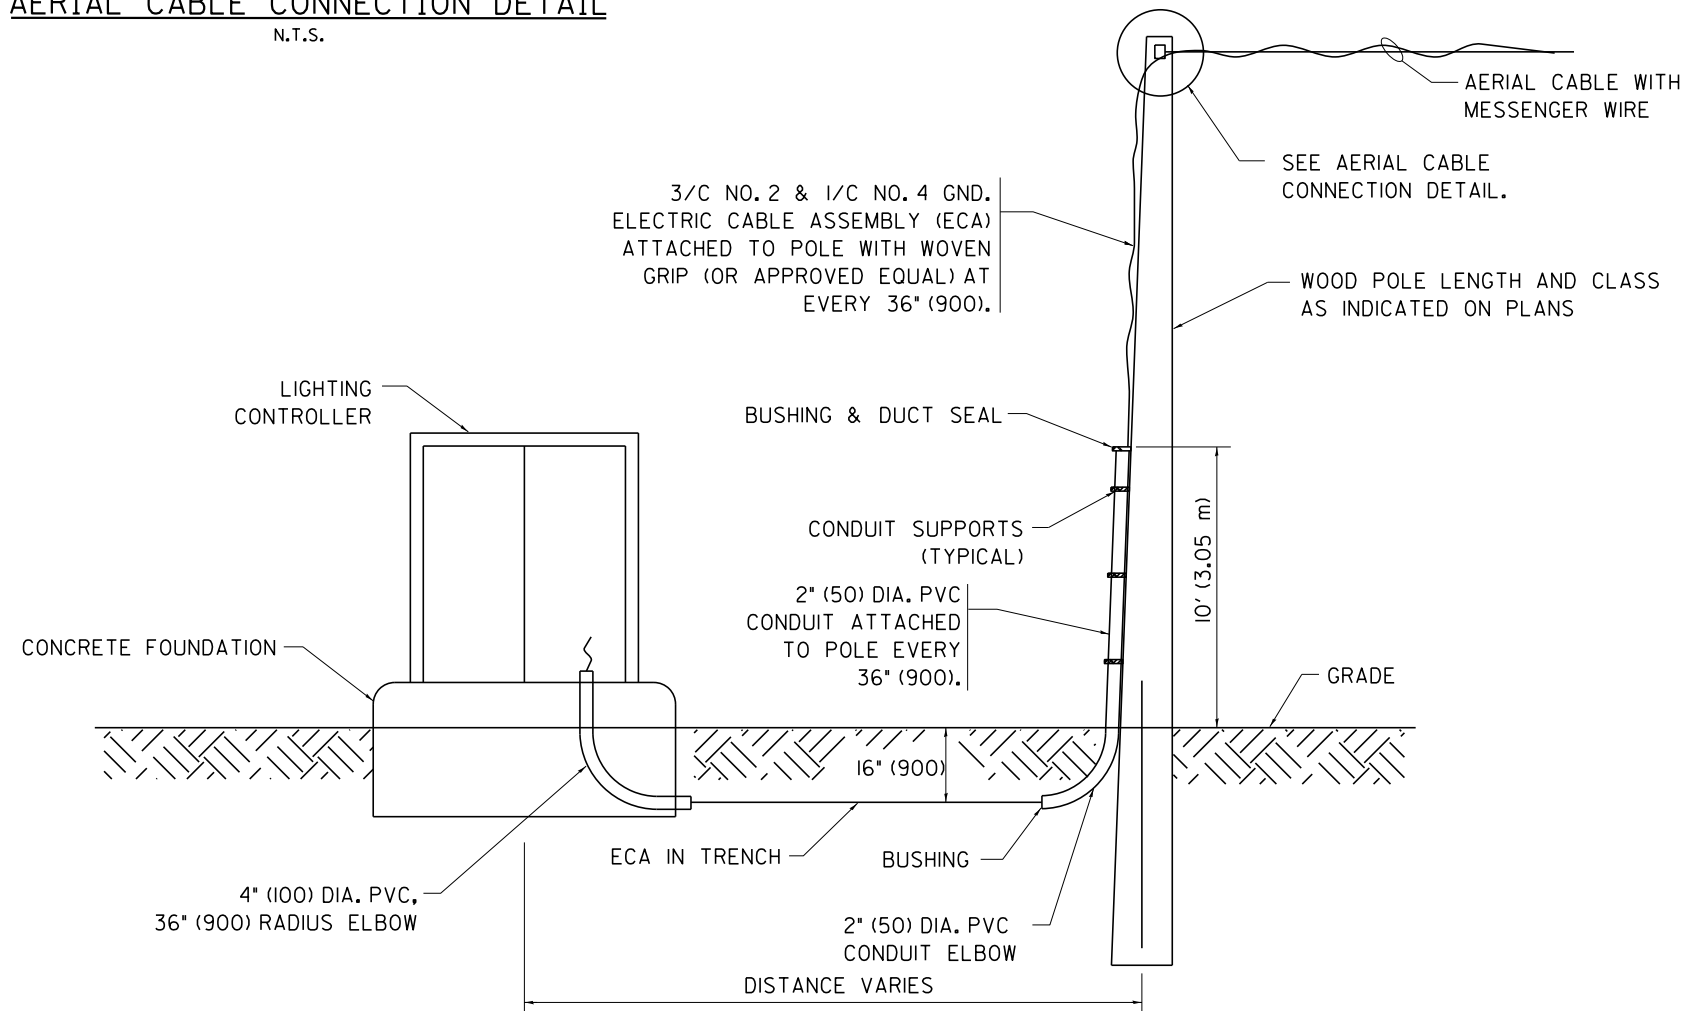

WOOD POLE TO LIGHTING CONTROLLER WIRING CONNECTION DETAIL
N.T.S.

| | | | |
|--|----------------------|------------|--------------------|
| FILE NAME = J:\13003\DN\CADD Sheets\11571-sh-1ght-08.dgn | USER NAME = mgarvido | DESIGNED - | REVISED - 08-08-03 |
| PLOT SCALE = 100.000000:1.000000 | CHECKED - | DRAWN - | REVISED - |
| PLOT DATE = 24-OCT-2013 13:06 | DATE - | | REVISED - |

**STATE OF ILLINOIS
DEPARTMENT OF TRANSPORTATION**

TEMPORARY AERIAL CABLE INSTALLATION

SCALE: NONE SHEET NO. 1 OF 1 SHEETS STA. TO STA.

| | | | | |
|---|---------|--------|---------------------------|-----------|
| F.A.P. RTE. | SECTION | COUNTY | TOTAL SHEETS | SHEET NO. |
| 307 | 131B-BR | DUPAGE | 111 | 43 |
| BE-801 | | | CONTRACT NO. 60V24 | |
| FED. ROAD DIST. NO. 1 ILLINOIS FED. AID PROJECT | | | | |