



NOTE:
INSTALL CLEANOUTS AT EACH CHANGE OF DIRECTION
AND AT MAX. 50' INTERVALS.

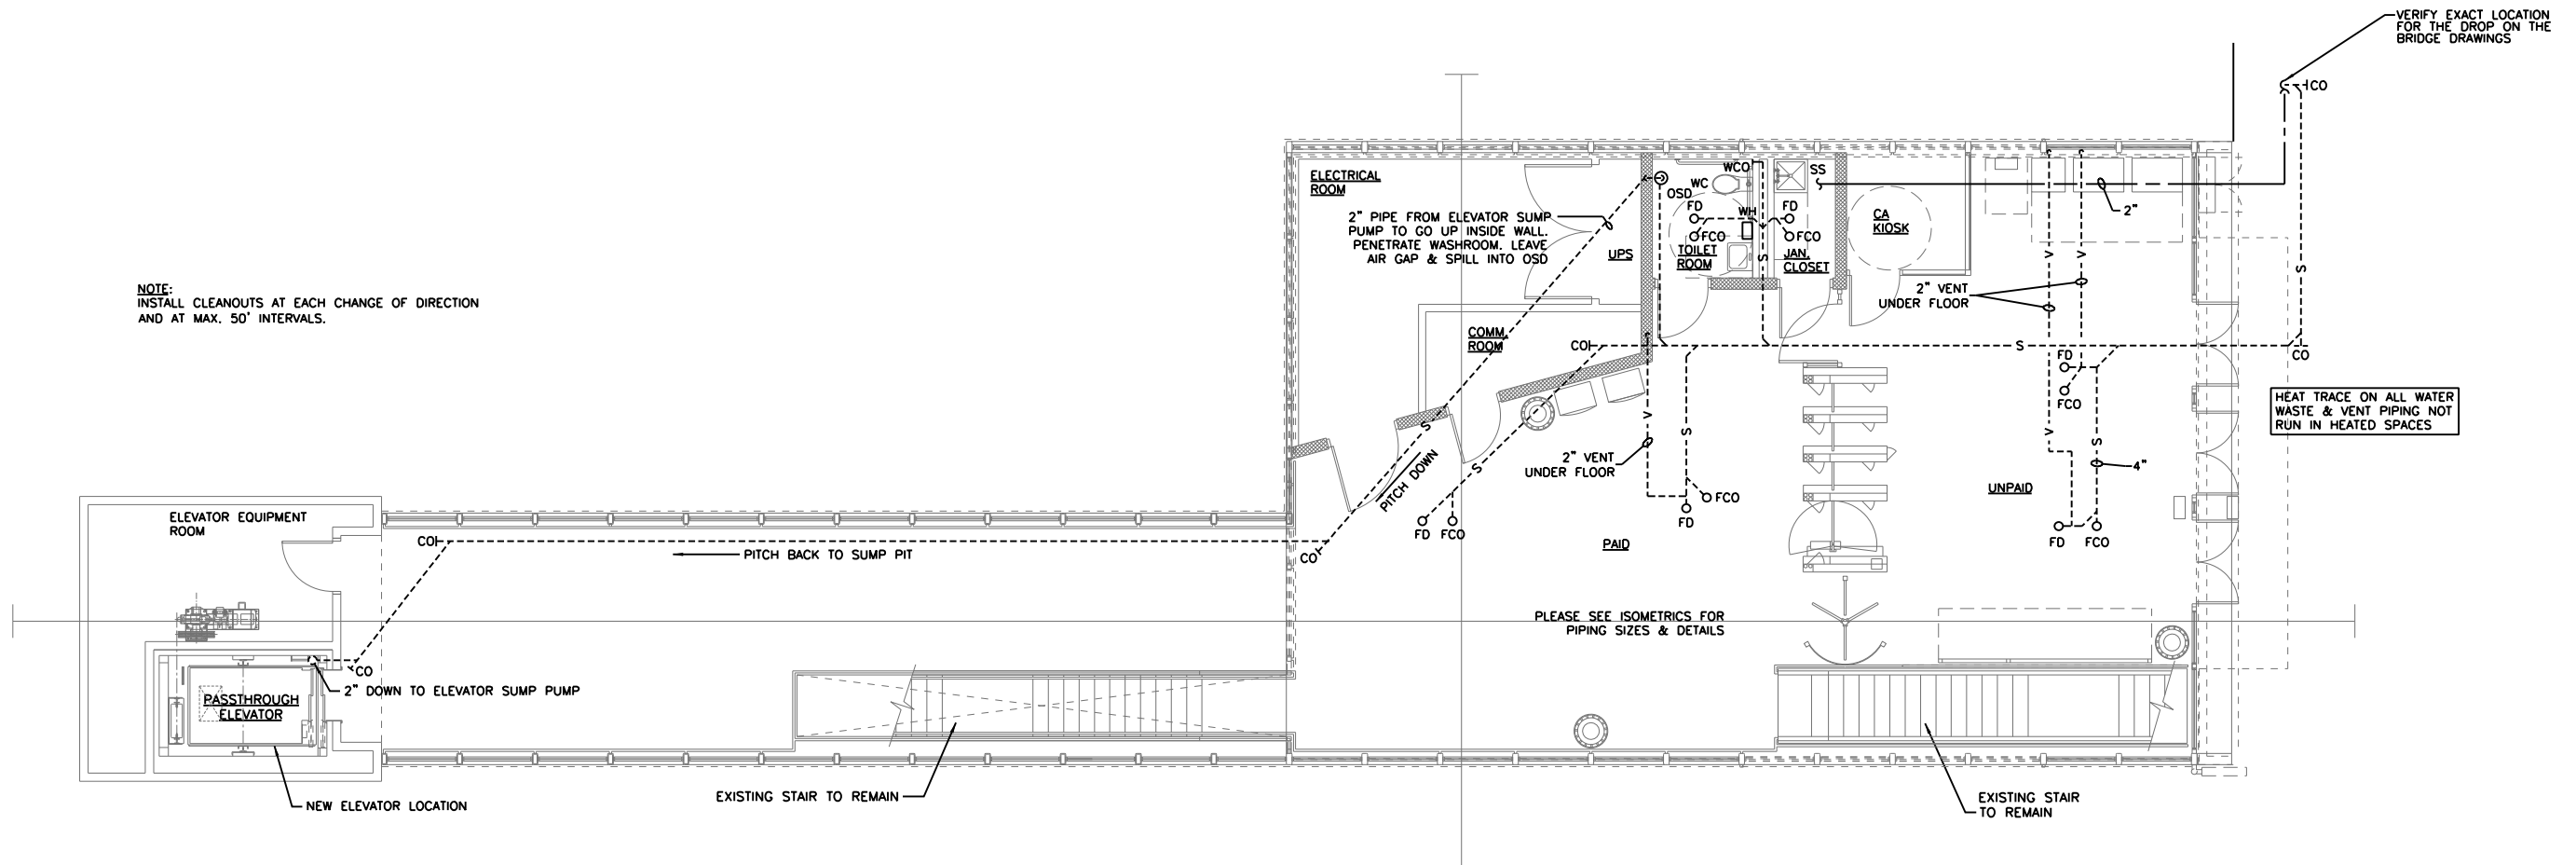

1 STATION HOUSE PLUMBING FLOOR PLAN
SCALE: 3/16" = 1'-0"

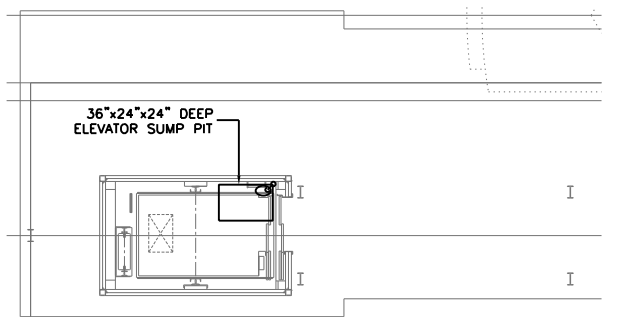

2 PLATFORM PLUMBING PLAN
SCALE: 3/16" = 1'-0"

**THIS IS A BUY USA (AMERICAN) PROJECT,
ALL EQUIPMENT TO BE MANUFACTURED IN THE USA**

PRELIMINARY NOT FOR CONSTRUCTION

AAA ENGINEERING
WBE/DBE CERTIFIED
3940 West Touhy Avenue, Suite 210, Niles, IL 60714
Phone: 847-647-9999 • Fax: 847-647-4719

TranSystems

USER NAME = habit	DESIGNED -	REVISED
	CHECKED -	REVISED
PLOT SCALE = 10:8 1/4" / in.	DRAWN -	REVISED
PLOT DATE = 10/28/2013	CHECKED -	REVISED

**STATE OF ILLINOIS
DEPARTMENT OF TRANSPORTATION**

**PEORIA STREET STATION PLUMBING STATION HOUSE
& PARTIAL PLATFORM PLANS**

MUN	SECTION	COUNTY	TOTAL SHEETS	SHEET NO.
2090	2013-011R	COOK	356	265
CONTRACT NO.			60W29	

SHEET NO. 74 OF 117 SHEETS

ILLINOIS FED. AID PROJECT

8:50:40 PM 2/6/2013