



2 PARTIAL STAIRWAY LIGHTING PLAN
SCALE: 3/16" = 1'-0"

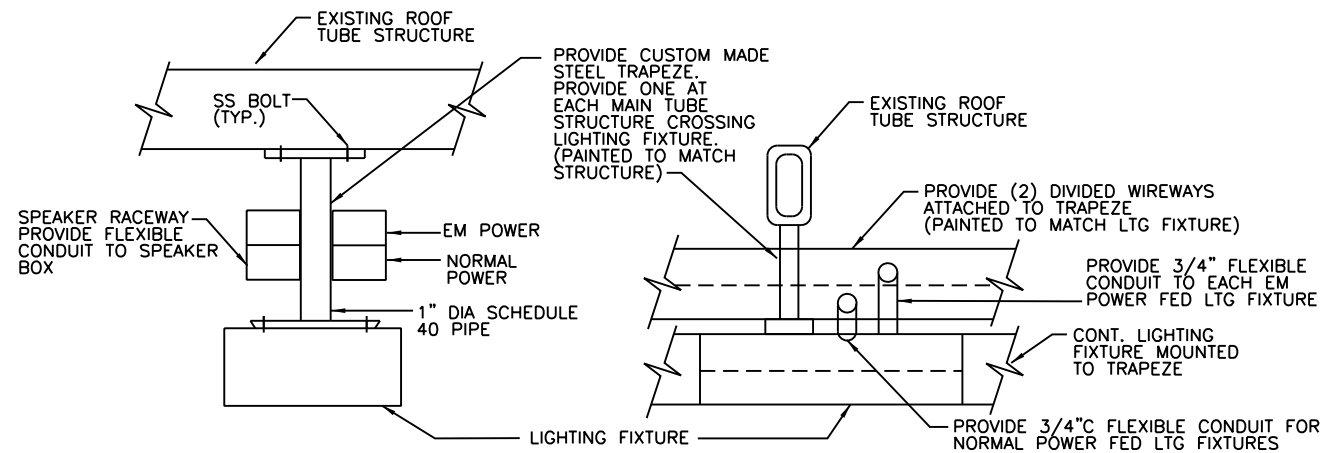

3 LIGHTING FIXTURE MOUNTING DETAIL
SCALE: NTS

NOTES:

1. DASHED LINES REPRESENT SS METAL FILLER BETWEEN LIGHTING FIXTURES. FILLER TO HAVE SAME WIDTH AND HEIGHT AS ADJACENT LIGHT FIXTURE TO FORM A CONTINUOUS ROW OF LIGHTING.
2. PROVIDE PERFORATIONS FOR PA SYSTEM SPEAKER AND PRE-DRILL HOLES FOR MOUNTING SPEAKER BOX. COORDINATE WORK WITH SPEAKER MANUFACTURER.
3. SEE SHEET 278 FOR LIGHT FIXTURE SCHEDULE.
4. CONTINUOUS DIVIDED WIREWAY MOUNTED ON EXISTING STRUCTURAL TUBING ABOVE POURWAY.
5. ROUTE ALL LIGHTING, SPEAKER, CCTV AND SIGN CONDUIT AND CABLE HOME RUNS CONCEALED ABOVE CEILING. REFER TO ARCHITECTURAL PLANS FOR CEILING LAYOUT.

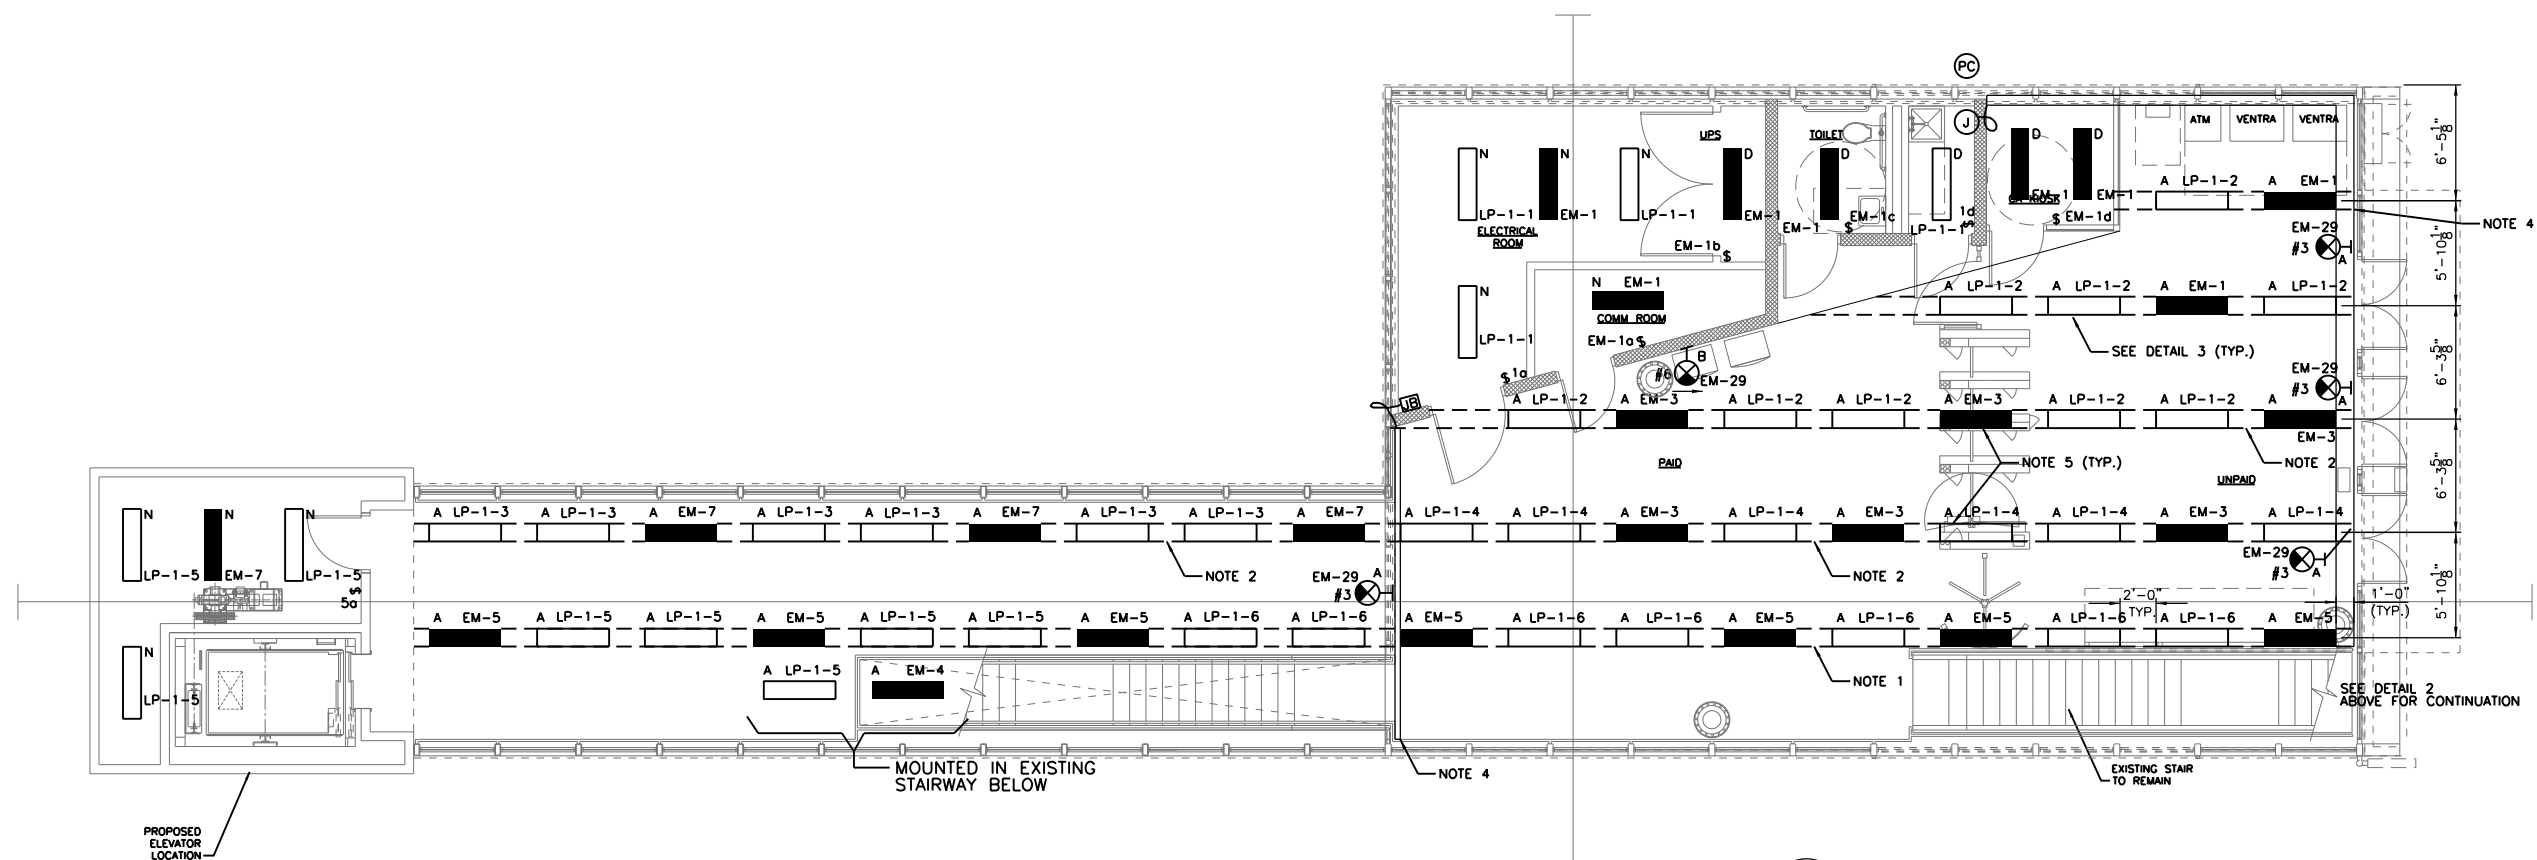

1 ELECTRICAL LIGHTING PLAN
SCALE: 3/16" = 1'-0"

AAA ENGINEERING
W8/D8E CERTIFIED
3940 West Touhy Avenue, Suite 210, Niles, IL 60714
Phone: 847-647-9999 • Fax: 847-647-4719

TranSystems

USER NAME = habit	DESIGNED -	REVISED
	CHECKED -	REVISED
PLOT SCALE = 10:8 '1' / in.	DRAWN -	REVISED
PLOT DATE = 10/28/2013	CHECKED -	REVISED

**STATE OF ILLINOIS
DEPARTMENT OF TRANSPORTATION**

**PEORIA STREET STATION
ELECTRICAL STATION HOUSE LIGHTING PLAN**

SHEET NO. 82 OF 117 SHEETS

PRELIMINARY NOT FOR CONSTRUCTION

MUN	SECTION	COUNTY	TOTAL SHEETS	SHEET NO.
2090	2013-011R	COOK	356	273
CONTRACT NO. 60W29			ILLINOIS FED. AID PROJECT	

9/19/14 PM 273-60W29.dgn