



NOTES:

1. DASHED LINES REPRESENT SS METAL FILLER BETWEEN LIGHTING FIXTURES. FILLER TO HAVE SAME WIDTH AND HEIGHT AS ADJACENT LIGHT FIXTURE TO FORM A CONTINUOUS ROW OF LIGHTING.
2. PROVIDE PERFORATIONS FOR PA SYSTEM SPEAKER AND PRE-DRILL HOLES FOR MOUNTING SPEAKER BOX. COORDINATE WORK WITH SPEAKER MANUFACTURER.
3. SEE SHEET 278 FOR LIGHT FIXTURE SCHEDULE.
4. CONTINUOUS DIVIDED WIREWAY MOUNTED ON EXISTING STRUCTURAL TUBING ABOVE POURWAY.
5. ROUTE ALL LIGHTING, SPEAKER, CCTV AND SIGN CONDUIT AND CABLE HOME RUNS CONCEALED ABOVE CEILING. REFER TO ARCHITECTURAL PLANS FOR CEILING LAYOUT.

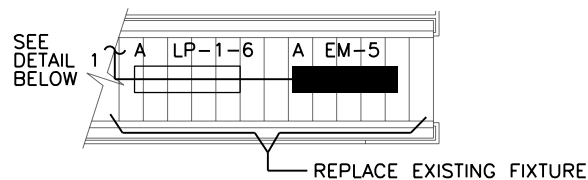

2 PARTIAL STAIRWAY LIGHTING PLAN
SCALE: 3/16" = 1'-0"

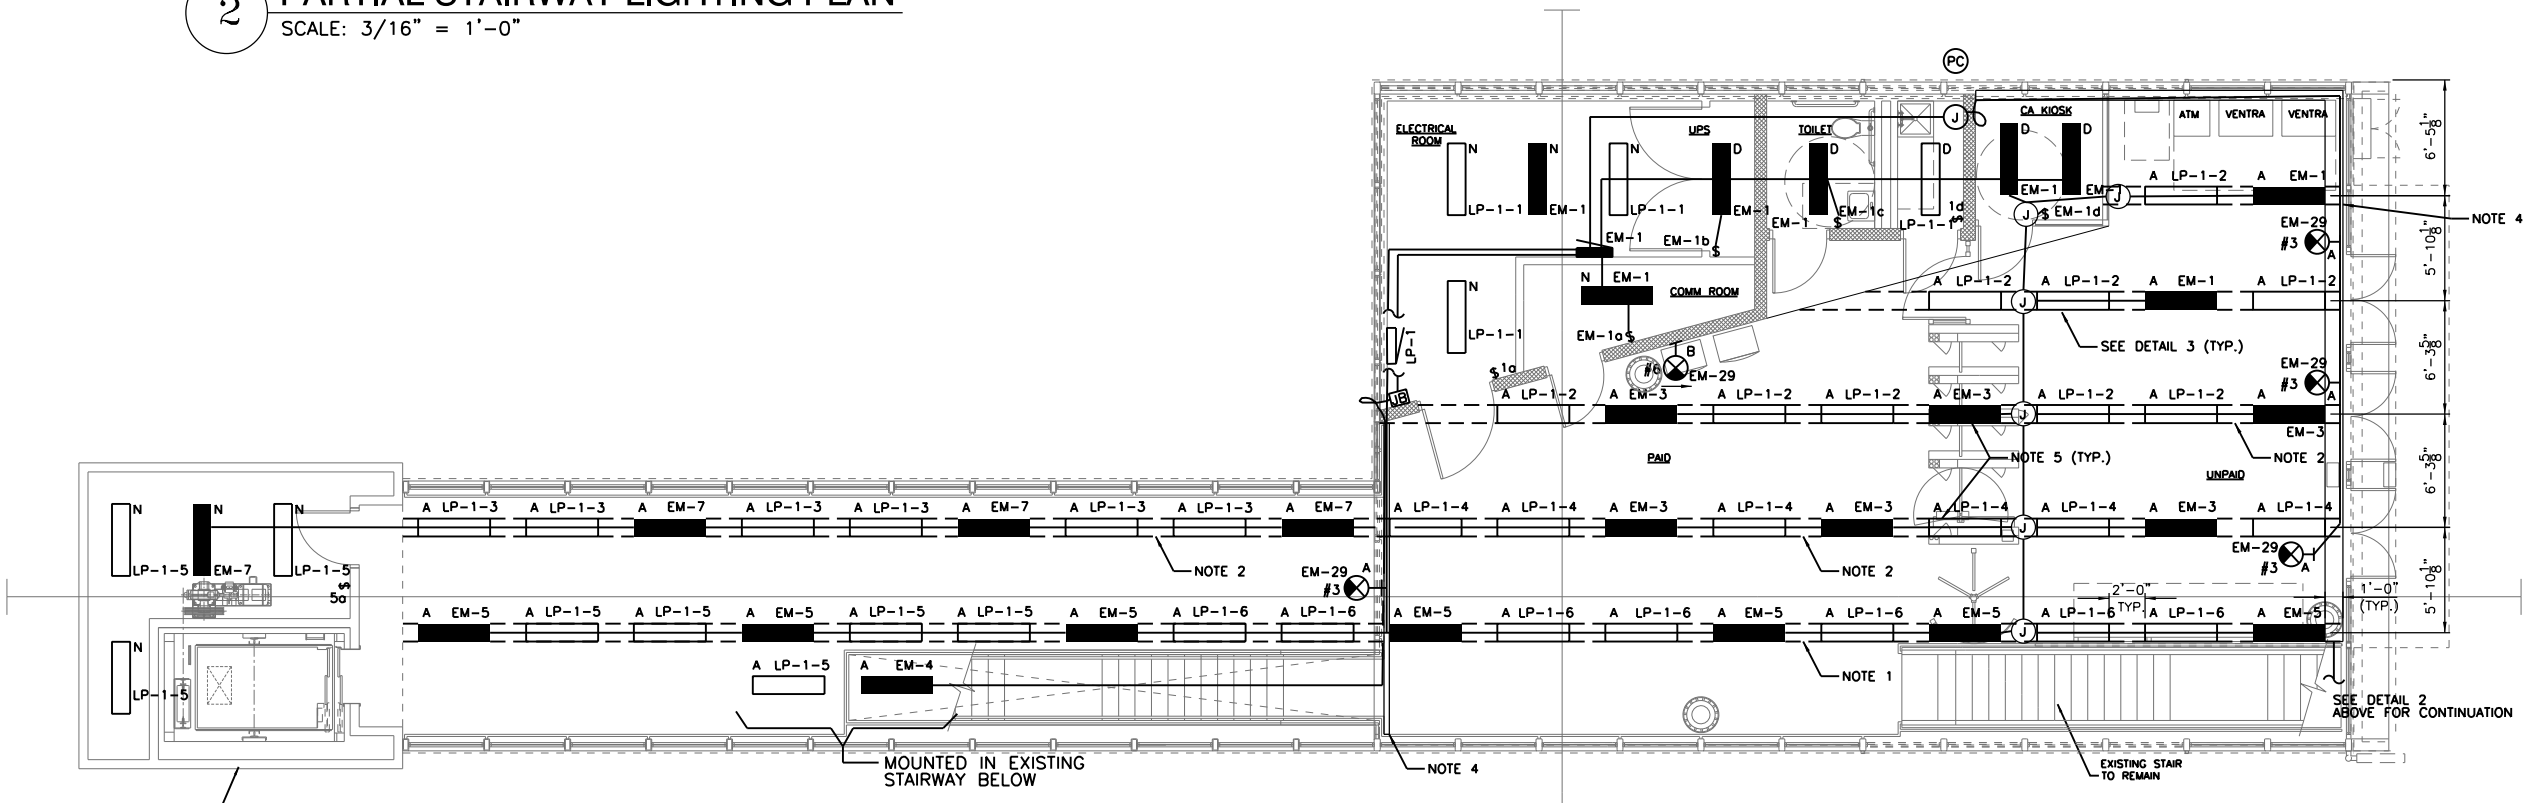

1 ELECTRICAL LIGHTING PLAN
SCALE: 3/16" = 1'-0"

AAA ENGINEERING
WBE/DBE CERTIFIED
3940 West Touhy Avenue, Suite 210, Niles, IL 60714
Phone: 847-647-9999 • Fax: 847-647-4719

TranSystems

USER NAME = habit	DESIGNED -	REVISED
	CHECKED -	REVISED
PLOT SCALE = 10:8 " / in.	DRAWN -	REVISED
PLOT DATE = 10/28/2013	CHECKED -	REVISED

STATE OF ILLINOIS
DEPARTMENT OF TRANSPORTATION

PEORIA STREET STATION
ELECTRICAL STATION HOUSE EMERGENCY PLAN

SHEET NO. 83 OF 117 SHEETS

PRELIMINARY NOT FOR CONSTRUCTION

MUN	SECTION	COUNTY	TOTAL SHEETS	SHEET NO.
2090	2013-011R	COOK	356	274
CONTRACT NO. 60W29			ILLINOIS FED. AID PROJECT	

9:41:01 PM 274-60W29.dgn