


F.A.P. RTE.	SECTION	COUNTY	TOTAL SHEETS	SHEET NO.
668	28R-1	SANGAMON	354	112
STA. 5+400 TO STA. 5+575				
FED. ROAD DIST. NO.		ILLINOIS	FED. AID PROJECT	
CONTRACT NO. 72501				

BY	DATE

BY	DATE

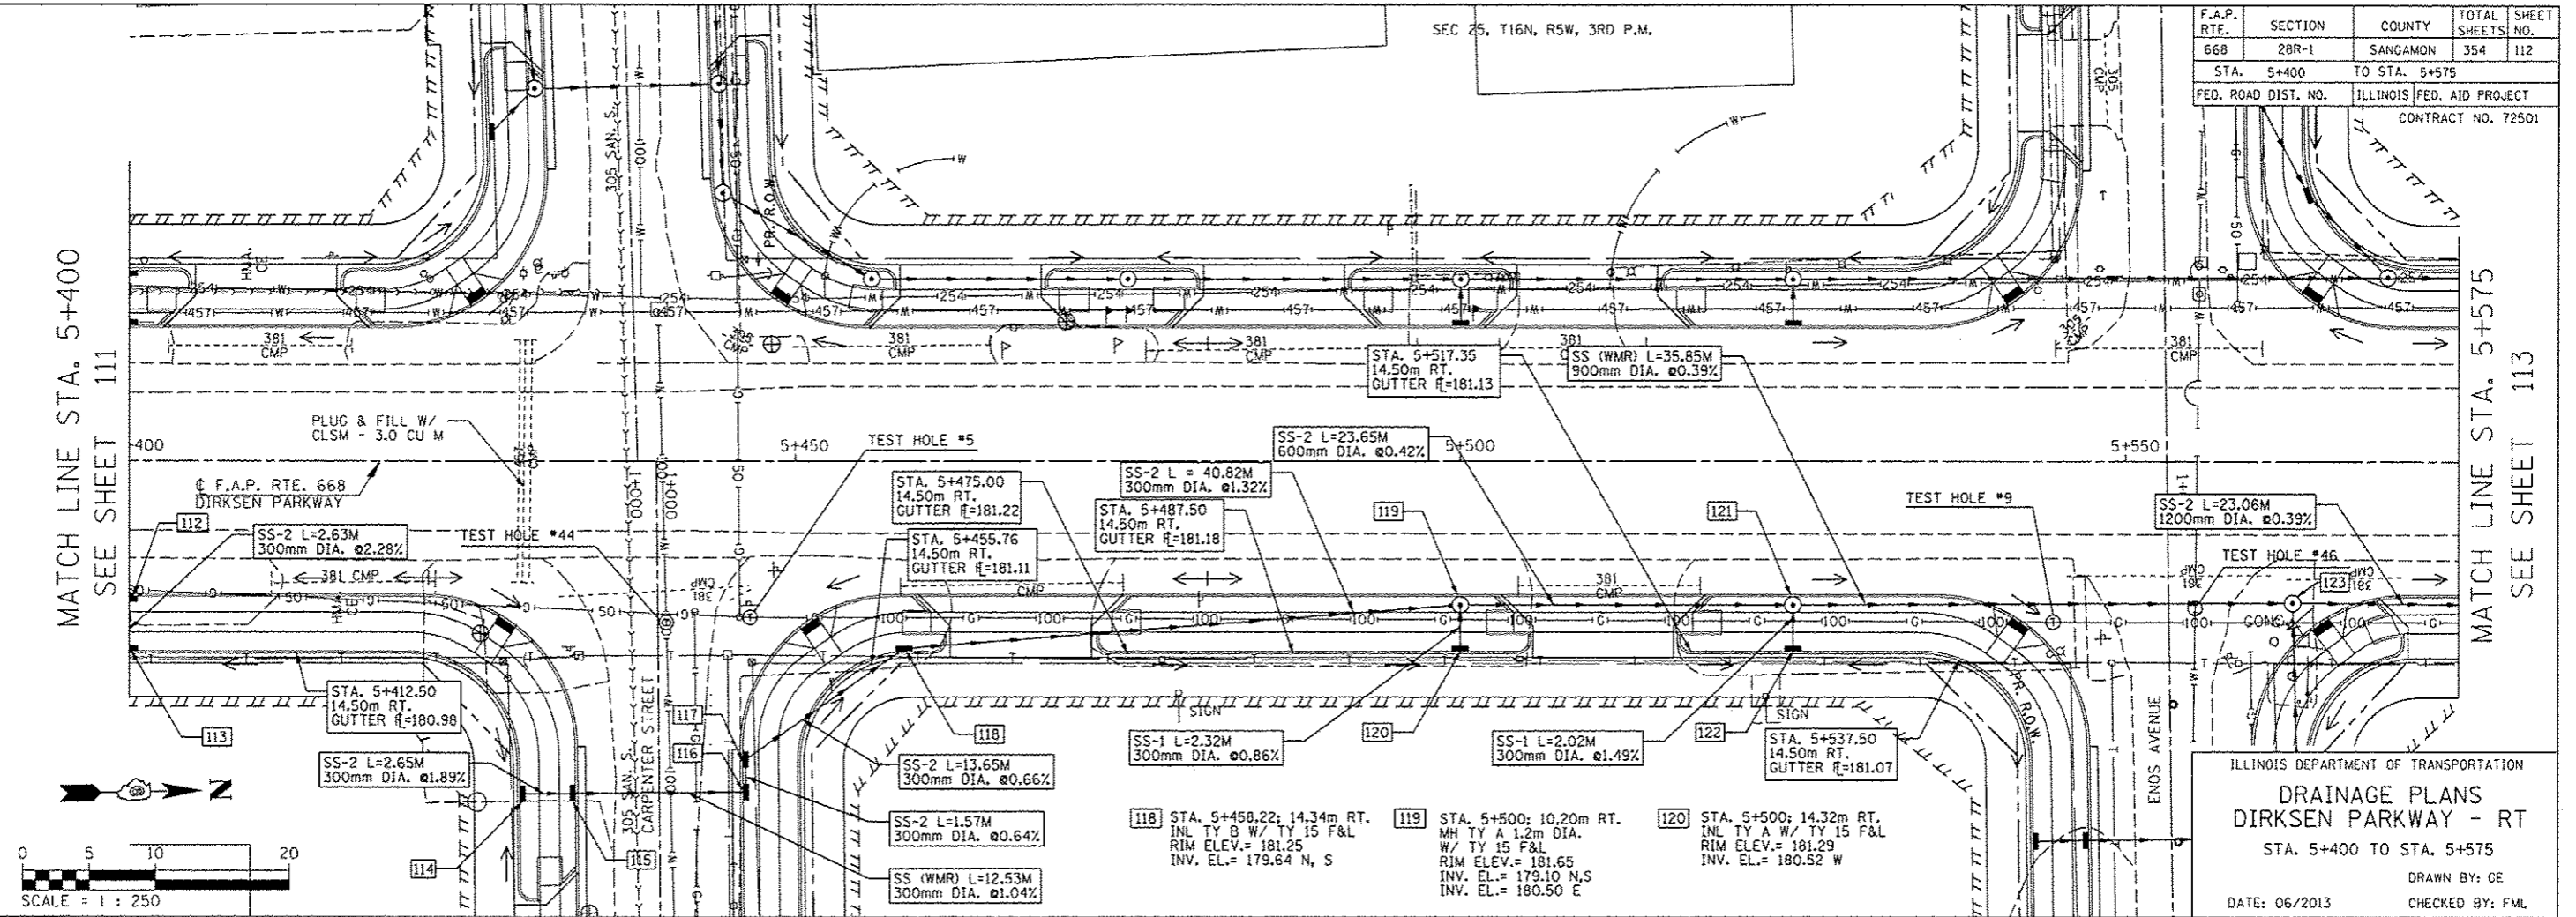

ILLINOIS DEPARTMENT OF TRANSPORTATION
DRAINAGE PLANS
 DIRKSEN PARKWAY - RT
 STA. 5+400 TO STA. 5+575
 DRAWN BY: CE
 DATE: 06/2013
 CHECKED BY: FML

