
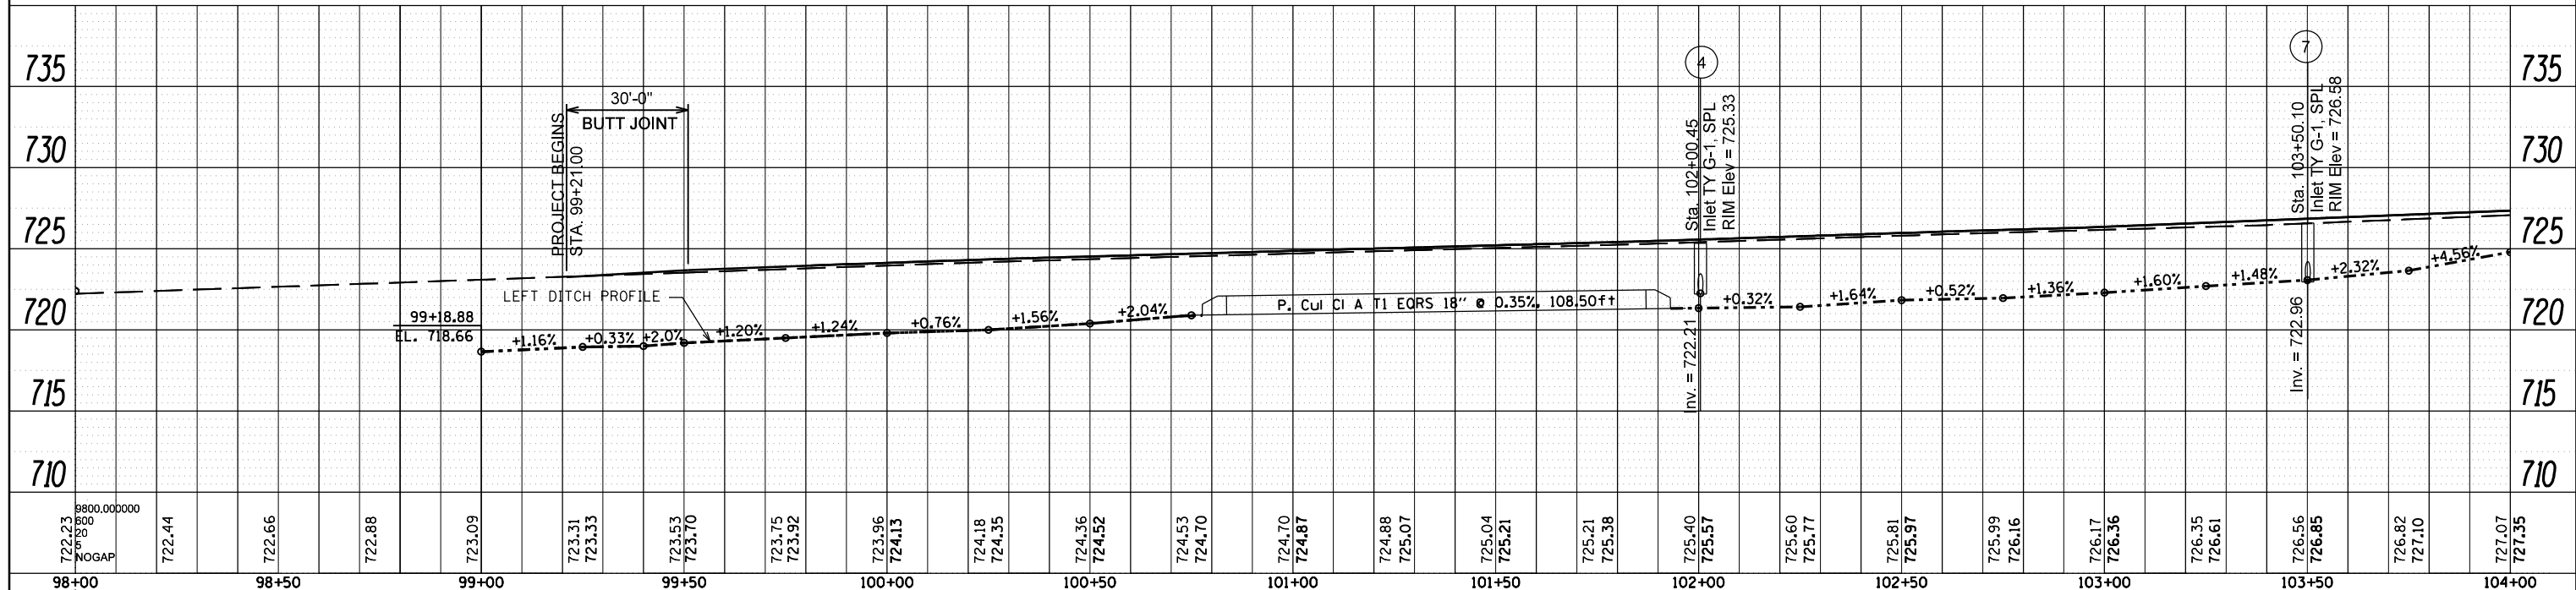


PLAN	SURVEYED	DATE
	PLOTTED	
	ALIGNED	
	CHECKED	
	FILE NAME	
	NO.	

PROFILE	SURVEYED	DATE
	PLOTTED	
	GRADES CHECKED	
	STRUCTURE NOTATIONS CHECKED	
	NO.	

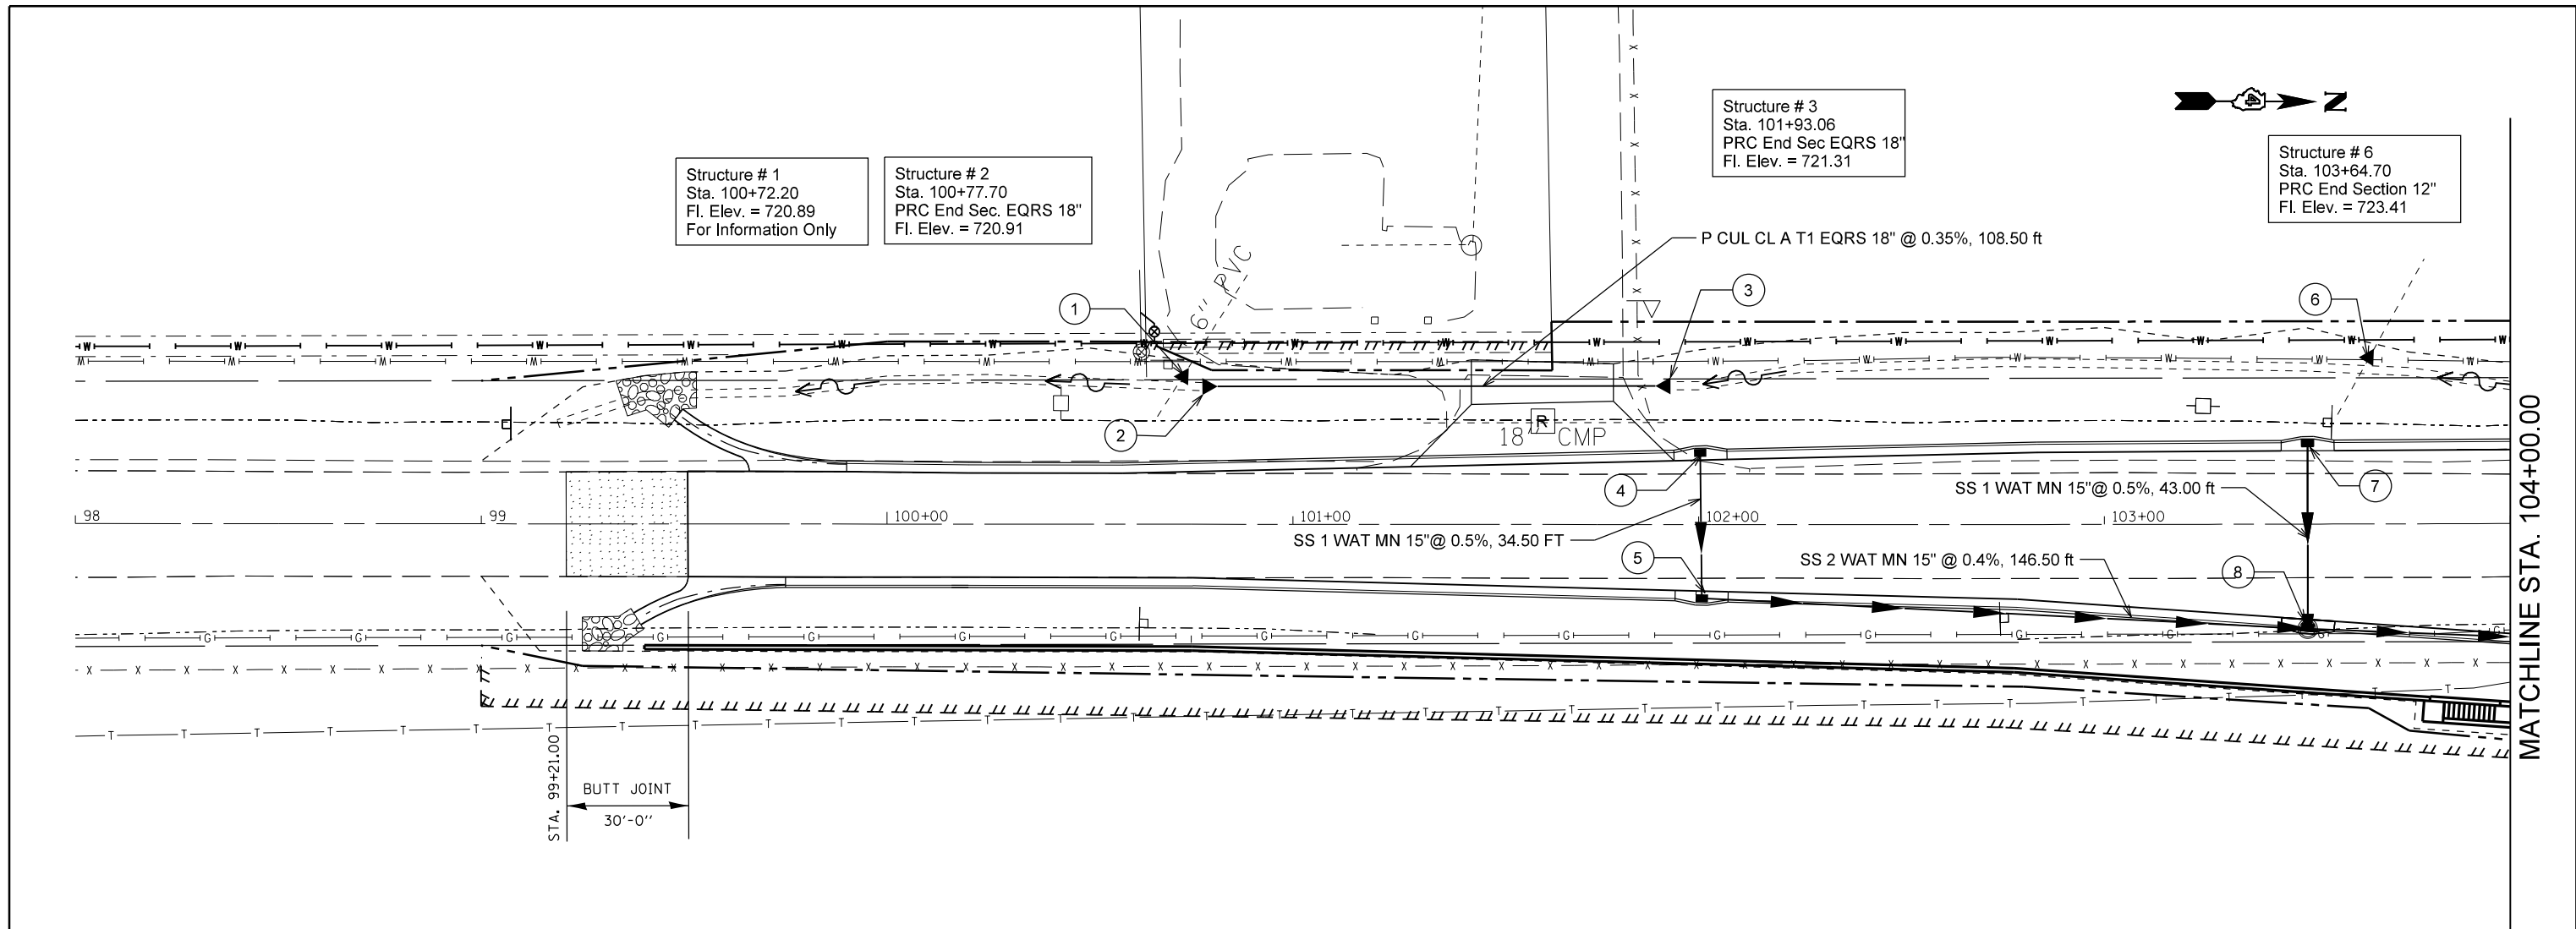

FILE NAME	USER NAME = crespole	DESIGNED -	REVISED -	STATE OF ILLINOIS DEPARTMENT OF TRANSPORTATION	IL RTE 91 DRAINAGE PLANS LT SIDE				F.A.S. RTE.	SECTION	COUNTY	TOTAL SHEETS	SHEET NO.
c:\pwork\pwork\crespole\ad0330150\04887	p2-SHT-DRAIN-LT-rev.DGN	DRAWN -	REVISED -		1380	7W-1,RS-3	Peoria	617	227				
PLOT SCALE = 40.0000' / in.	CHECKED -	REVISED -	SCALE:		SHEET	OF	SHEETS	STA.	TO	STA.	CONTRACT NO. 88792		
Default	DATE = 8/16/2013	DATE -	REVISED -		ILLINOIS FED. AID PROJECT								