



PLAN	SURVEYED	BY	DATE
	PLOTTED		
	GRADES CHECKED		
	ALIGNED		
	ADJUSTED		
	FILE NAME		
	NO.		

PROFILE	SURVEYED	BY	DATE
	PLOTTED		
	GRADES CHECKED		
	STRUCTURE		
	NOTATIONS		
	CHKD		
	NO.		

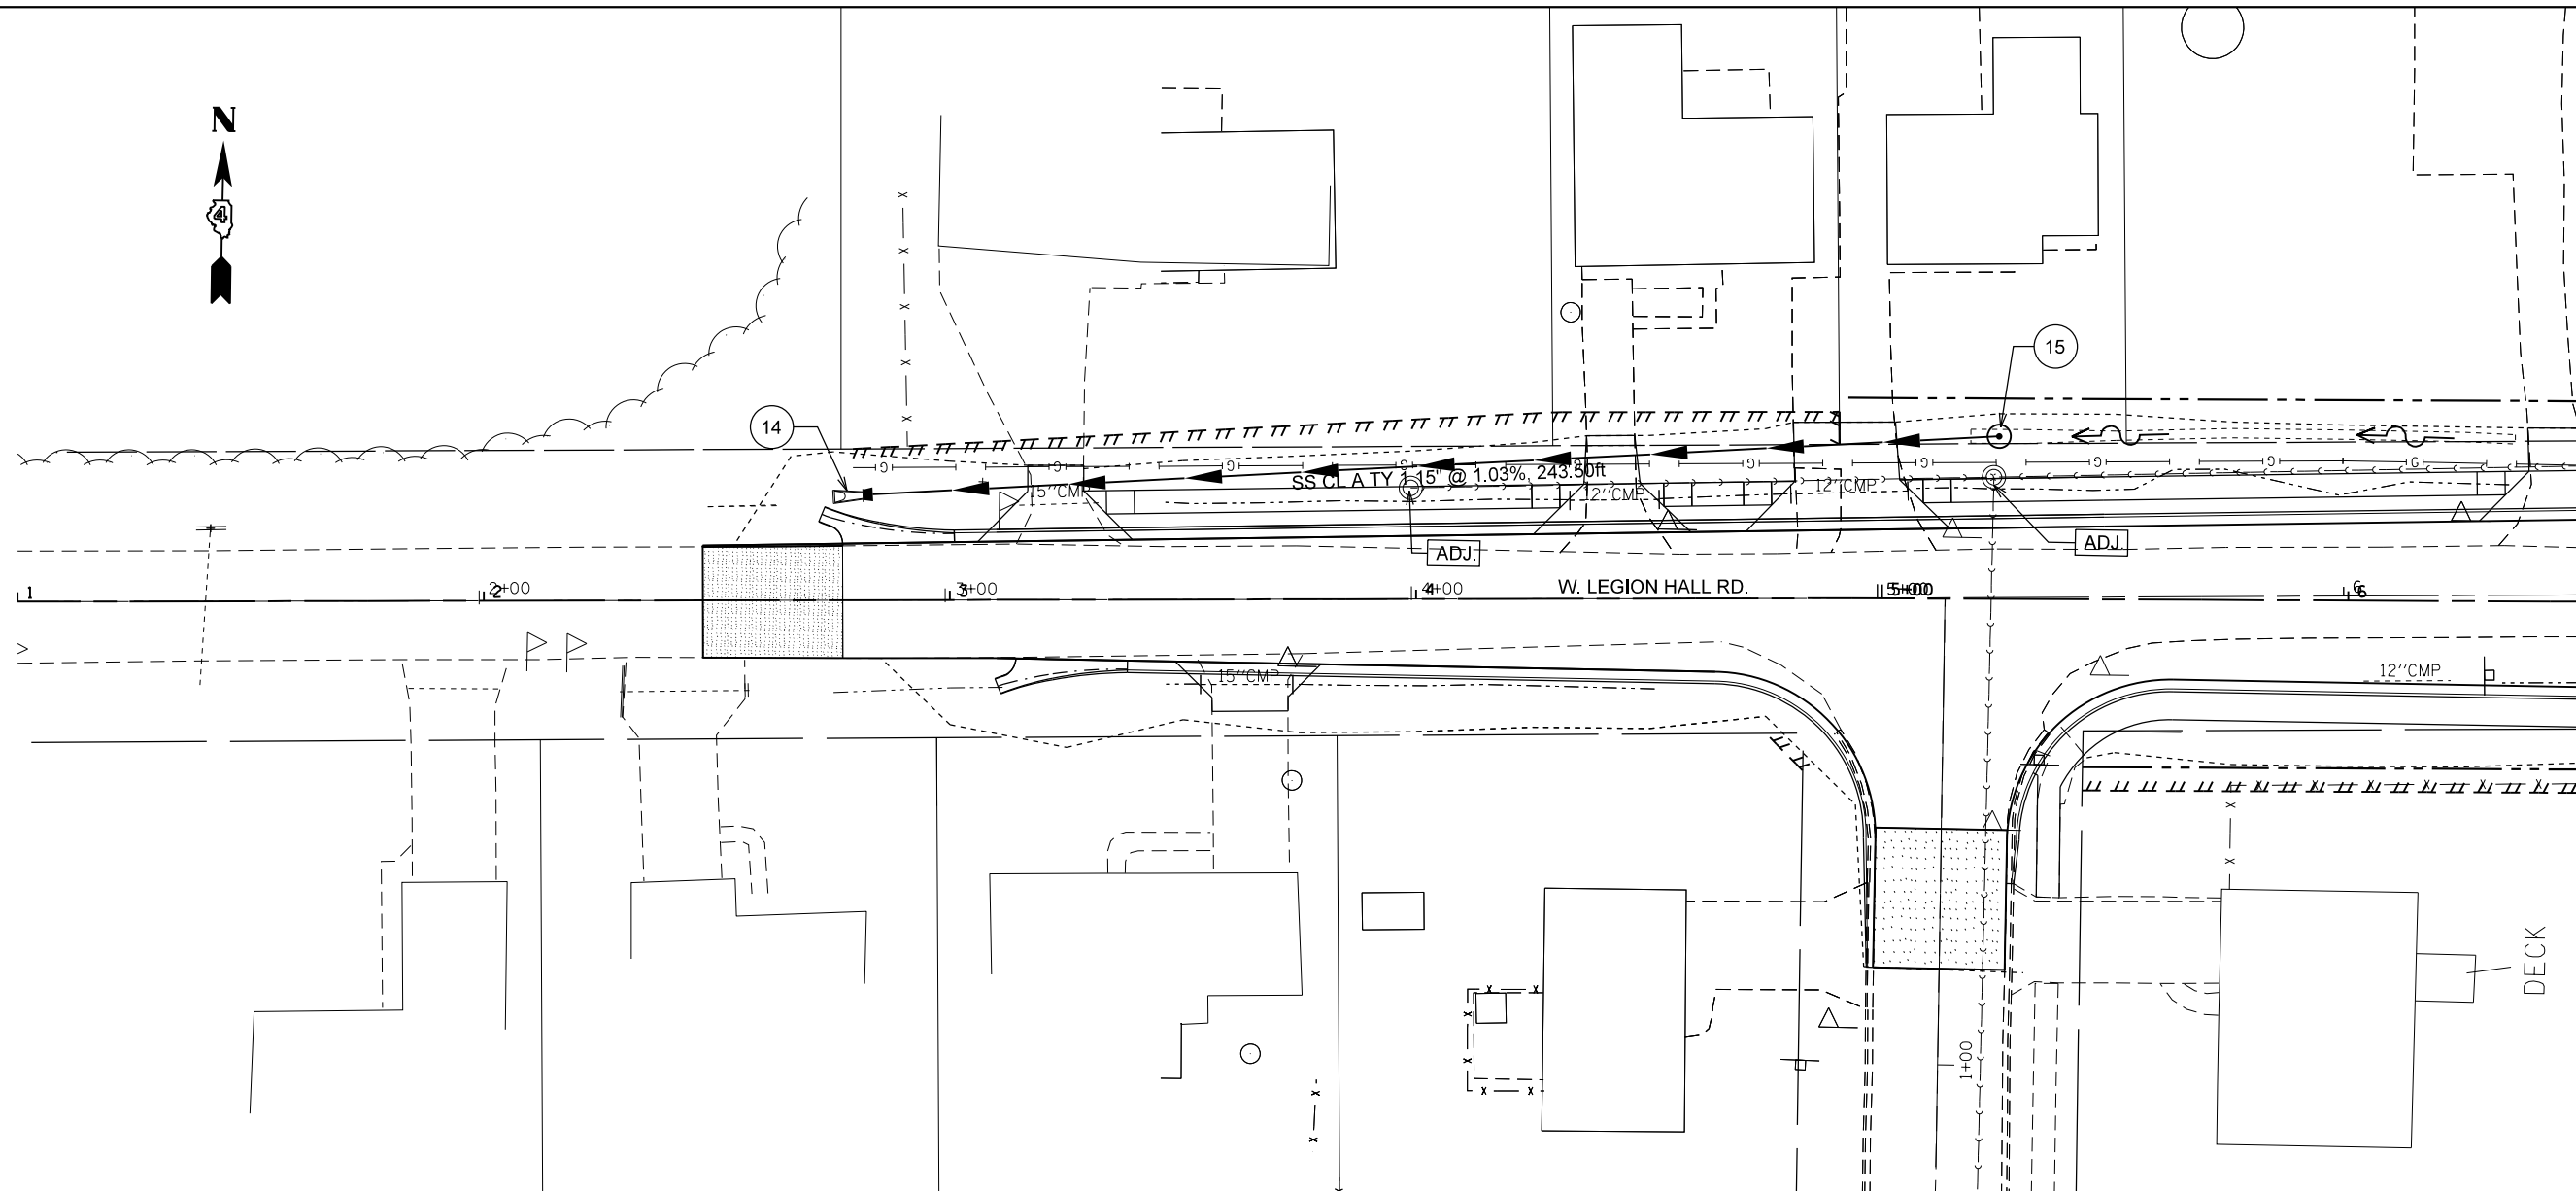

MATCHLINE STA. 6+50.00

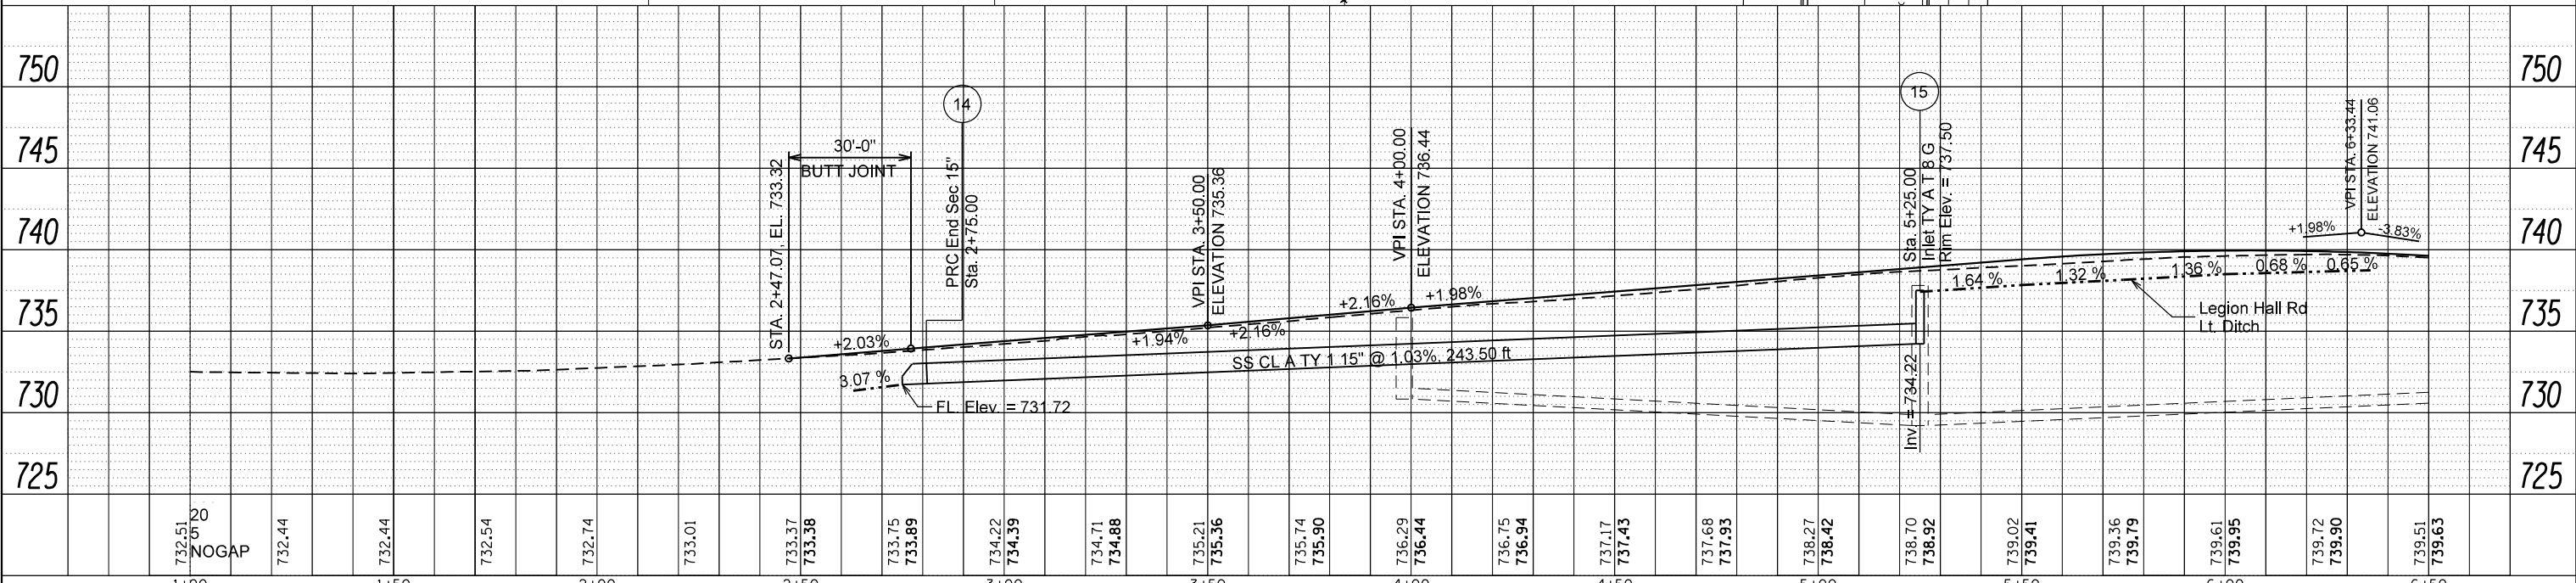

FILE NAME =	USER NAME = crespole	DESIGNED -	REVISED -	STATE OF ILLINOIS DEPARTMENT OF TRANSPORTATION	LEGION HALL ROAD DRAINAGE PLANS LT SIDE	F.A.S. RTE.	SECTION	COUNTY	TOTAL SHEETS	SHEET NO.
c:\pwork\pwork\crespole\ad0330150\04887	12-SHT-LHR-DRAIN-LT-rev.DGN	DRAWN -	REVISED -			1380	7W-1,RS-3	Peoria	617	245
PLOT SCALE = 40.0000' / in.	CHECKED -	REVISED -				CONTRACT NO. 88792				
Default	DATE = 8/14/2013	DATE -	REVISED -			ILLINOIS FED. AID PROJECT				