
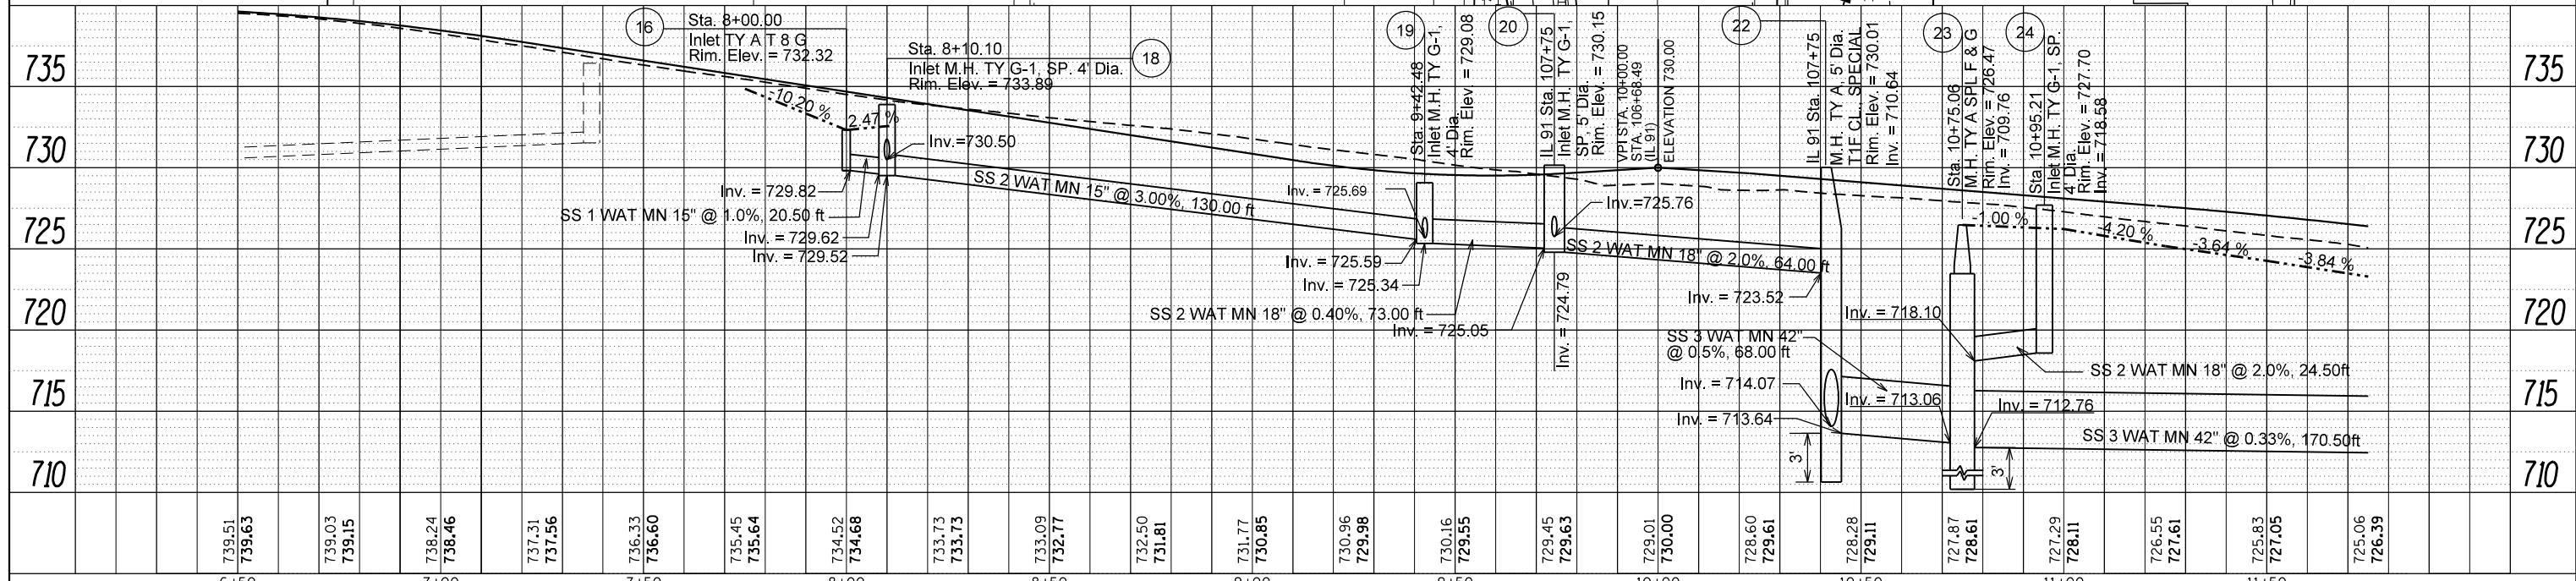


PLAN	SURVEYED	DATE
	PLOTTED	
	ALIGNED	
	CHECKED	
	FILE NAME	
	NO.	

PROFILE	SURVEYED	DATE
	PLOTTED	
	GRADES CHECKED	
	STRUCTURE	
	NOTATIONS	
	CHKD	

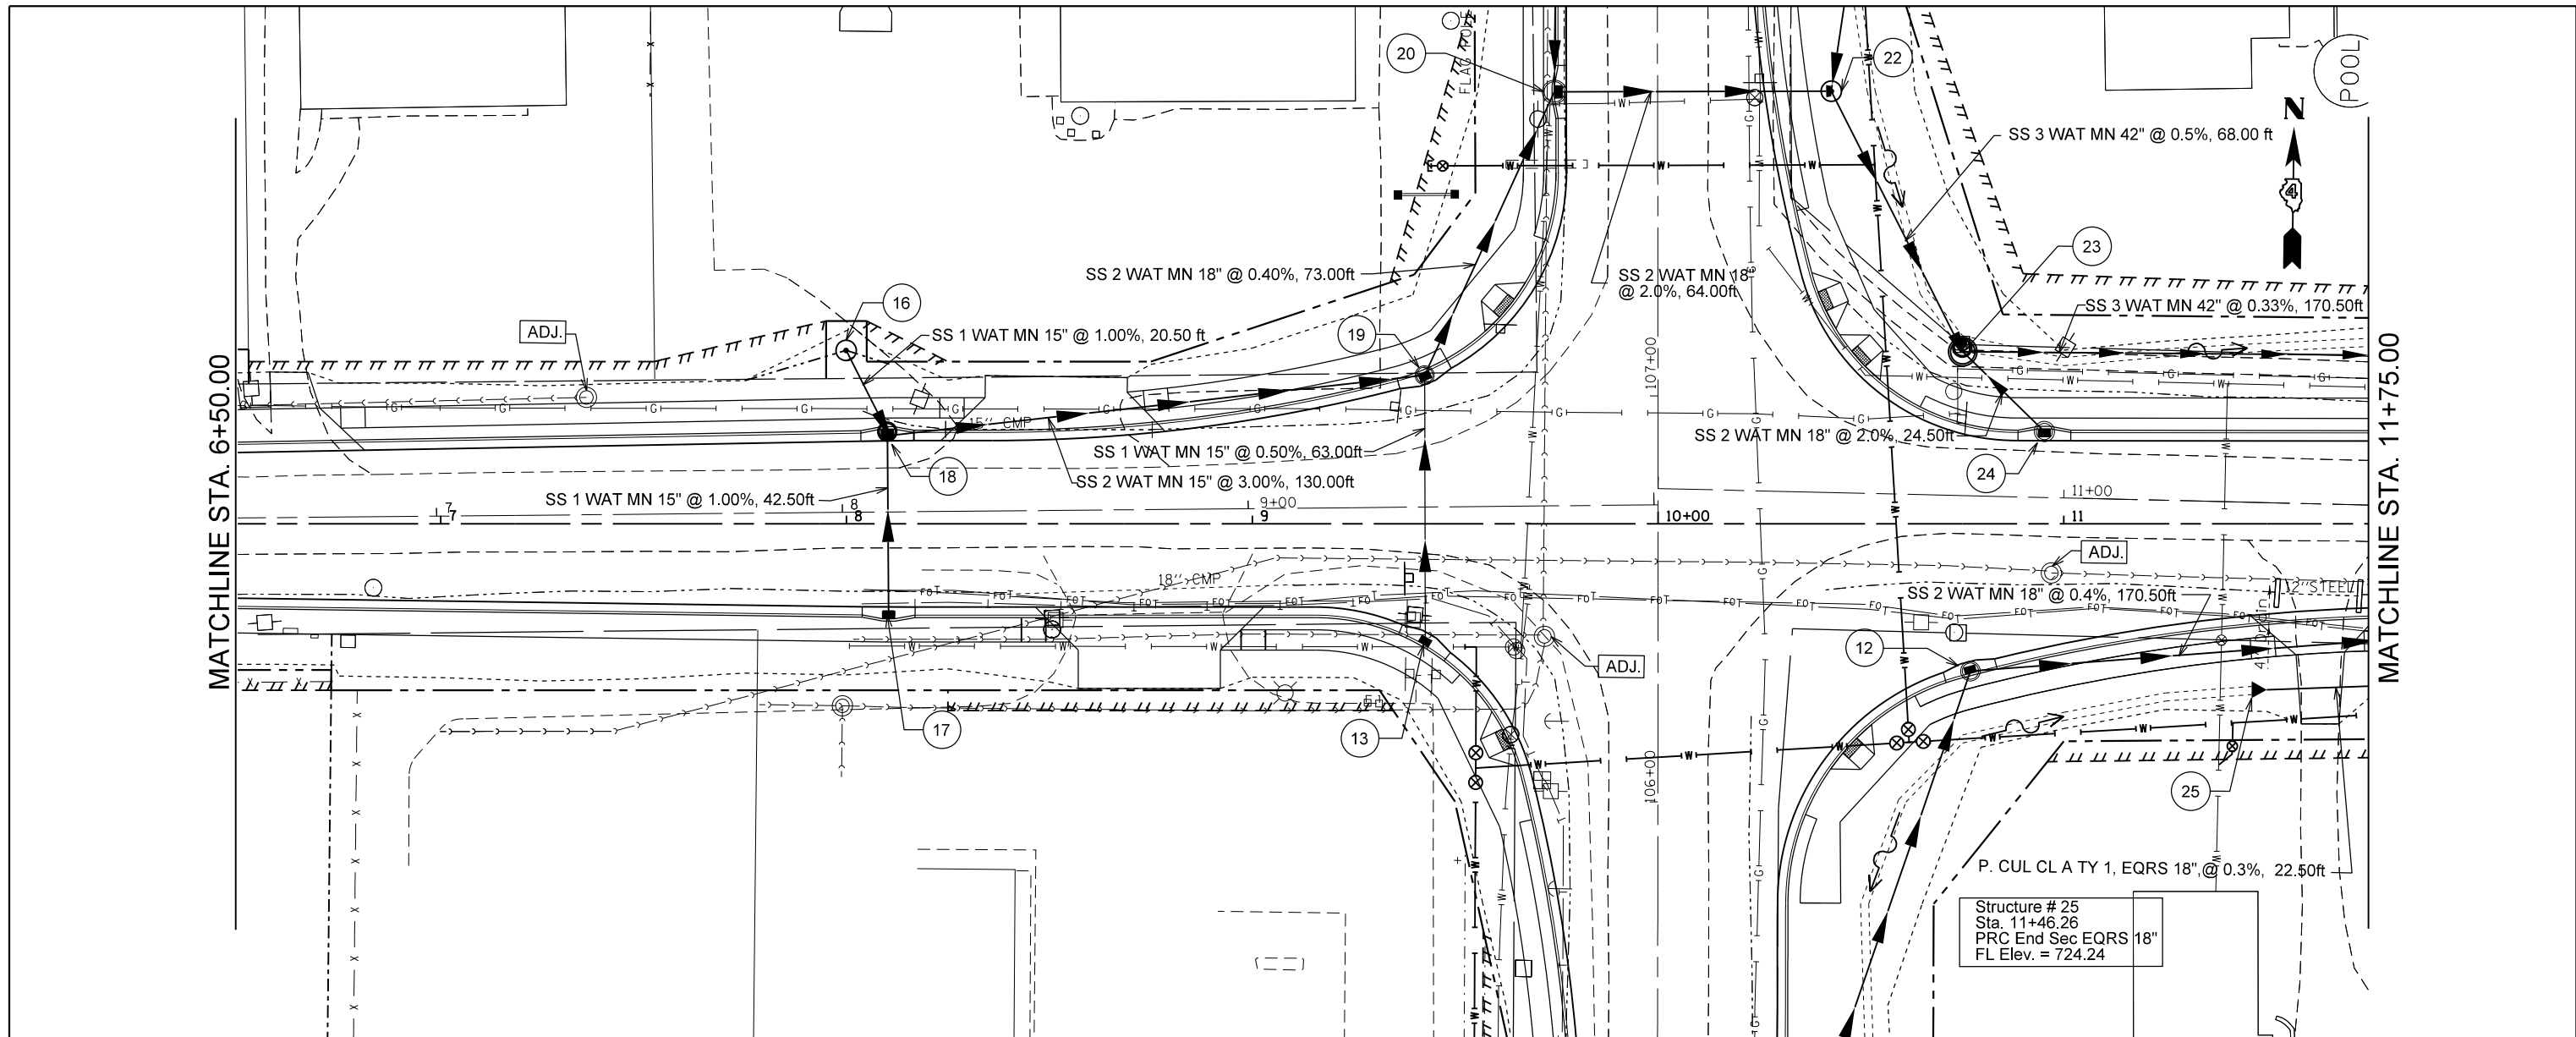

FILE NAME =	USER NAME = crespole	DESIGNED -	REVISED -	<b>STATE OF ILLINOIS DEPARTMENT OF TRANSPORTATION</b>	<b>LEGION HALL ROAD DRAINAGE PLANS LT SIDE</b>	F.A.S. R.T.E. = 1380	SECTION = 7W-1,RS-3	COUNTY = Peoria	TOTAL SHEETS = 617	SHEET NO. = 246		
c:\pwork\pwork\crespole\0330150\04887	22-SHT-LHR-DRAIN-LT-rev.DGN	DRAWN -	REVISED -			SCALE:	SHEET OF SHEETS	STA. TO STA.	CONTRACT NO. 88792			
PLOT SCALE = 40.0000' / in.	CHECKED -	REVISED -	REVISED -			ILLINOIS FED. AID PROJECT						
Default	PLOT DATE = 8/14/2013	DATE -	REVISED -									