
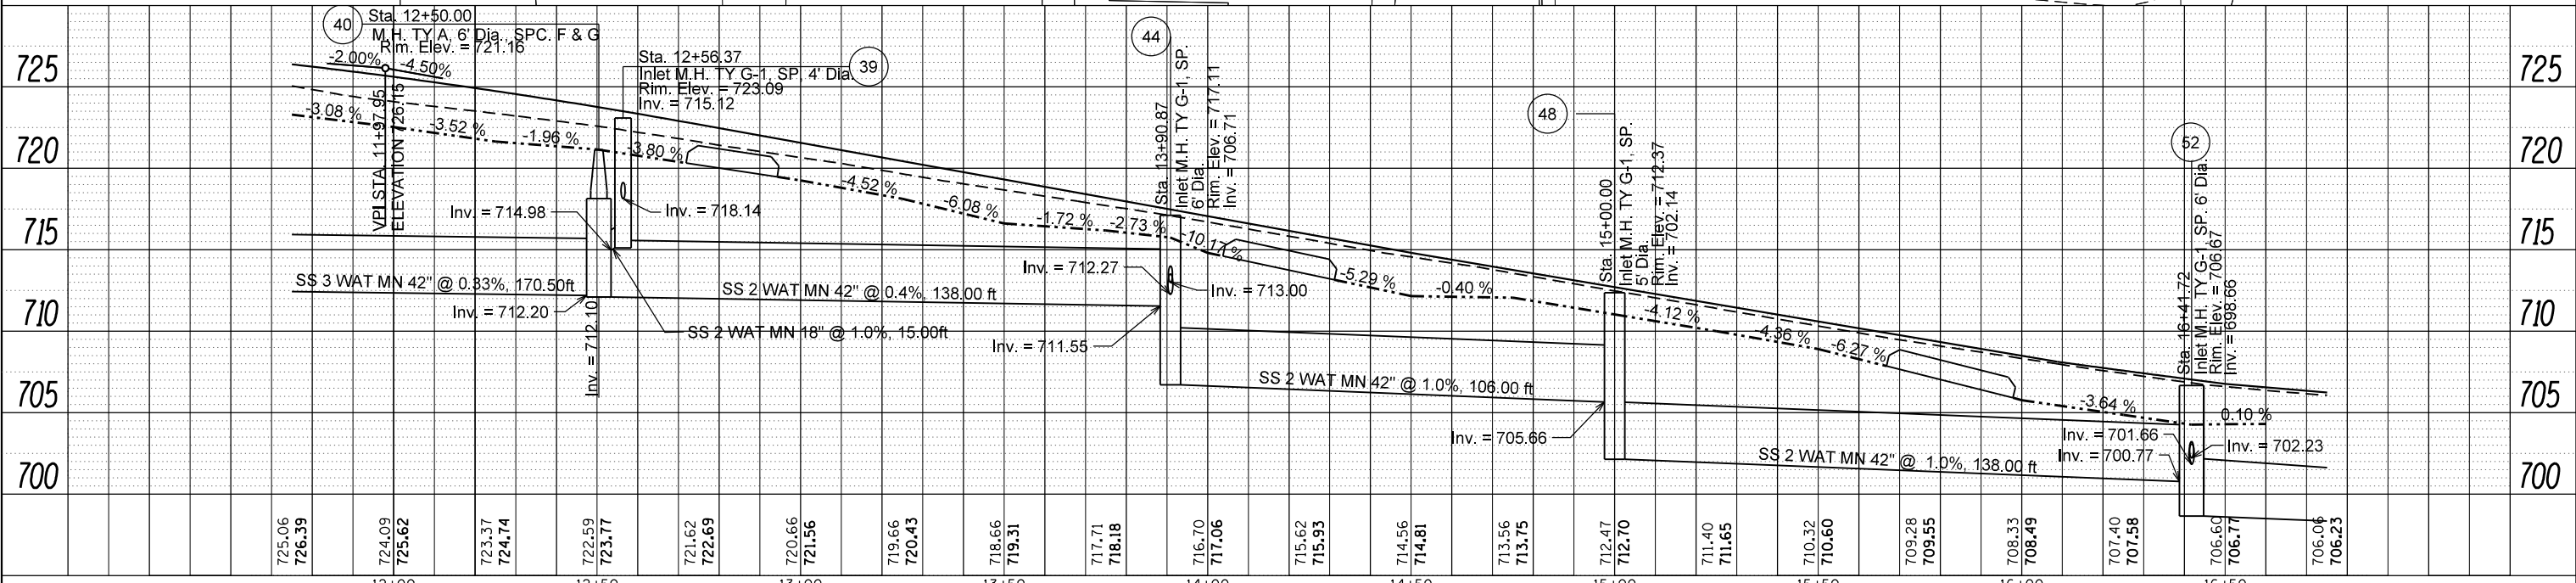


PLAN	SURVEYED	DATE
	PLOTTED	
	GRADES CHECKED	
	ALIGNED	
	FILE NAME	
	NO.	

PROFILE	SURVEYED	DATE
	PLOTTED	
	GRADES CHECKED	
	ALIGNED	
	FILE NAME	
	NO.	

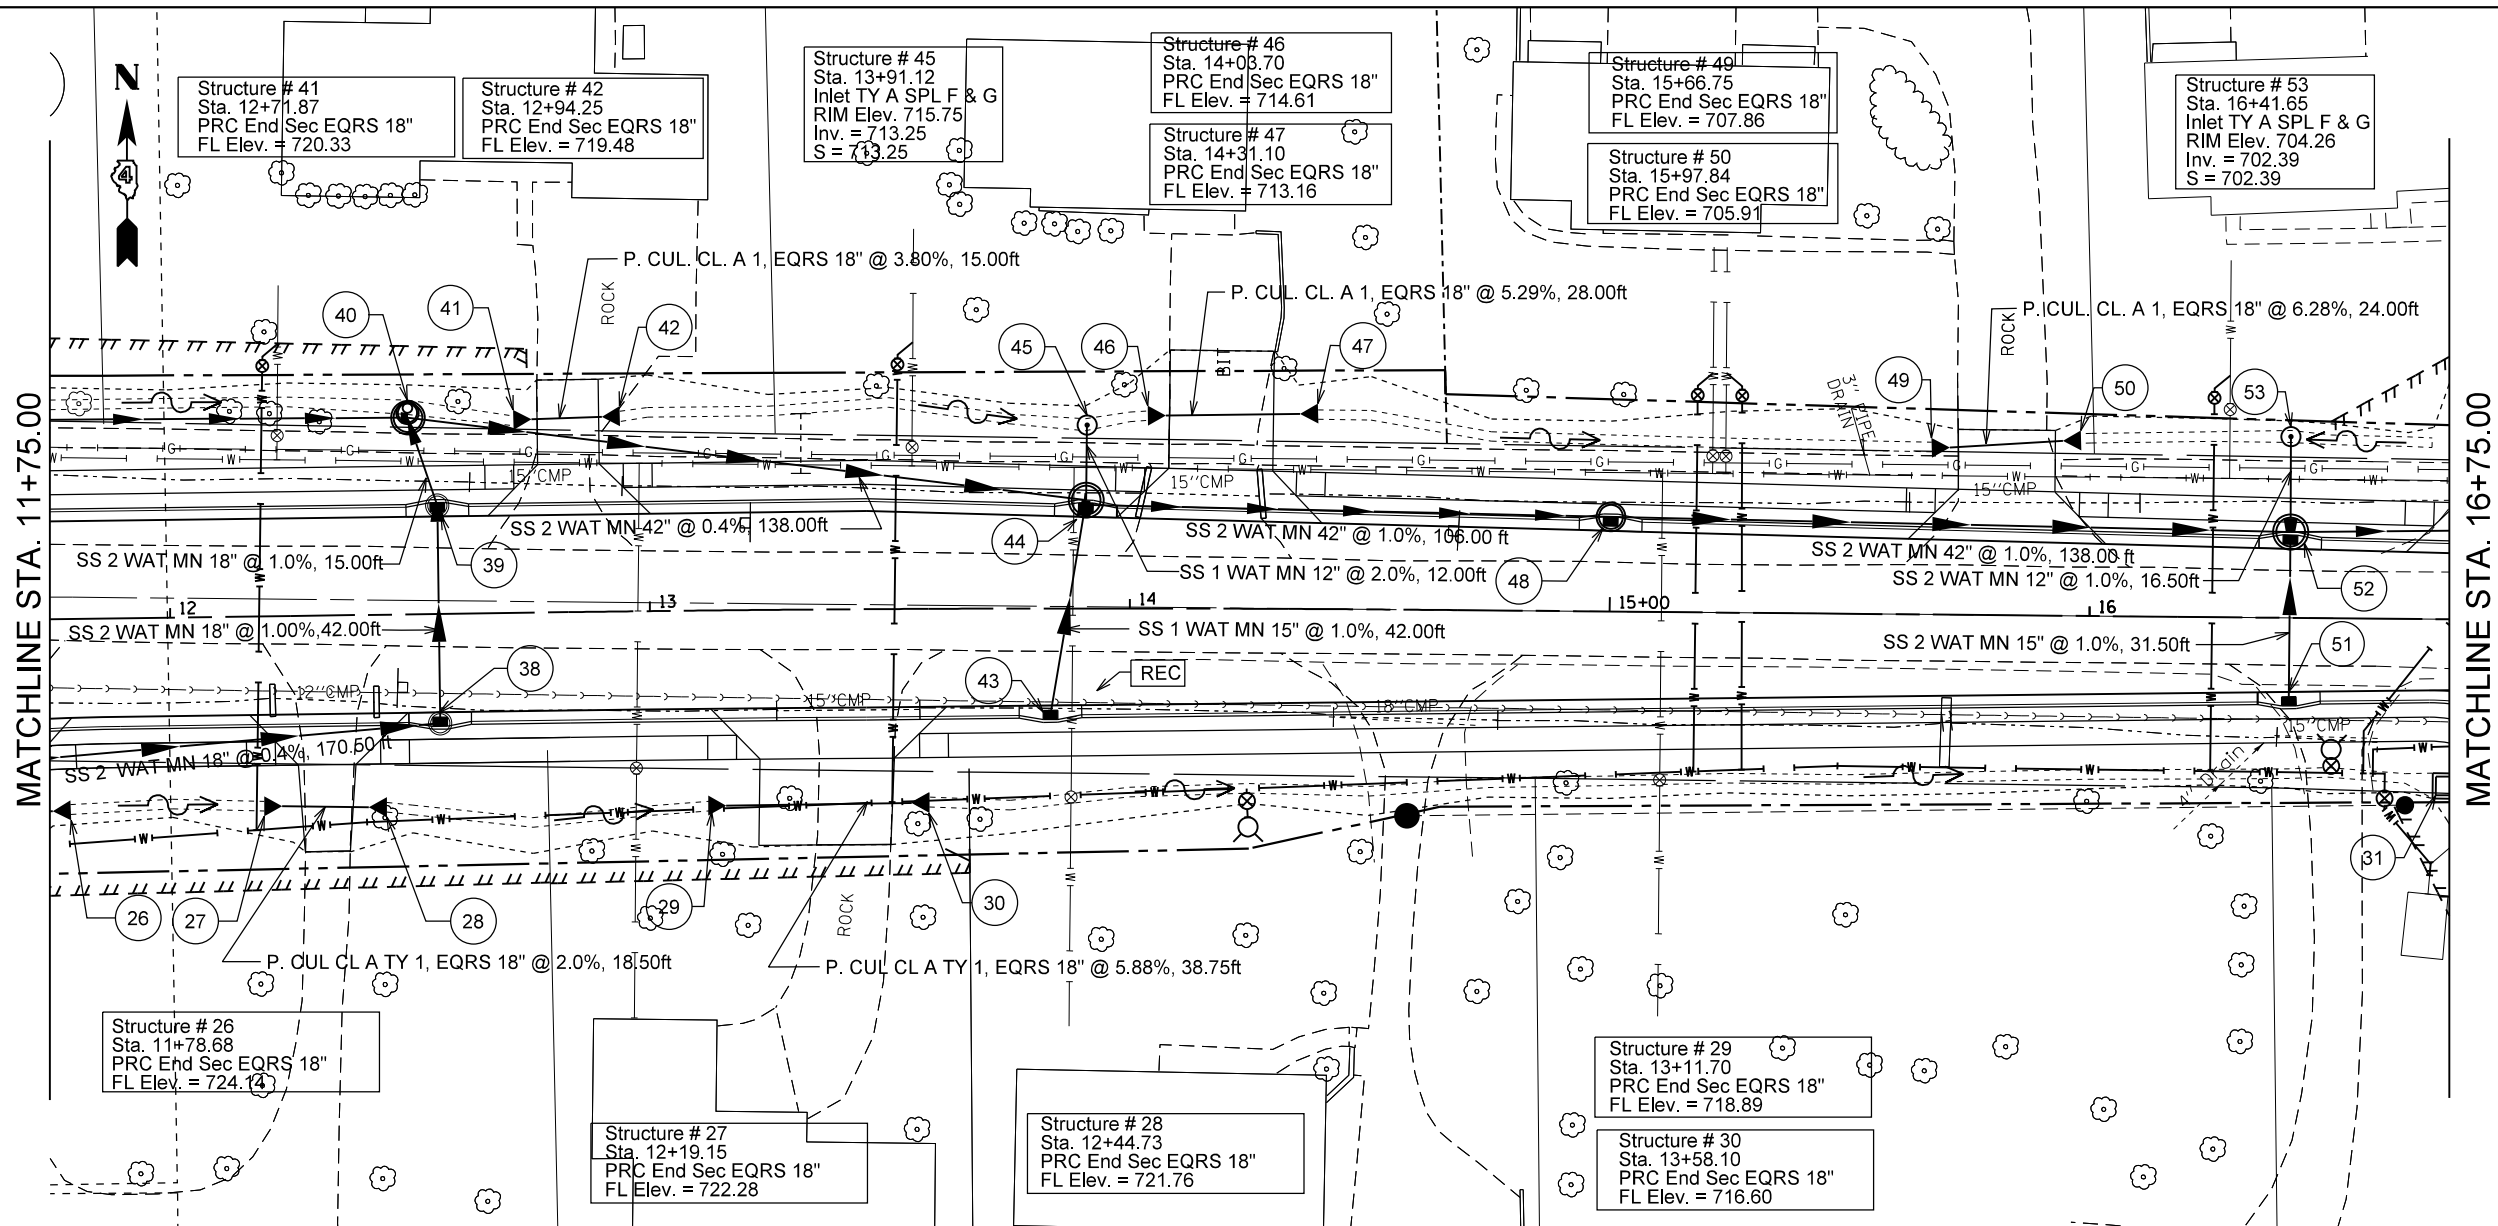

FILE NAME =	USER NAME = crespole	DESIGNED -	REVISED -	<b>STATE OF ILLINOIS DEPARTMENT OF TRANSPORTATION</b>	<b>LEGION HALL ROAD DRAINAGE PLANS LT SIDE</b>	F.A.S. RT. =	SECTION	COUNTY	TOTAL SHEETS	SHEET NO.
c:\pwork\pwork\crespole\d0330150\048872-SHT-LHR-DRAIN-LT-rev.DGN		DRAWN -	REVISED -			1380	7W-1,RS-3	Peoria	617	247
PLOT SCALE = 40.0000' / in.		CHECKED -	REVISED -			CONTRACT NO. 88792				
Default		DATE -	REVISED -			ILLINOIS FED. AID PROJECT				