



|      |           |    |      |
|------|-----------|----|------|
| PLAN | SURVEYED  | BY | DATE |
|      | PLOTTED   |    |      |
|      | ALIGNED   |    |      |
|      | CHECKED   |    |      |
|      | FILE NAME |    |      |
|      | NO.       |    |      |

|         |           |    |      |
|---------|-----------|----|------|
| PROFILE | SURVEYED  | BY | DATE |
|         | PLOTTED   |    |      |
|         | GRADES    |    |      |
|         | CHECKED   |    |      |
|         | STRUCTURE |    |      |
|         | NOTATIONS |    |      |
|         | CPAD      |    |      |

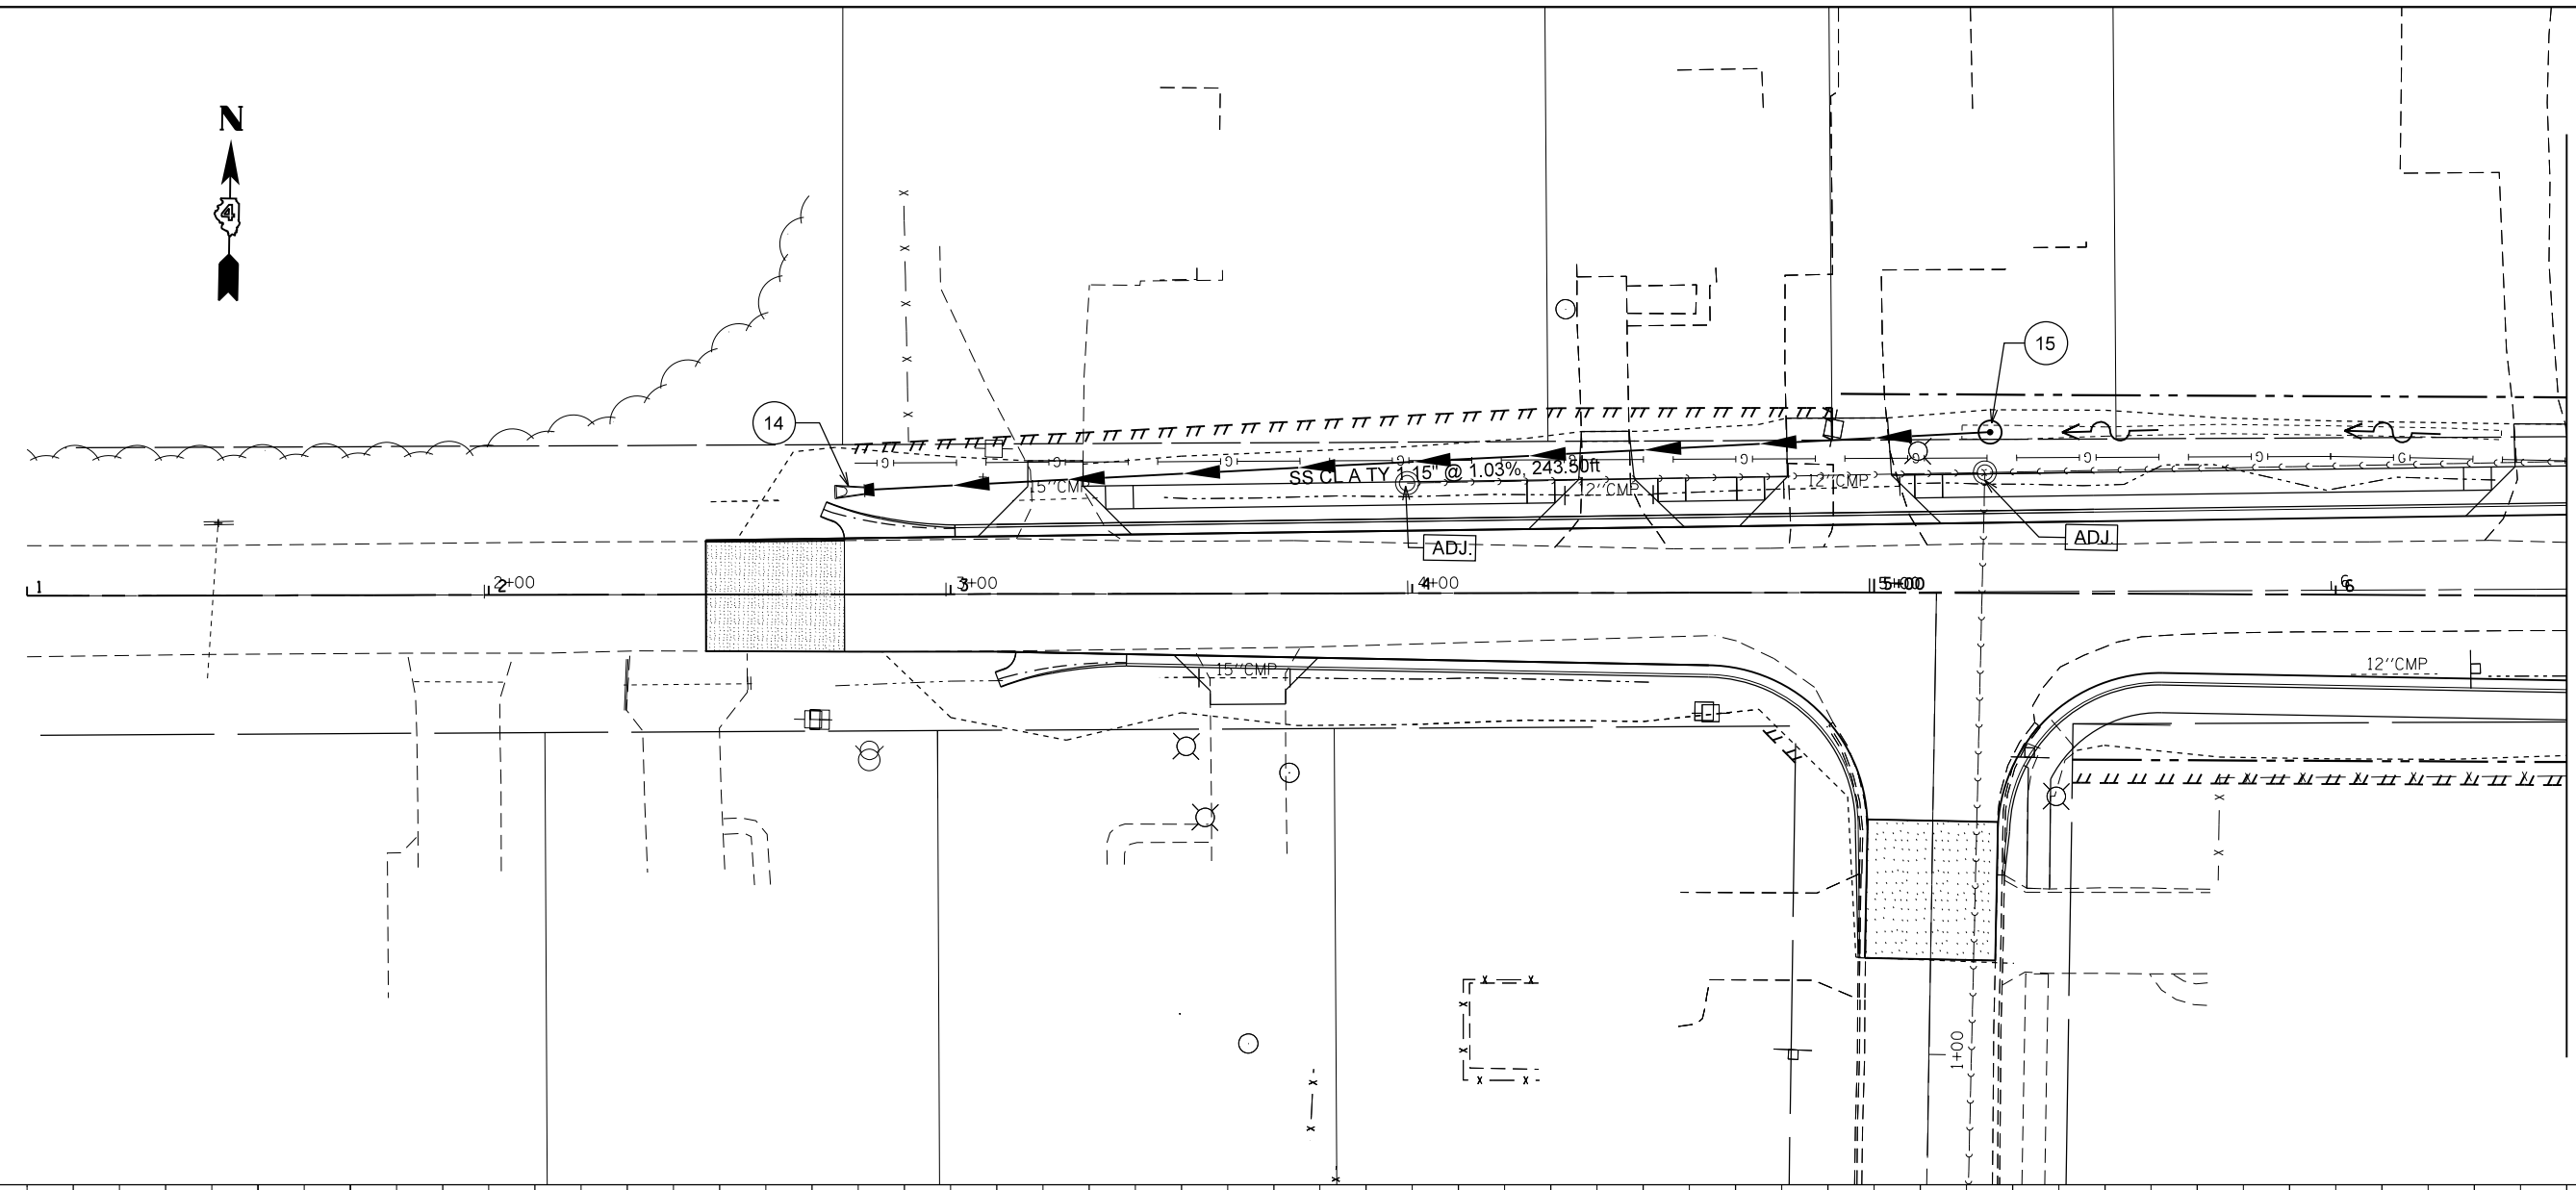

MATCHLINE STA. 6+50.00

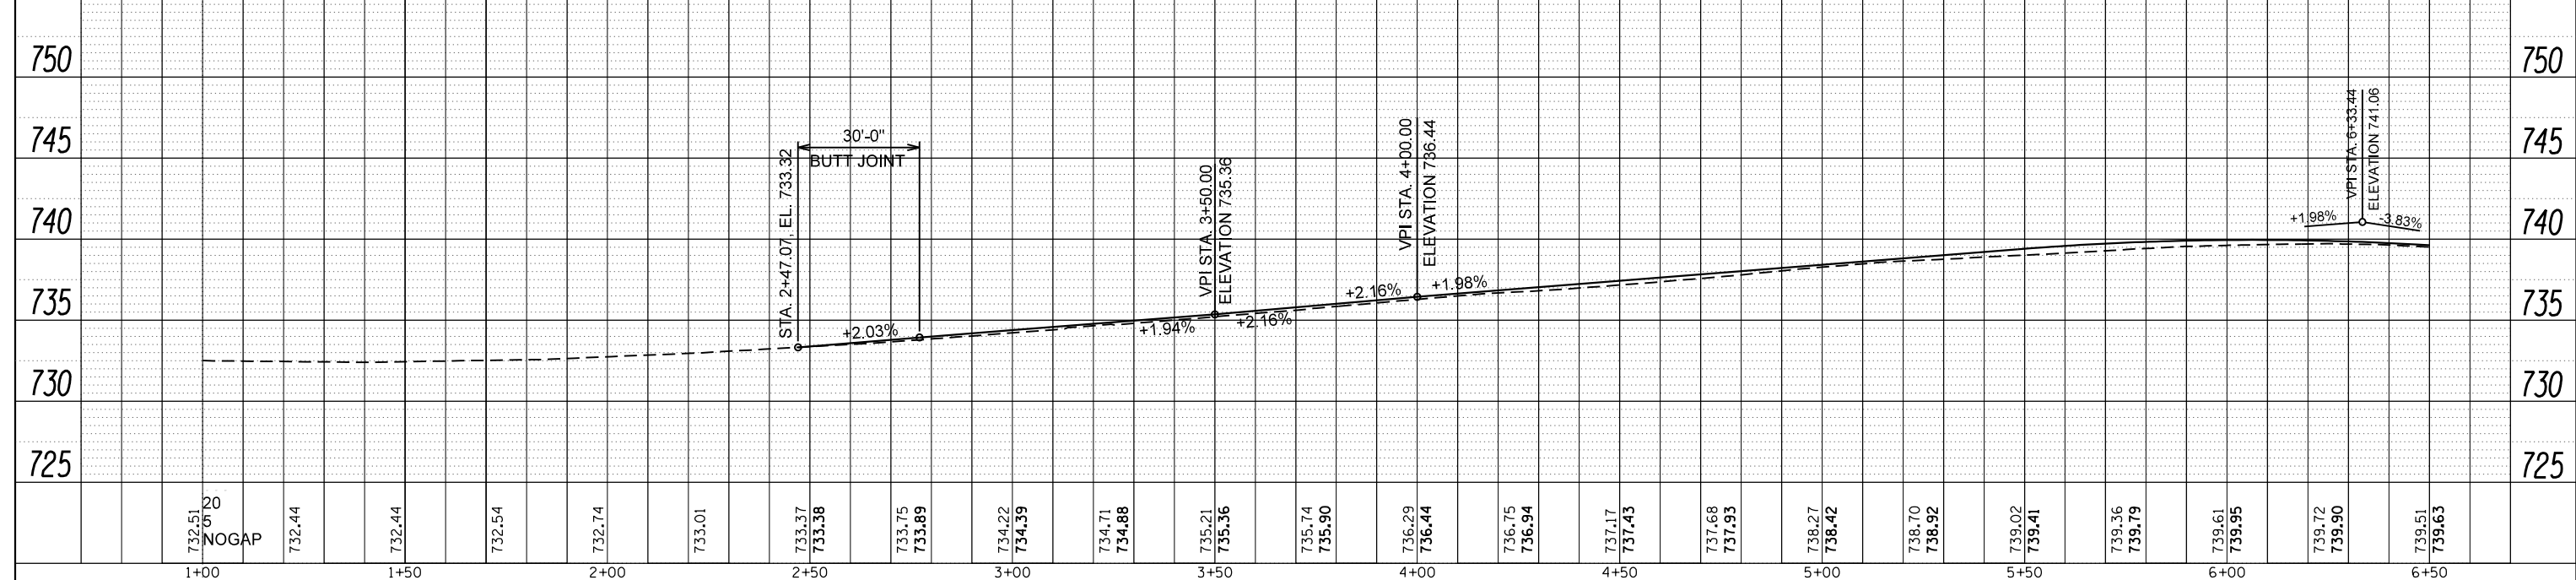

|   |                             |            |           |   |  |       |    |                  |                   |               |                  |                           |
|---|-----------------------------|------------|-----------|---|--|-------|----|------------------|-------------------|---------------|------------------|---------------------------|
| FILE NAME =   | USER NAME = crespole        | DESIGNED - | REVISED - | <b>STATE OF ILLINOIS<br/>DEPARTMENT OF TRANSPORTATION</b> | <b>LEGION HALL RD<br/>DRAINAGE PLANS RT SIDE</b> |       |    | F.A.S. RTE. 1380 | SECTION 7W-1,RS-3 | COUNTY Peoria | TOTAL SHEETS 617 | SHEET NO. 249             |
| c:\pwork\pwork\crespole\0330150\048872-SHT-LHR-DRAIN-RT-rev.DGN | PLOT SCALE = 40.0000' / in. | DRAWN -    | REVISED - |   | SCALE:   | SHEET | OF | SHEETS           | STA.              | TO            | STA.             | CONTRACT NO. 88792        |
| Default   | PLOT DATE = 8/14/2013       | CHECKED -  | REVISED - |   |  |       |    |                  |                   |               |                  | ILLINOIS FED. AID PROJECT |
|   |                             | DATE -     | REVISED - |   |  |       |    |                  |                   |               |                  |                           |