
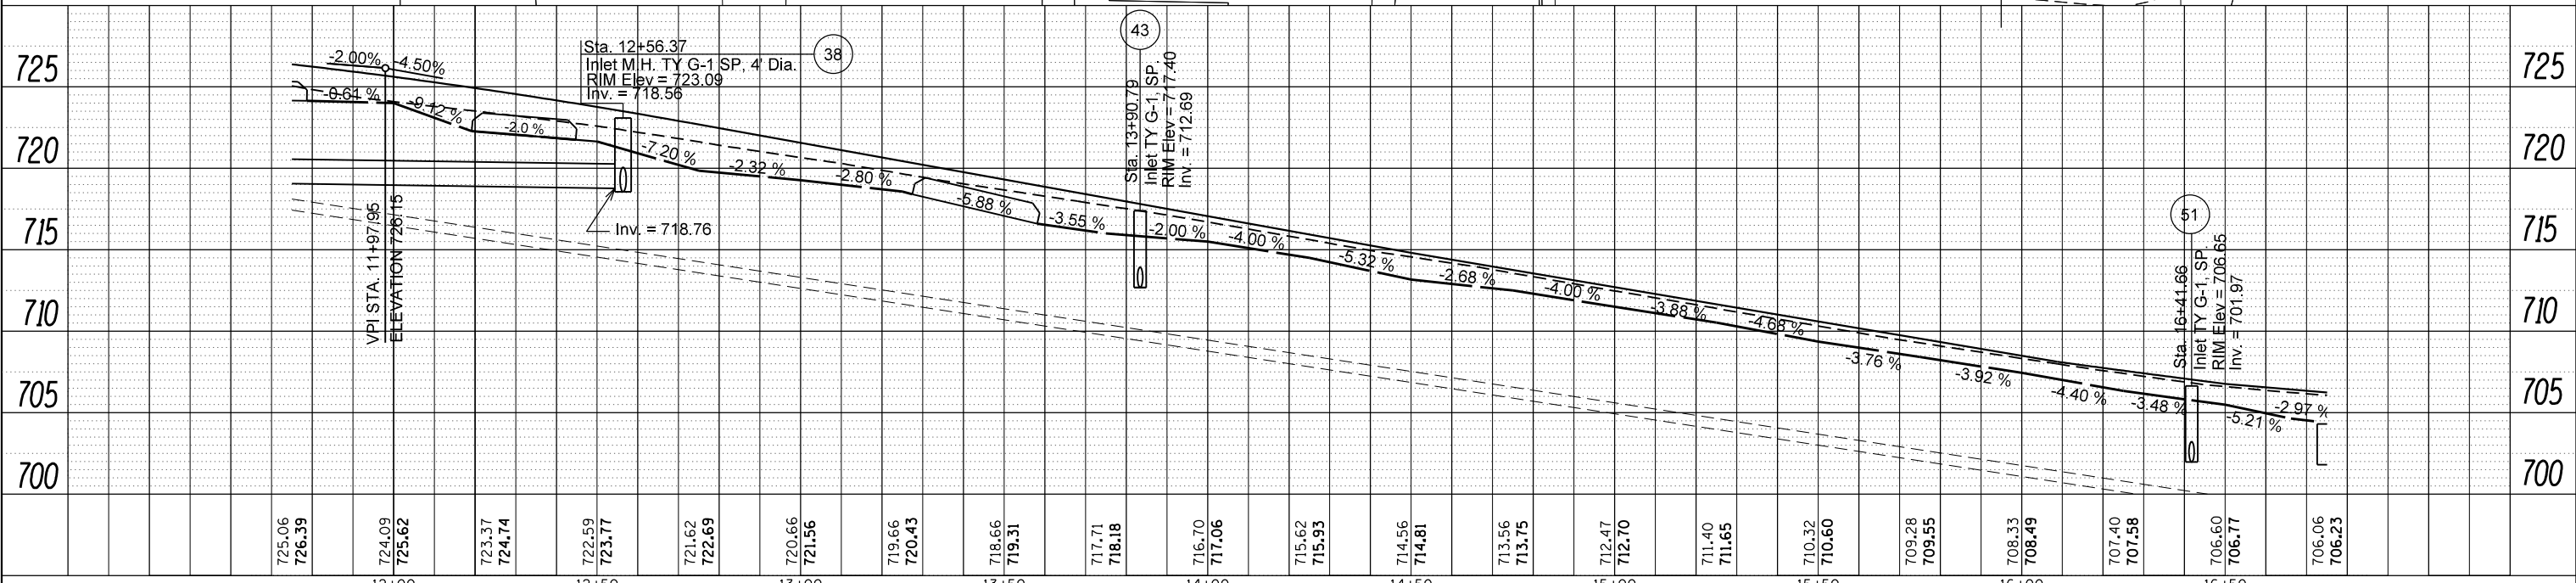


PLAN	SURVEYED	DATE
	PLOTTED	
	ALIGNED	
	CHECKED	
	FILE NAME	
	NO.	

PROFILE	SURVEYED	DATE
	PLOTTED	
	GRADES CHECKED	
	STRUCTURE NOTATIONS CHECKED	
	NO.	

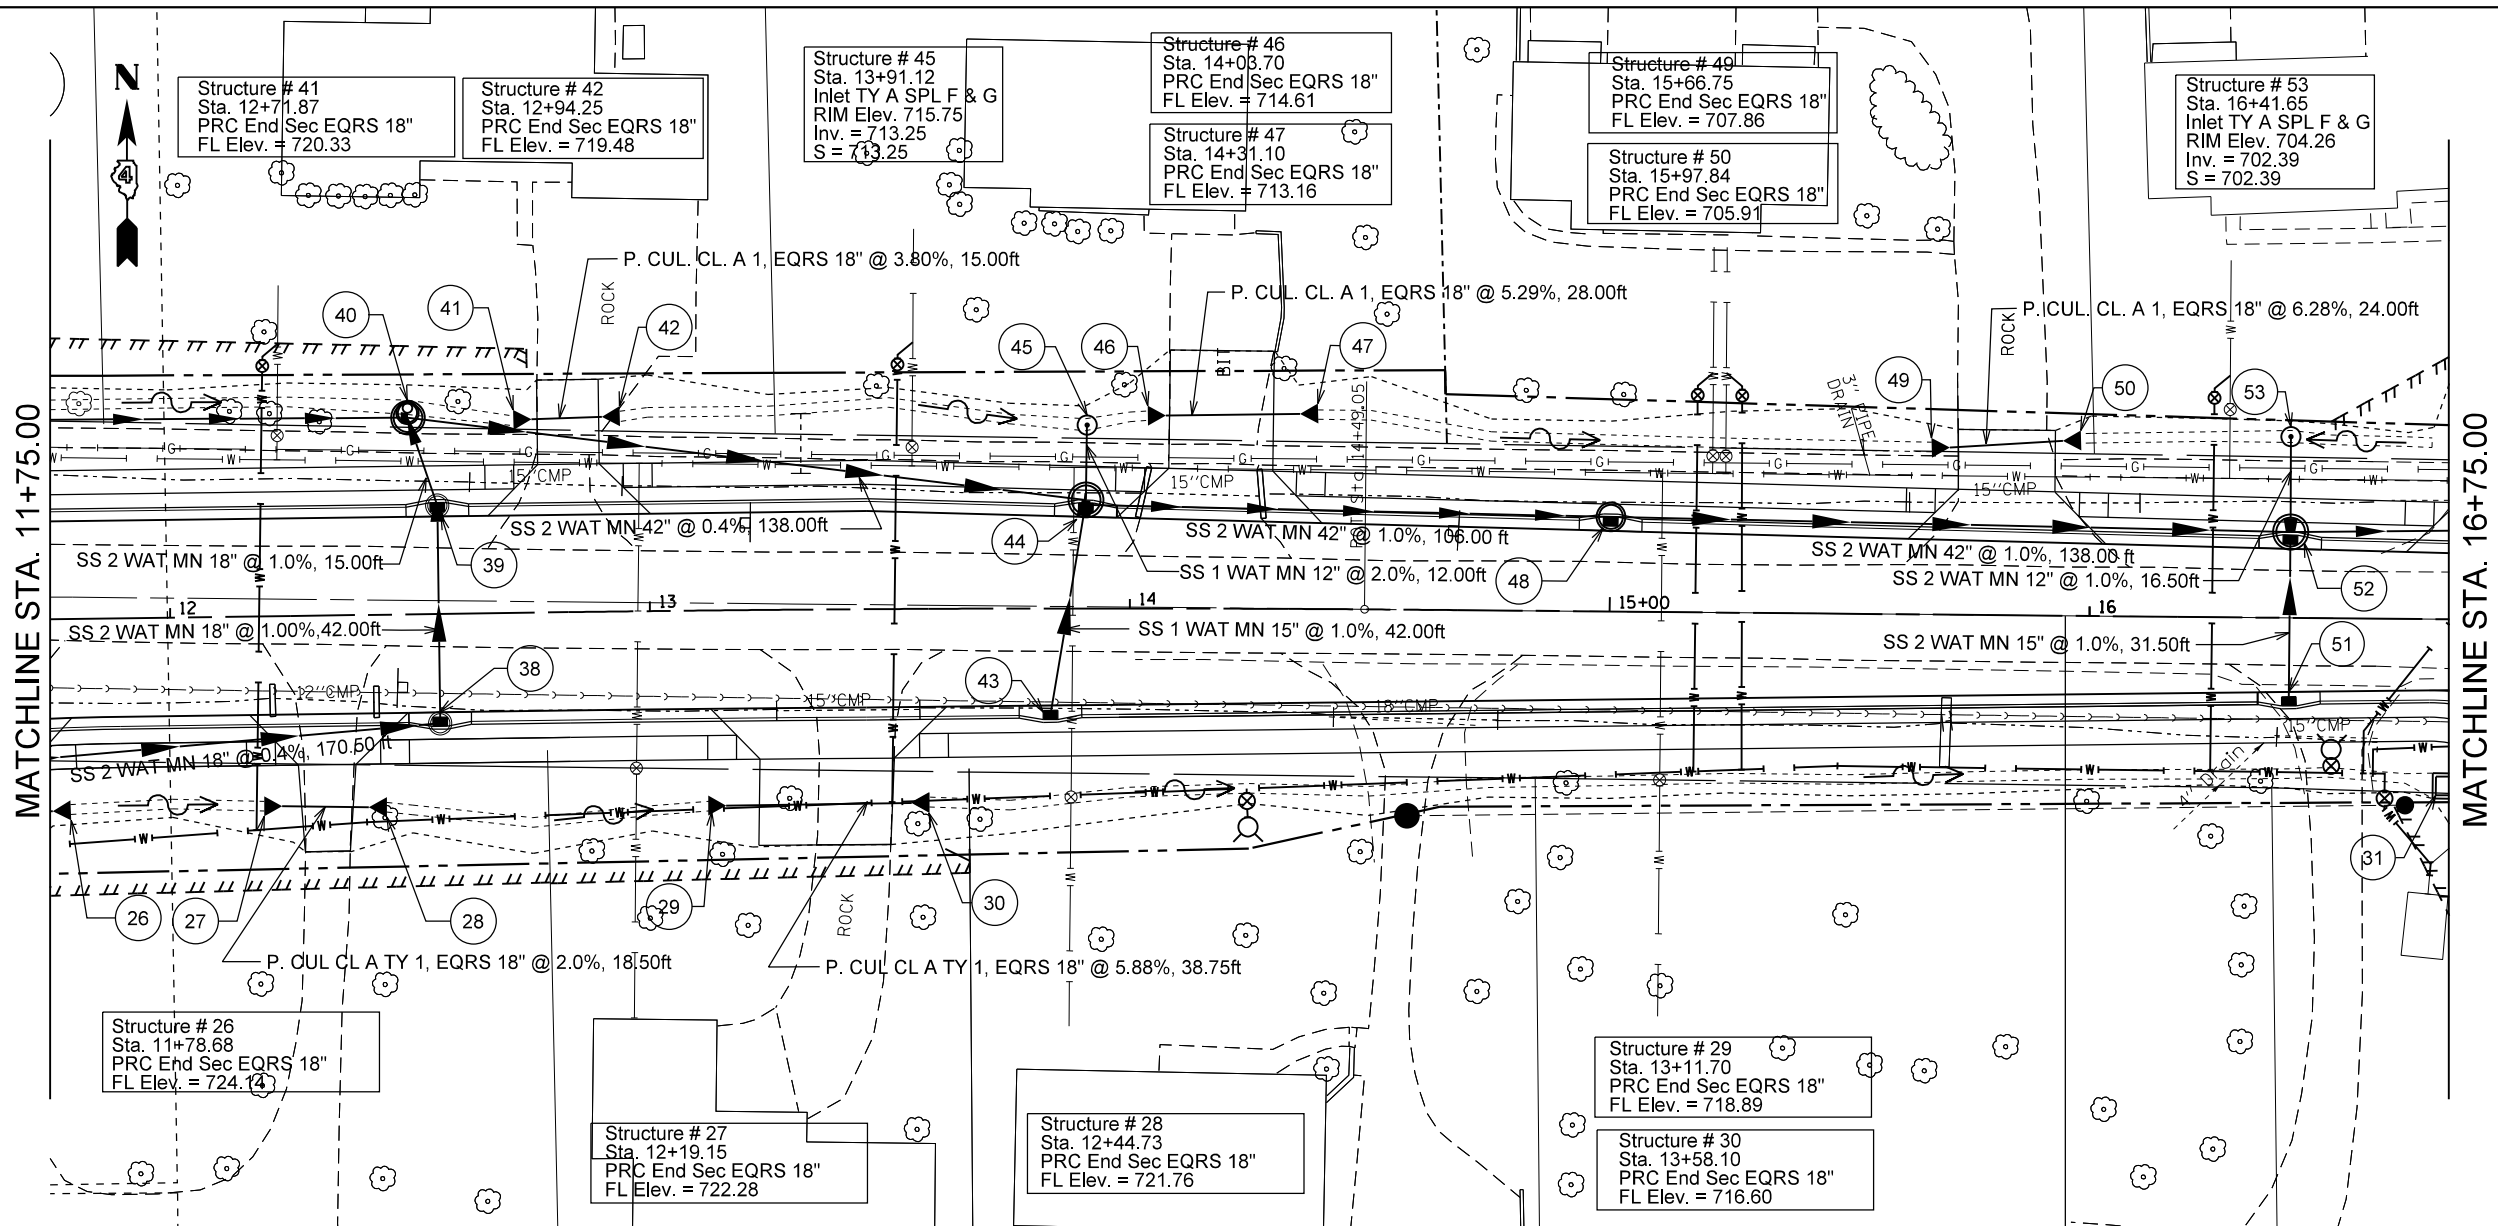

FILE NAME =	USER NAME = crespole	DESIGNED -	REVISED -	STATE OF ILLINOIS DEPARTMENT OF TRANSPORTATION	LEGION HALL RD DRAINAGE PLANS RT SIDE				F.A.S. R.T.E. = 1380	SECTION = 7W-1,RS-3	COUNTY = Peoria	TOTAL SHEETS = 617	SHEET NO. = 251
c:\pwork\pwork\crespole\0330150\04887	2-SHT-LHR-DRAIN-RT-rev.DGN	DRAWN -	REVISED -		SCALE:	SHEET	OF	SHEETS	STA.	TO	STA.	CONTRACT NO. 88792	
	PLOT SCALE = 40.0000' / in.	CHECKED -	REVISED -		ILLINOIS FED. AID PROJECT								
Default	PLOT DATE = 8/14/2013	DATE -	REVISED -										