

ALL EXISTING UTILITIES LOCATIONS AND DEPTHS TO BE VERIFIED PRIOR TO ALL DRILLING AND BORES.

| FIRE HYDRANTS TO BE REMOVED | |
|-----------------------------|--------------|
| LOCATION | |
| LT. STA. 93+41 | 1 EA. |
| LT. STA. 97+64 | 1 EA. |
| SHEET TOTALS | 2 EA. |

| REMOVE EXISTING WATER VALVE | |
|-----------------------------|--------------|
| LOCATION | |
| LT. STA. 97+56 | 1 EA. |
| SHEET TOTAL | 1 EA. |

| WATER SERVICE CONNECTION | |
|--------------------------|--------------|
| LOCATION | |
| LT. STA. 93+17 | 1 EA. |
| LT. STA. 94+17 | 1 EA. |
| LT. STA. 97+62 | 1 EA. |
| SHEET TOTALS | 3 EA. |

| WATER MAIN TEE 8"x6" | |
|----------------------|--------------|
| LOCATION | |
| LT. STA. 93+41 | 1 EA. |
| LT. STA. 97+64 | 1 EA. |
| SHEET TOTALS | 2 EA. |



| FIRE HYDRANT AND VALVE (SPECIAL) | |
|----------------------------------|--------------|
| LOCATION | |
| 47' LT. STA. 93+41 | 1 EA. |
| 47' LT. STA. 97+64 | 1 EA. |
| SHEET TOTALS | 2 EA. |

| WATER VALVES, 8" | |
|--------------------|--------------|
| LOCATION | |
| LT. STA. 93+13 | 1 EA. |
| SHEET TOTAL | 1 EA. |

| WATER MAIN, 8" | |
|------------------------------|----------------|
| LOCATION | |
| LT. STA. 92+00 TO STA. 98+00 | 600 FT. |
| SHEET TOTAL | 600 FT. |

PLAN VIEW

SCALE: 1" = 20' HOR

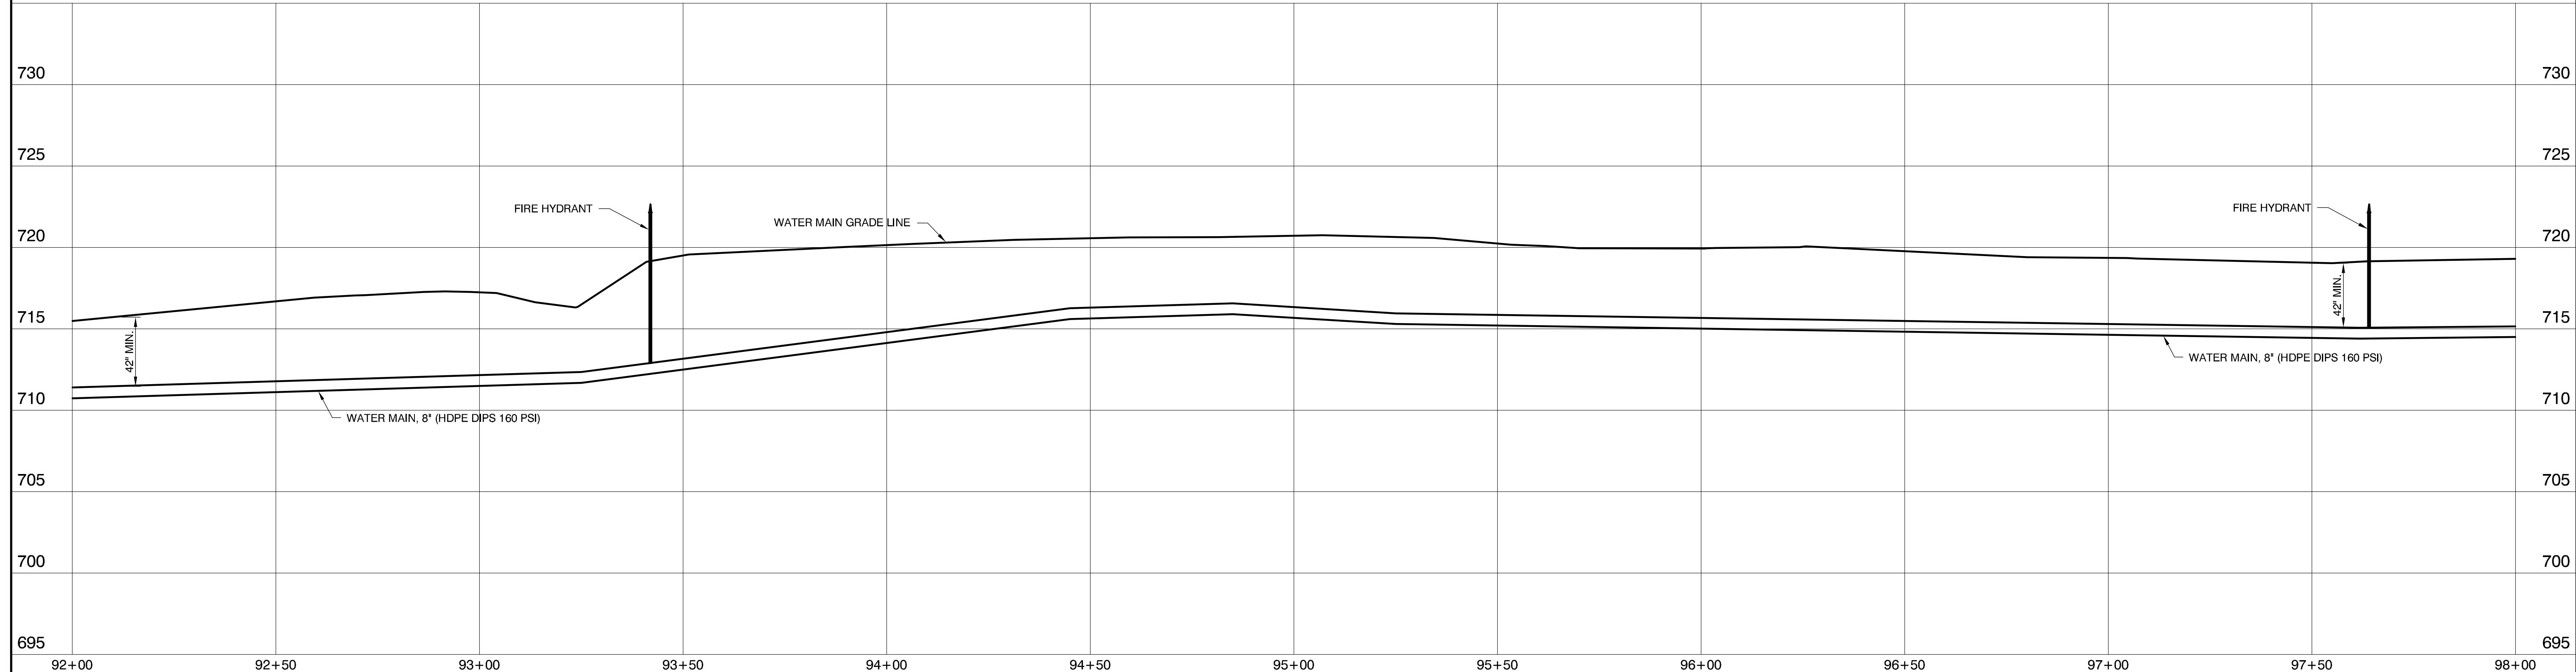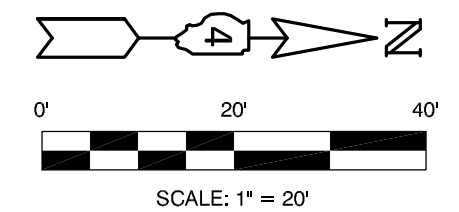

PROFILE VIEW

SCALE: 1" = 20' HOR
1" = 5' VER

M MOHR & KERR ENGINEERING & LAND SURVEYING, P.C.
7336 N. University Ave. Office: (309) 692-8500
Peoria, Illinois 61614 Fax: (309) 692-8501
www.mohrandkerr.com Professional Design Firm #184.005091

| | | |
|----------|----------|---------|
| DESIGNED | WFS | REVISED |
| DRAWN | DEH | REVISED |
| CHECKED | WFS | REVISED |
| DATE | 08-30-13 | REVISED |

STATE OF ILLINOIS
DEPARTMENT OF TRANSPORTATION

IL RTE 91
WATER MAIN PLANS
PLAN AND PROFILE SHEET
SCALE: 1" = 20' SHEET NO. 6 OF 17 SHEETS STA. 92+00 TO STA. 98+00

| | | | | |
|--------------------------------|------------|--------|--------------|-----------|
| F.A. ROUTE | SECTION | COUNTY | TOTAL SHEETS | SHEET NO. |
| 1380 | 7W-1, RS-3 | PEORIA | 617 | 260 |
| CONTRACT NO. 88792 | | | | |
| ILLINOIS FEDERAL ROAD DIST NO. | | | | |

12-108