
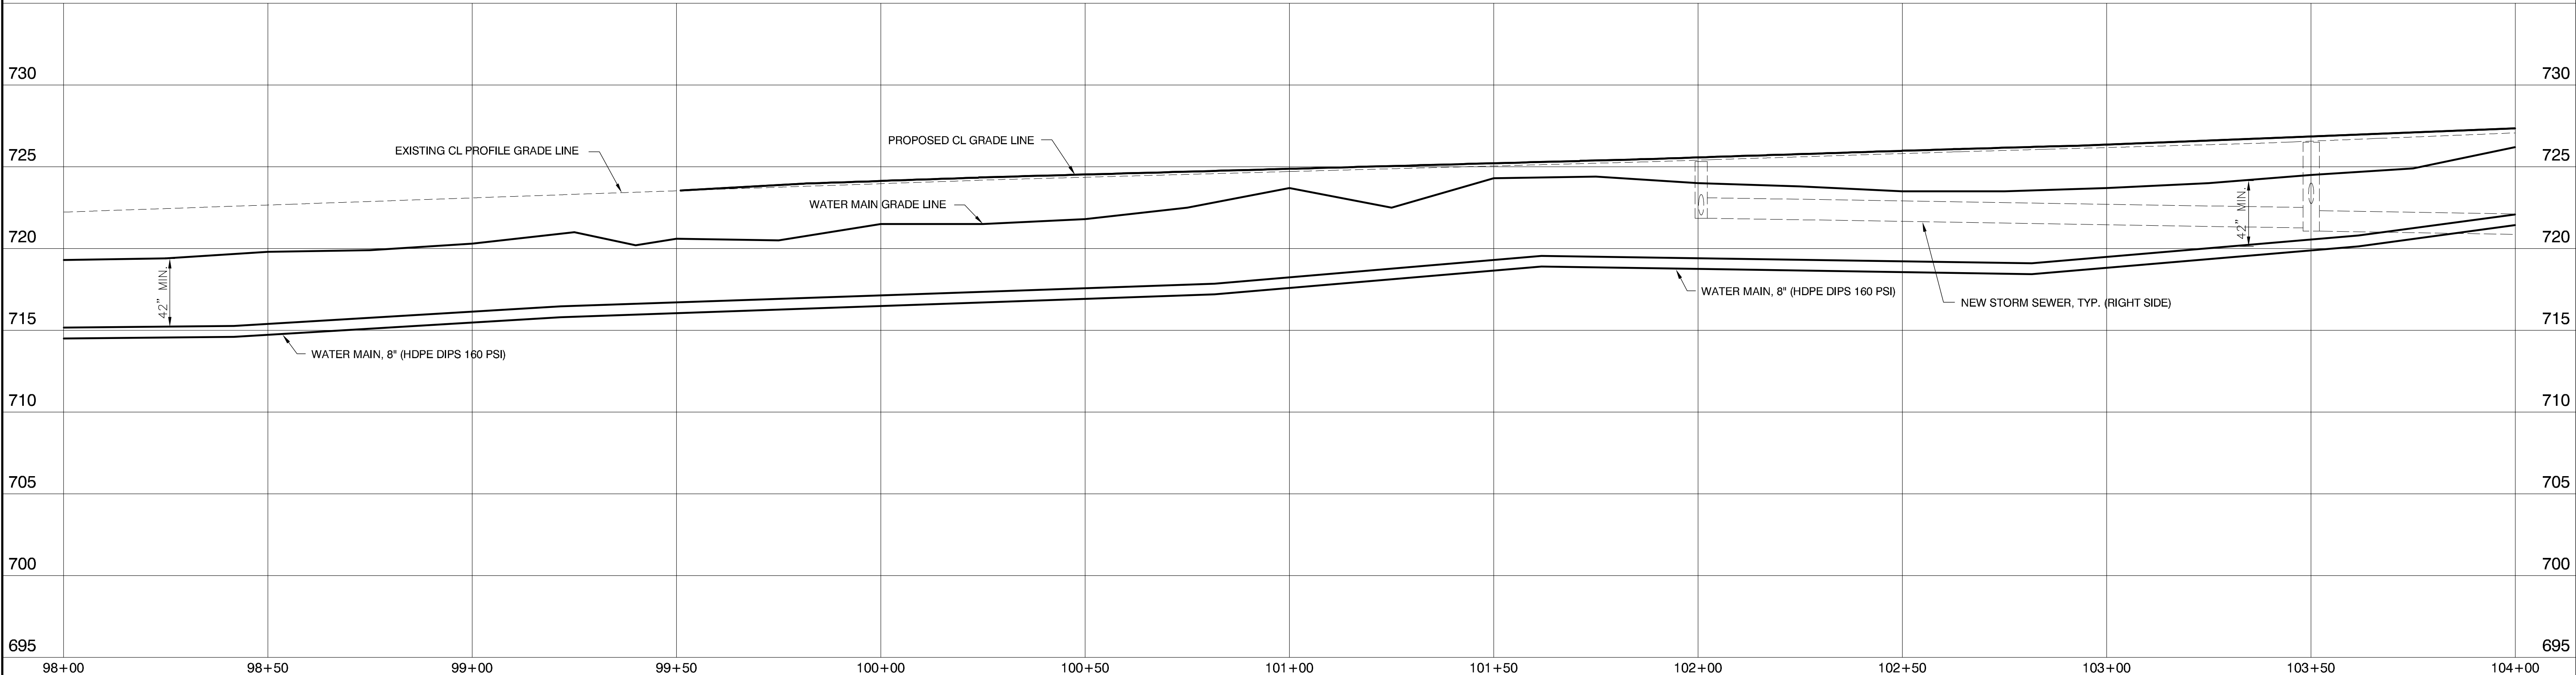


ALL EXISTING UTILITIES LOCATIONS AND DEPTHS TO BE VERIFIED PRIOR TO ALL DRILLING AND BORES.

WATER SERVICE CONNECTION		WATER MAIN, 8"	
LOCATION		LOCATION	
LT. STA. 100+60	1 EA.	LT. STA. 98+00 TO STA. 104+00	600 FT.
SHEET TOTAL	1 EA.	SHEET TOTAL	600 FT.

PLAN VIEW

SCALES: 1" = 20' HOR

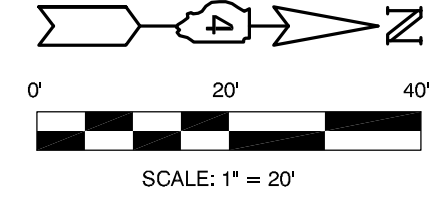

PROFILE VIEW

SCALES: 1" = 20' HOR
1" = 5' VER

M MOHR & KERR ENGINEERING & LAND SURVEYING, P.C.
7336 N. University Ave. Office: (309) 692-8500
Peoria, Illinois 61614 Fax: (309) 692-8501
www.mohrandkerr.com Professional Design Firm #184.005091

DESIGNED	WFS	REVISED
DRAWN	DEH	REVISED
CHECKED	WFS	REVISED
DATE	08-30-13	REVISED

STATE OF ILLINOIS
DEPARTMENT OF TRANSPORTATION

IL RTE 91
WATER MAIN PLANS
PLAN AND PROFILE SHEET
SCALE: 1" = 20' SHEET NO. 7 OF 17 SHEETS STA. 98+00 TO STA. 104+00

F.A. ROUTE	SECTION	COUNTY	TOTAL SHEETS	SHEET NO.
1380	7W-1, RS-3	PEORIA	617	261
CONTRACT NO. 88792				
ILLINOIS FEDERAL ROAD DIST NO.				