


PLAN VIEW

SCALES: 1" = 20' HOR

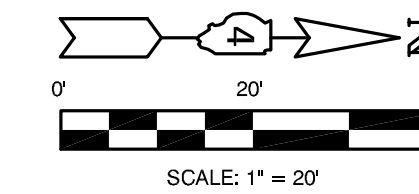

ALL EXISTING UTILITIES LOCATIONS AND DEPTHS TO BE VERIFIED PRIOR TO ALL DRILLING AND BORES.

FIRE HYDRANTS TO BE REMOVED

LOCATION	QUANTITY
RT. STA. 124+88	1 EA.
SHEET TOTAL	1 EA.

WATER MAIN TEE 8"x6"

LOCATION	QUANTITY
RT. STA. 124+87.5	1 EA.
SHEET TOTAL	1 EA.

WATER SERVICE CONNECTION

LOCATION	QUANTITY
LT. STA. 122+32	1 EA.
RT. STA. 122+57	1 EA.
LT. STA. 122+82	1 EA.
RT. STA. 122+26	1 EA.
LT. STA. 123+63	1 EA.
LT. STA. 125+34	1 EA.
LT. STA. 125+45	1 EA.
LT. STA. 126+25	1 EA.
LT. STA. 127+18	1 EA.
SHEET TOTALS	9 EA.

FIRE HYDRANT AND VALVE (SPECIAL)


LOCATION	QUANTITY
39' RT. STA. 124+87.5	1 EA.
SHEET TOTAL	1 EA.

WATER VALVES, 8"

LOCATION	QUANTITY
RT. STA. 125+00	1 EA.
SHEET TOTAL	1 EA.

WATER MAIN, 8"

LOCATION	LENGTH
RT. STA. 122+00 TO STA. 128+00	600 FT.
SHEET TOTAL	600 FT.

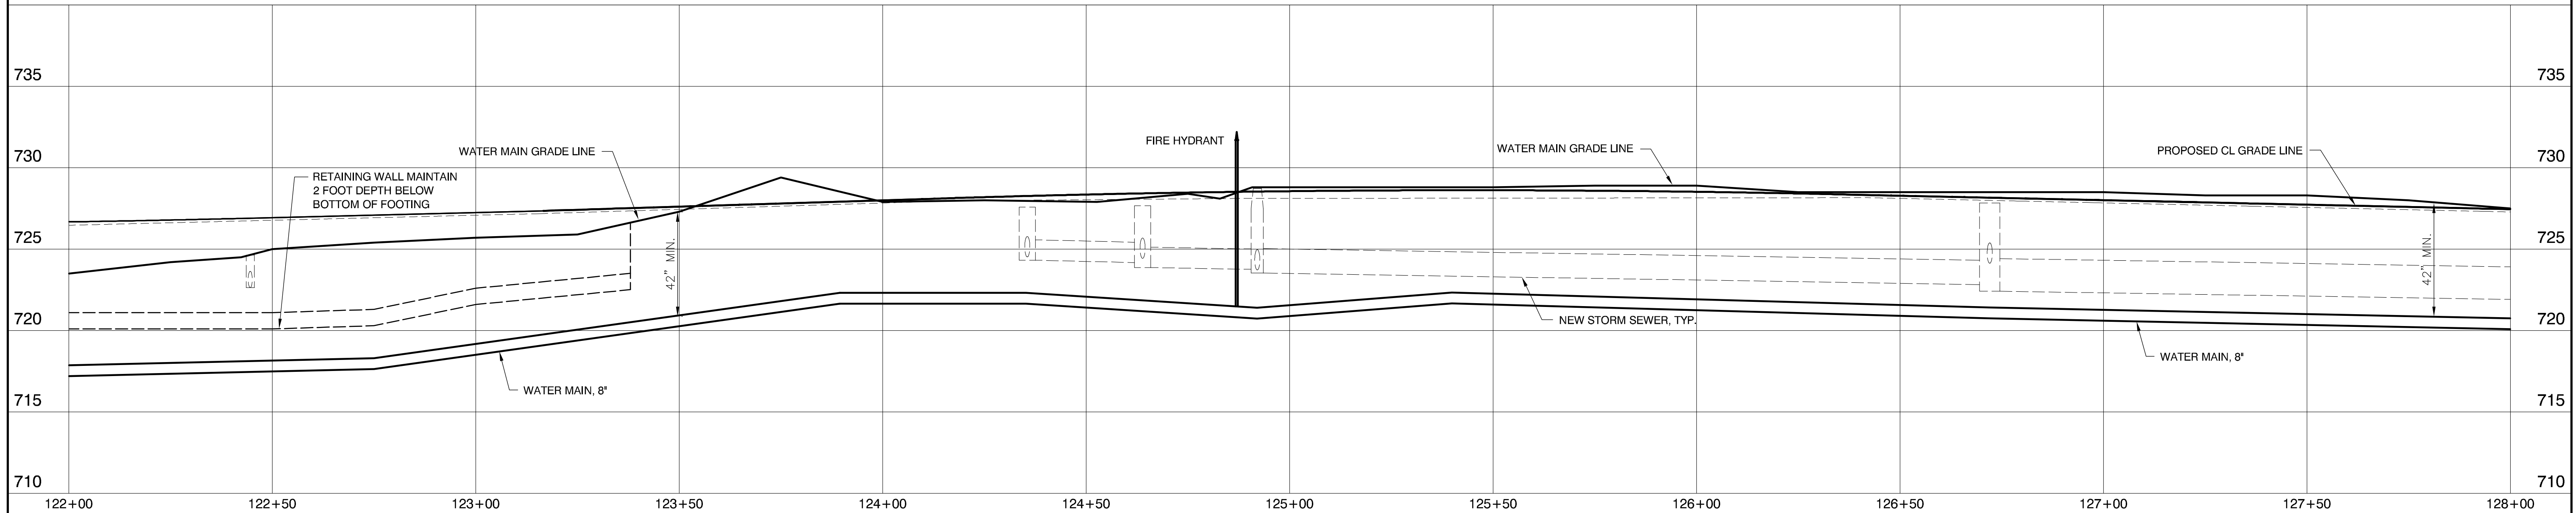

PROFILE VIEW

SCALES: 1" = 20' HOR
1" = 5' VER

M MOHR & KERR ENGINEERING & LAND SURVEYING, P.C.
7336 N. University Ave. Office: (309) 692-8500
Peoria, Illinois 61614 Fax: (309) 692-8501
www.mohrandkerr.com Professional Design Firm #184.005091

DESIGNED	WFS	REVISED
DRAWN	DEH	REVISED
CHECKED	WFS	REVISED
DATE	08-30-13	REVISED

STATE OF ILLINOIS
DEPARTMENT OF TRANSPORTATION

IL RTE 91
WATER MAIN PLANS
PLAN AND PROFILE SHEET
SCALE: 1" = 20' SHEET NO. 11 OF 17 SHEETS STA. 122+00 TO STA. 128+00

F.A. ROUTE	SECTION	COUNTY	TOTAL SHEETS	SHEET NO.
1380	7W-1, RS-3	PEORIA	617	265
CONTRACT NO. 88792				
ILLINOIS FEDERAL ROAD DIST NO.				