


F.A.I. RTE.	SECTION	COUNTY	TOTAL SHEETS	SHEET NO.
80	(50-5) HKB-2	LASALLE	331	35
STA. 815+00.00 TO STA. 830+00.00				
FED. ROAD DIST. NO.		ILLINOIS	FED. AID PROJECT	


NOTES:

1. SEE LIGHTING PLANS FOR THE LOCATIONS OF TEMPORARY AND PROPOSED LIGHTING
2. SEE TYPICAL SECTIONS FOR PAVEMENT STRUCTURE.

PLAN	SURVEYED	BY	DATE
	NOTED		
	CHECKED		
	BY		
	NO.		

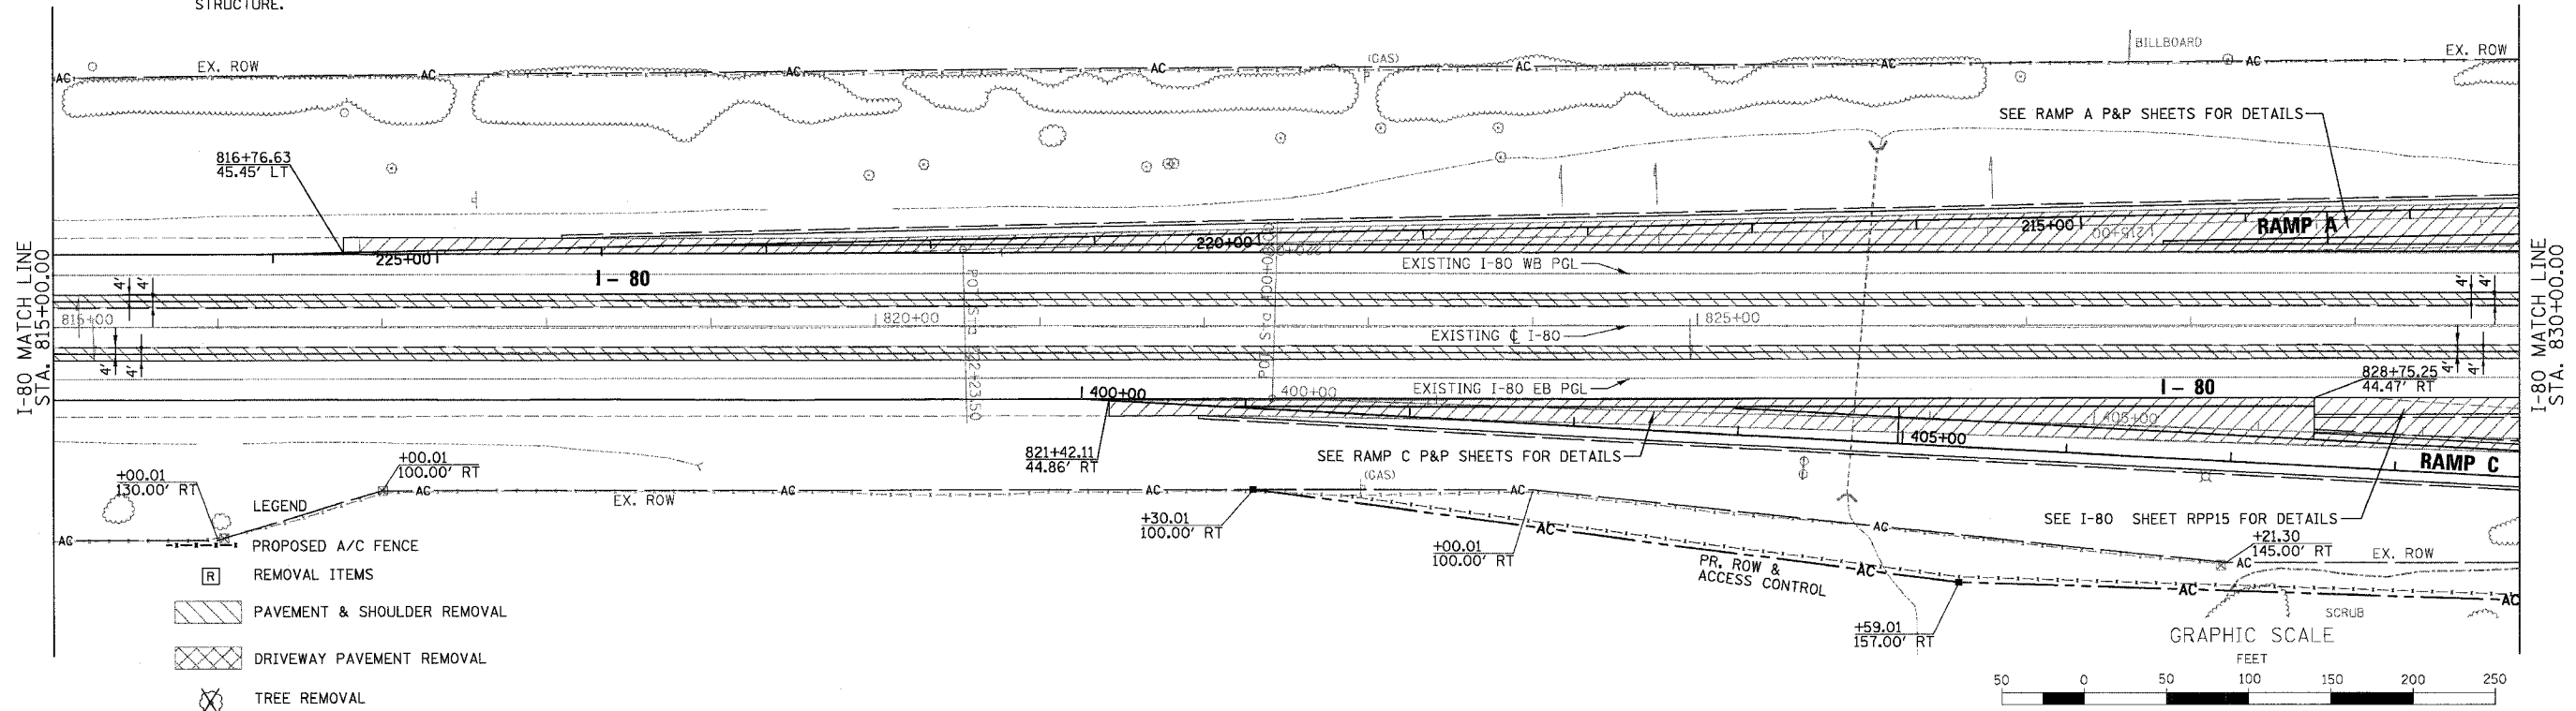

PROFILE	SURVEYED	BY	DATE
	NOTED		
	CHECKED		
	BY		
	NO.		

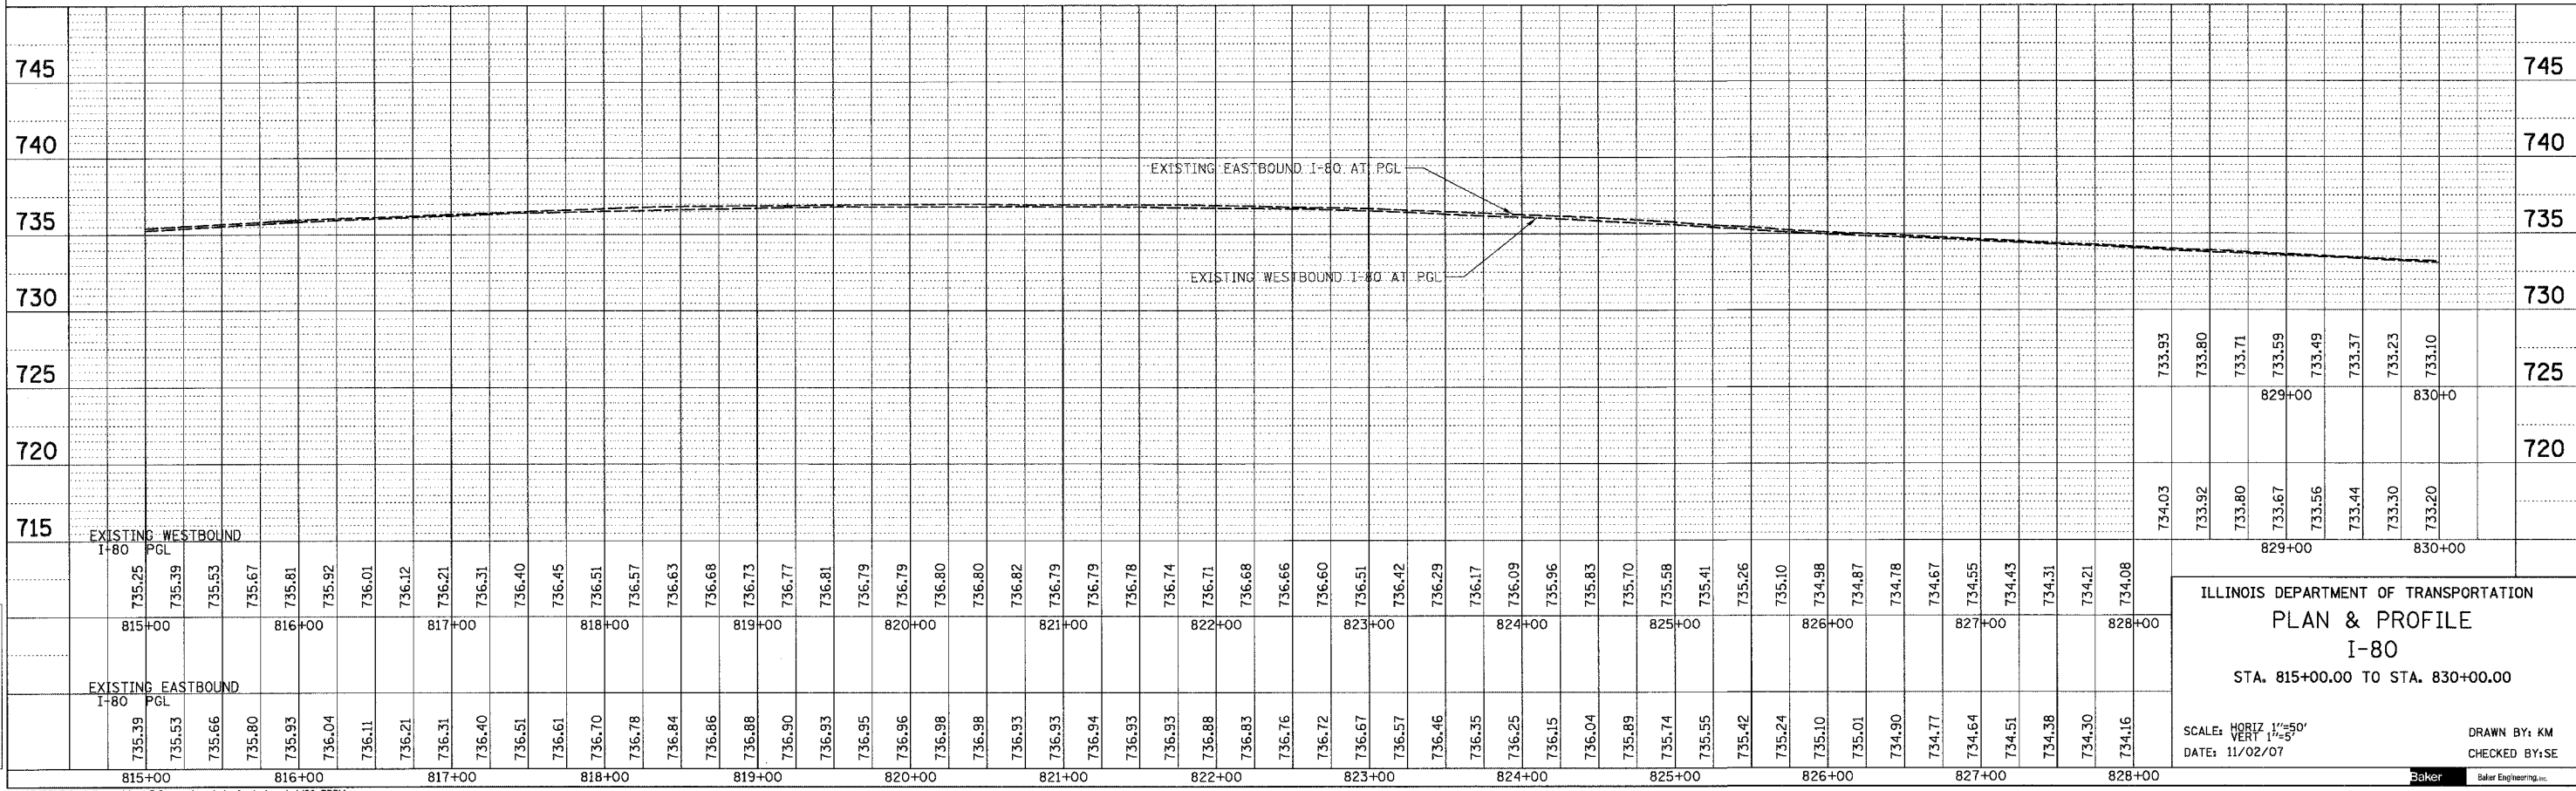

ILLINOIS DEPARTMENT OF TRANSPORTATION
PLAN & PROFILE
I-80
 STA. 815+00.00 TO STA. 830+00.00

SCALE: HORIZ 1"=50'
 VERT 1"=5'

DATE: 11/02/07

DRAWN BY: KM
 CHECKED BY: SE



h:\07486\3.0 deliverables\3.2 roadway\design\sheet\80.RPP14.rpp 1/5/2007