

F.A.I. RTE.	SECTION	COUNTY	TOTAL SHEETS	SHEET NO.
80	(50-5) HBK-2	LASALLE	331	37
STA. 845+00.00 TO STA. 860+00.00				
FED. ROAD DIST. NO. ILLINOIS FED. AID PROJECT				


NOTE:  
SEE LIGHTING PLANS FOR THE LOCATIONS OF TEMPORARY AND PROPOSED LIGHTING

SEE RAMP B P&P SHEETS FOR DETAILS

SEE RAMP D P&P SHEETS FOR DETAILS

SEE TYPICAL SECTIONS FOR PAVEMENT STRUCTURE.


PLAN	SURVEYED	BY	DATE
	NOTED		
	CHECKED		
	BY		
	NO. OF SHEETS		
	DATE		

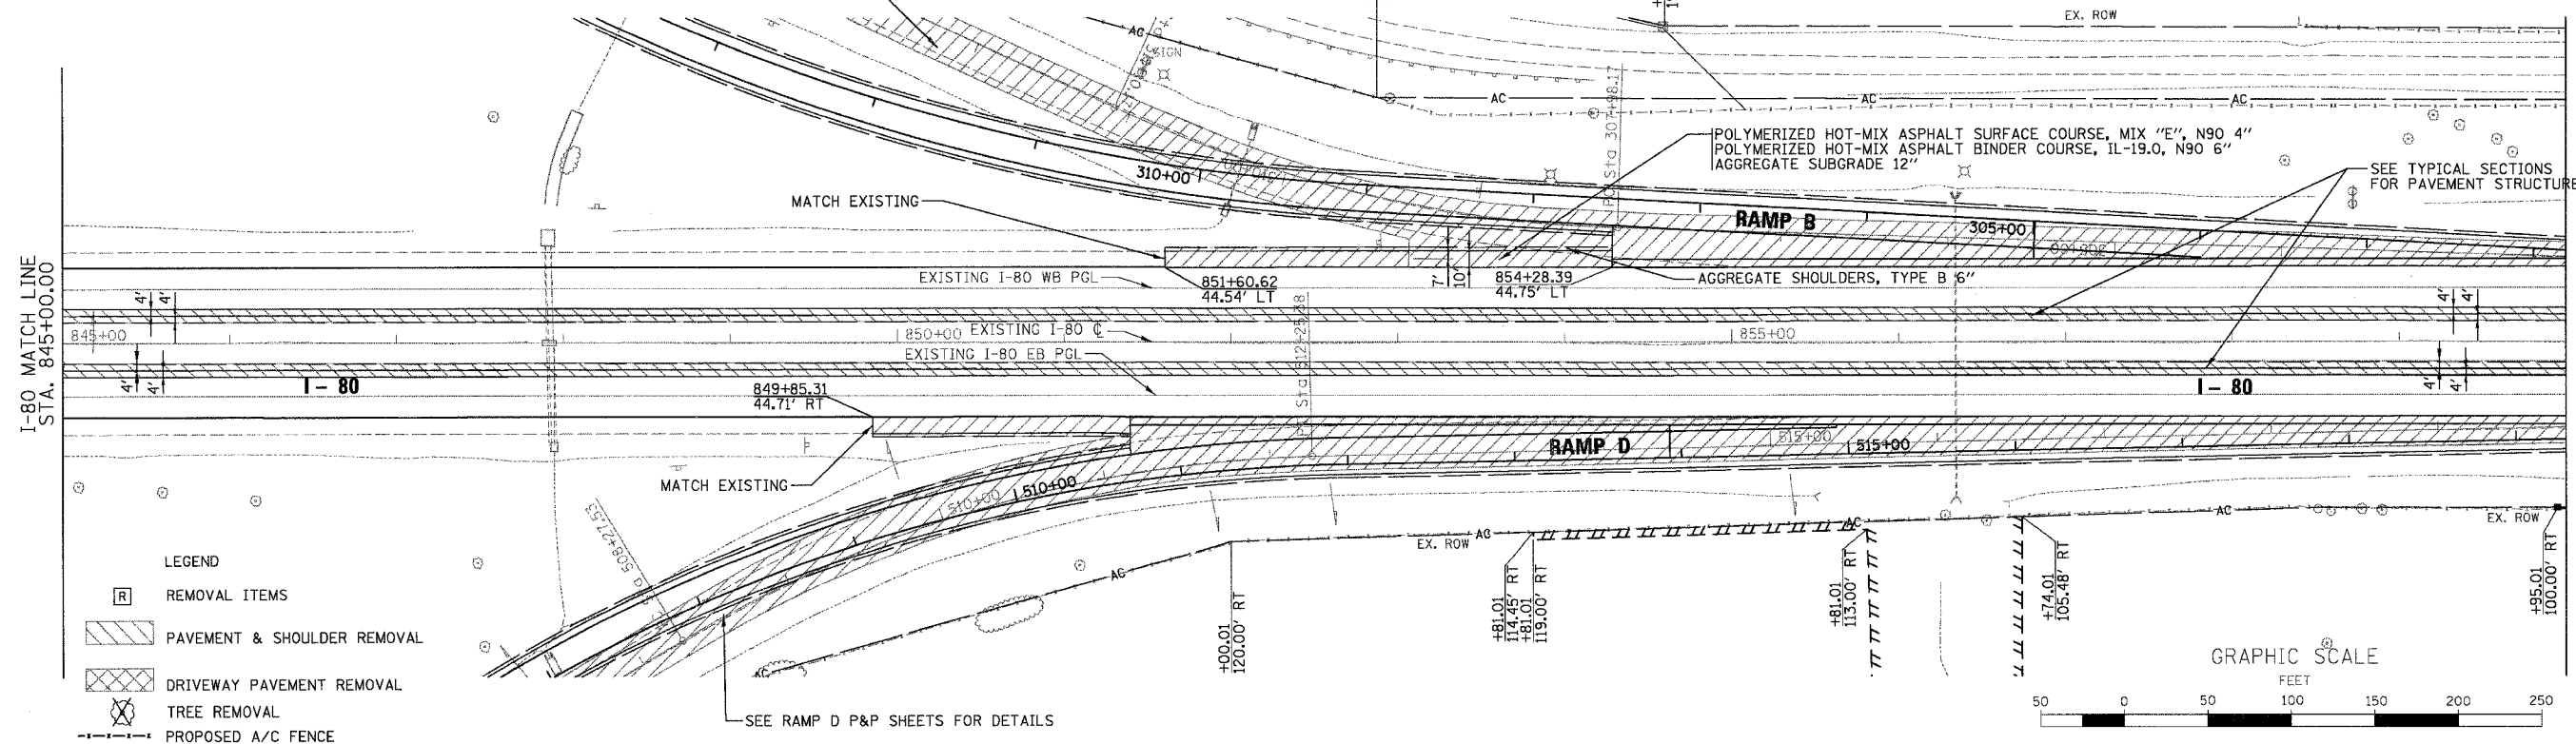

- LEGEND
- [R] REMOVAL ITEMS
  - [Hatched Box] PAVEMENT & SHOULDER REMOVAL
  - [Cross-hatched Box] DRIVEWAY PAVEMENT REMOVAL
  - [Tree Symbol] TREE REMOVAL
  - [Dashed Line] PROPOSED A/C FENCE



PROFILE	SURVEYED	BY	DATE
	NOTED		
	CHECKED		
	BY		
	NO. OF SHEETS		
	DATE		

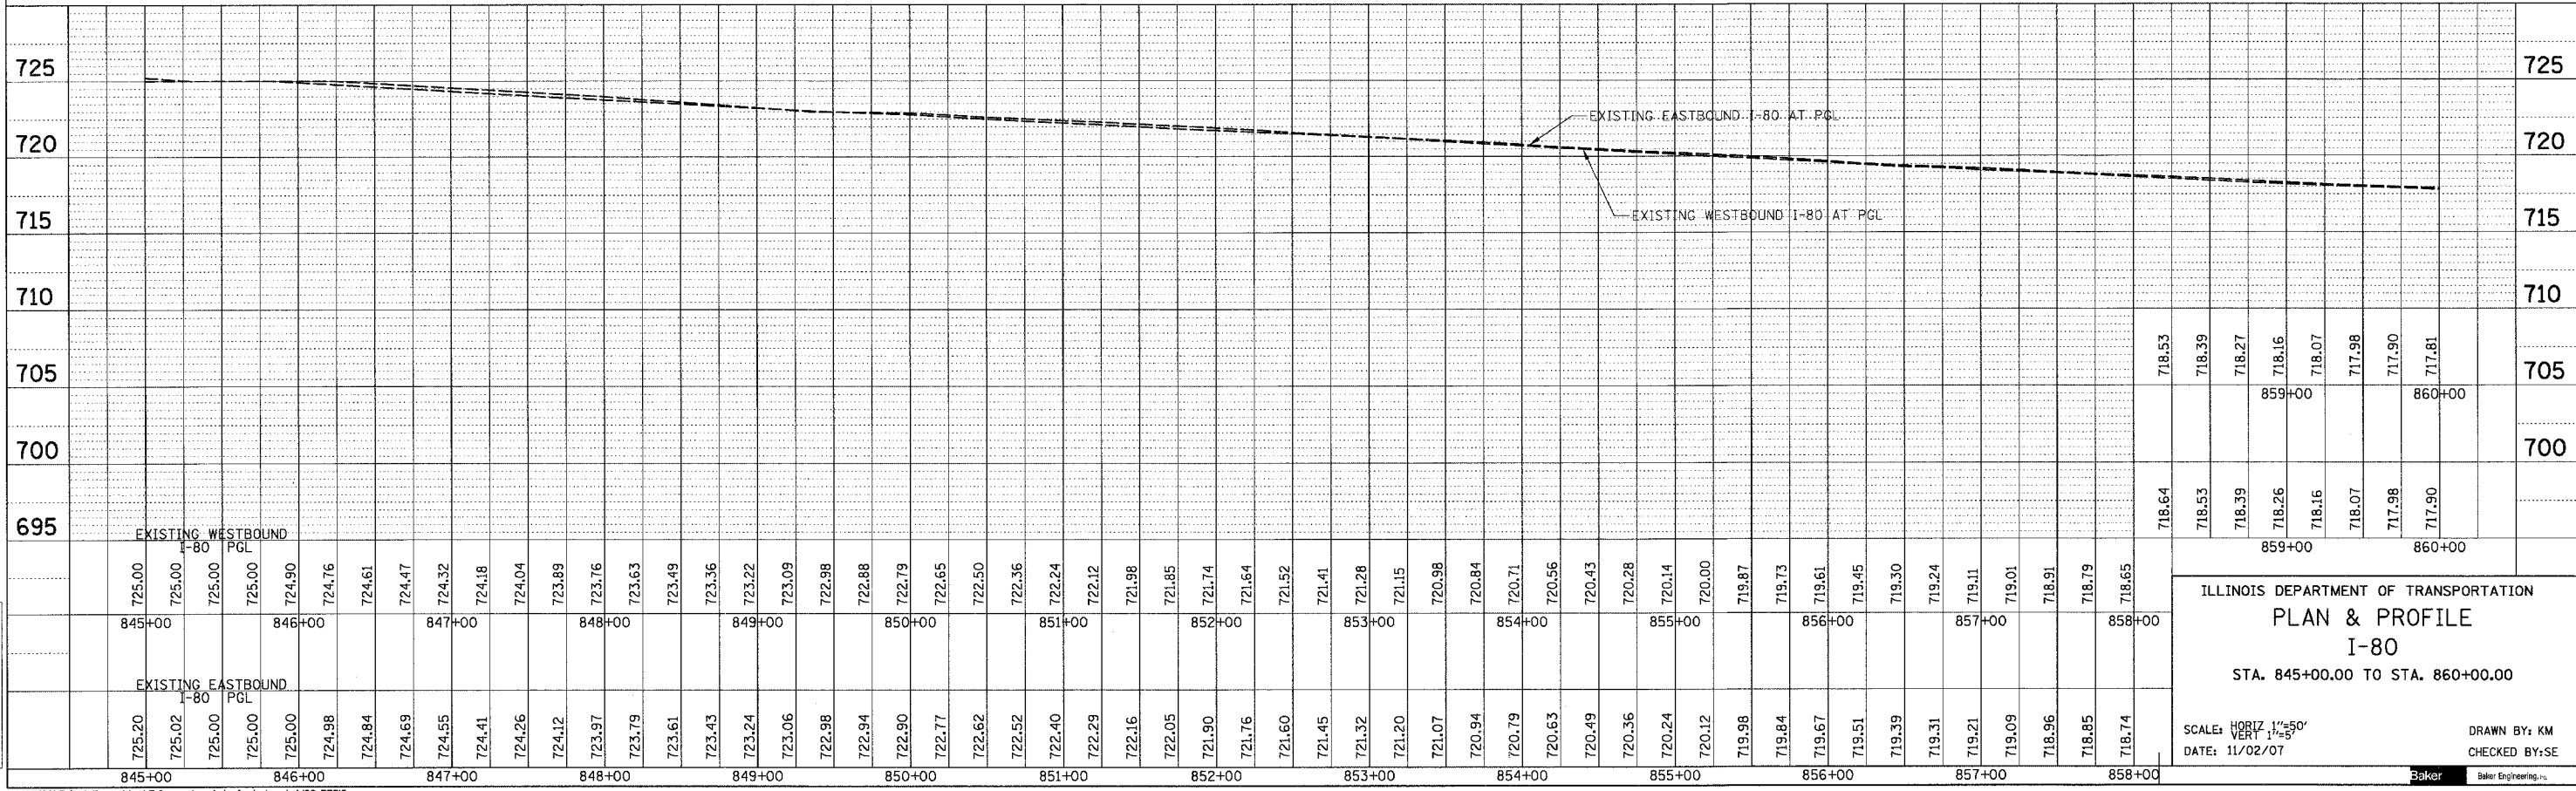

ILLINOIS DEPARTMENT OF TRANSPORTATION  
PLAN & PROFILE  
I-80  
STA. 845+00.00 TO STA. 860+00.00

SCALE: HORIZ. 1"=50'  
DATE: 11/02/07

DRAWN BY: KM  
CHECKED BY: SE



h:\07496\3.0 dellverables\3.2 roadway\design\sheet\I80.RPP16.rpp  
1/5/2007