


F.A.I. RTE.	SECTION	COUNTY	TOTAL SHEETS	SHEET NO.
*	**	SANGAMON	248	129
STA.		TO STA.		
FED. ROAD DIST. NO.		ILLINOIS FED. AID PROJECT		
• FA155(1-55), FA172(1-72), FAP666(1-55 BUS) • D6 INTERSTATE RS,BR,M CAB 2008				


SEE LIGHTING PLAN SHEETS FOR LIGHTING RELOCATION

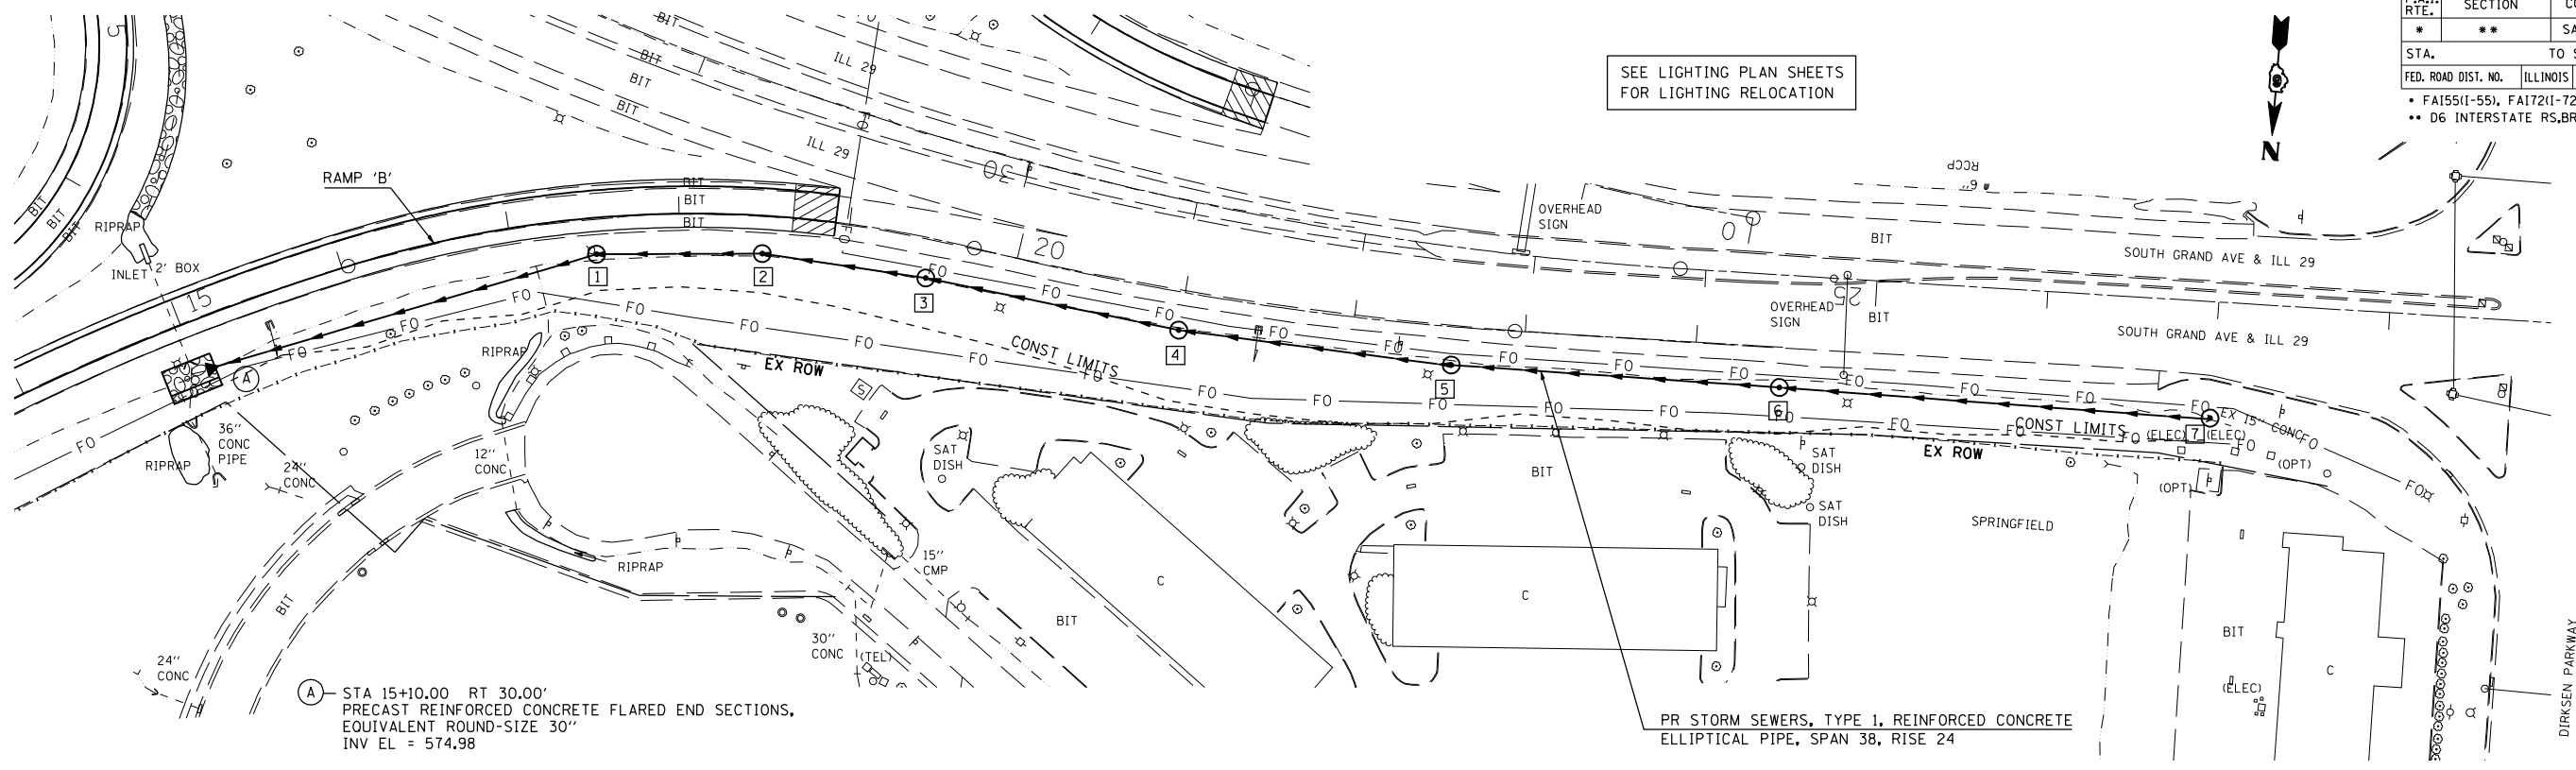

- 1- STA 17+50.00 RT 21.29' RESTRICTED DEPTH MANHOLES, 4'-DIAMETER, TYPE 8 GRATE GRATE EL = 578.05 INV EL = 574.98
- 2- STA 18+50.00 RT 22.14' RESTRICTED DEPTH MANHOLES, 4'-DIAMETER, TYPE 8 GRATE GRATE EL = 577.95 INV EL = 574.98
- 3- STA 19+50.00 RT 23.40' RESTRICTED DEPTH MANHOLES, 4'-DIAMETER, TYPE 8 GRATE GRATE EL = 578.44 INV EL = 575.47
- 4- STA 21+00.00 RT 22.21' RESTRICTED DEPTH MANHOLES, 4'-DIAMETER, TYPE 8 GRATE GRATE EL = 580.67 INV EL = 577.20
- 5- STA 22+50.00 RT 22.48' MANHOLES, TYPE A, 4'-DIAMETER, TYPE 8 GRATE GRATE EL = 583.02 INV EL = 578.56
- 6- STA 24+50.00 RT 23.48' RESTRICTED DEPTH MANHOLES, 4'-DIAMETER, TYPE 8 GRATE GRATE EL = 583.74 INV EL = 580.35
- 7- STA 27+01.60 RT 26.81' CONCRETE HEADWALL REMOVAL MANHOLES, TYPE A, 4'-DIAMETER, TYPE 8 GRATE GRATE EL = 587.14 INV EL = 582.64

PLAN	SURVEYED	DATE
	BY	
	NOTED	
	DATE	
	BY	
	DATE	
	BY	
	DATE	

PROFILE	SURVEYED	DATE
	BY	
	NOTED	
	DATE	
	BY	
	DATE	
	BY	
	DATE	

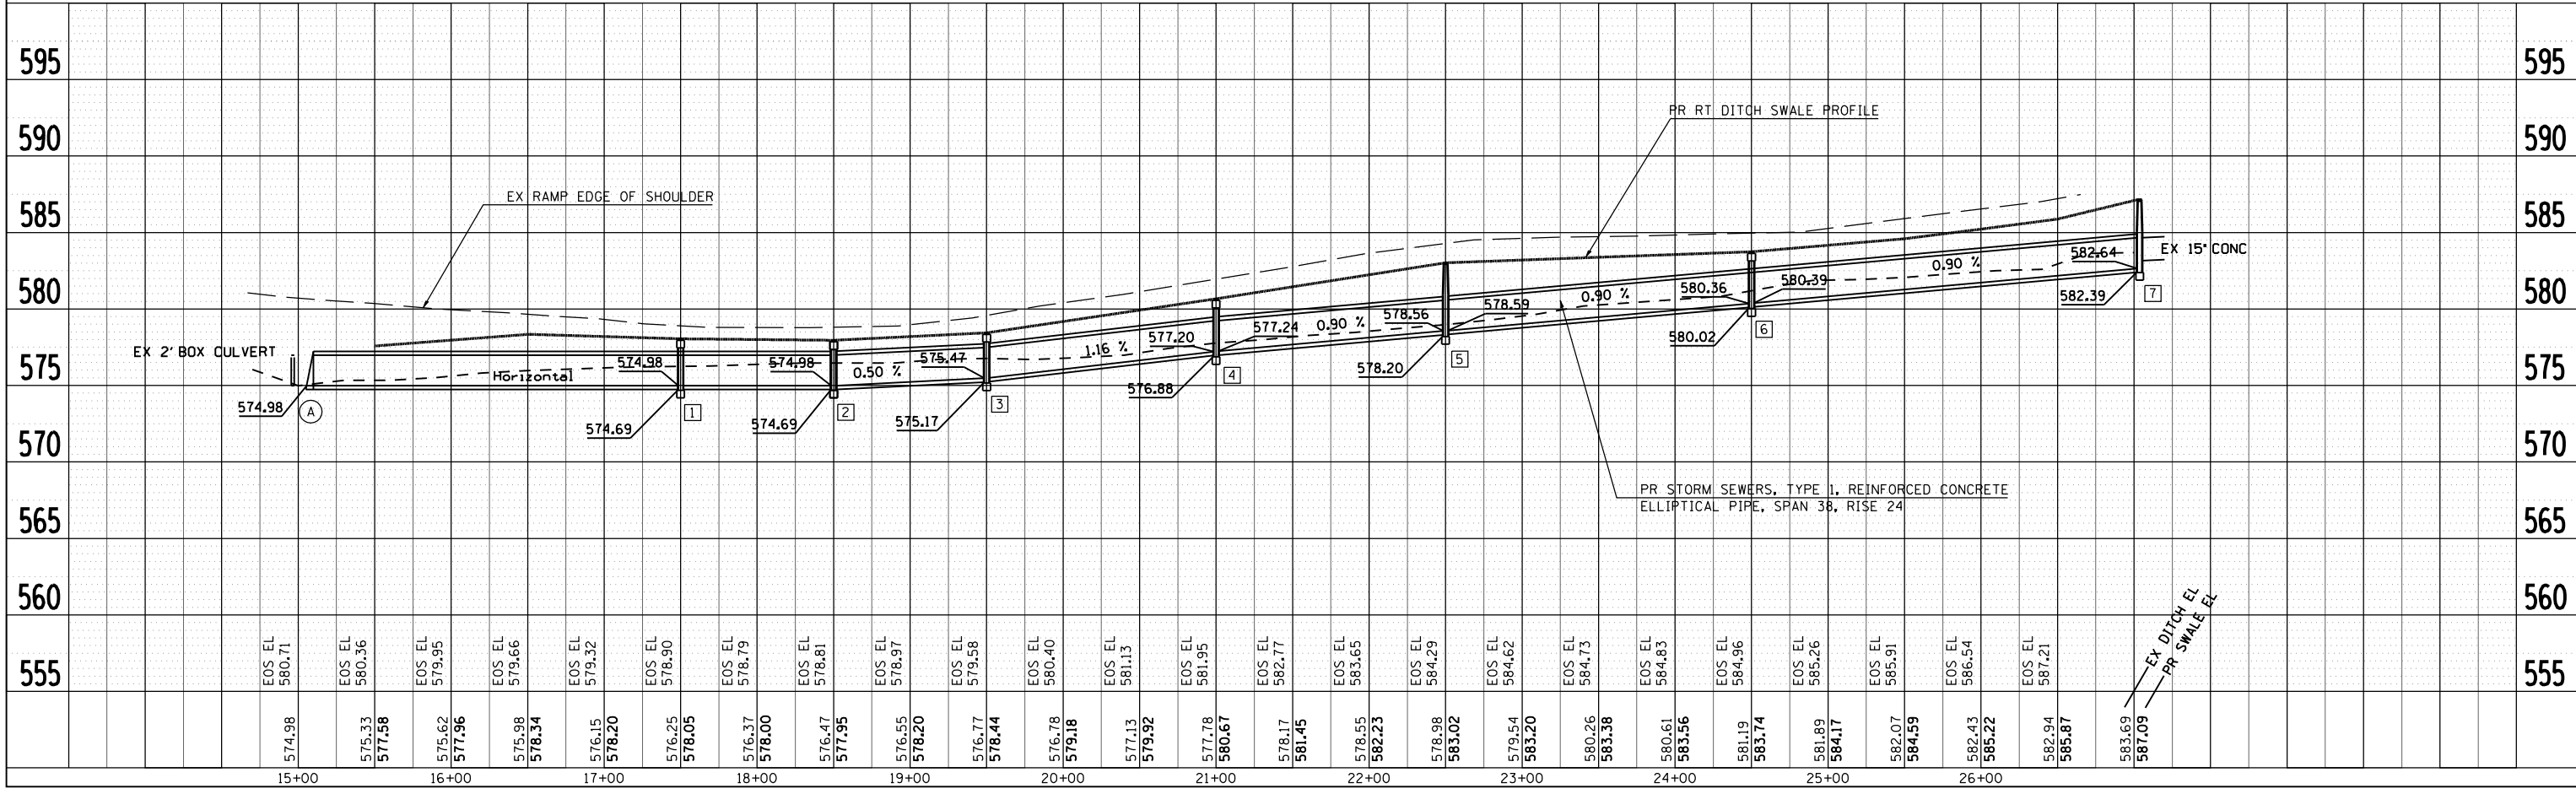

PLOT DATE = Oct-22-2007 08:25:00AM
 FILE NAME = c:\p\projects\652282\shp\of1.dgn
 PLOT SCALE = 1/8" = 1' IN.
 REFERENCE = #REF#