
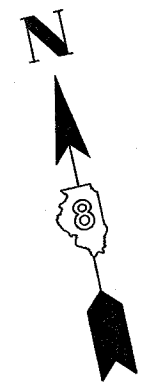


CONTRACT NO. 76B04			
F.A.I. RTE.	SECTION	COUNTY	TOTAL SHEET NO.
55/70	60-7K-2	MADISON	26-12
STA. _____		TO STA. _____	
FED. ROAD DIST. NO. ILLINOIS FED. AID PROJECT			

②

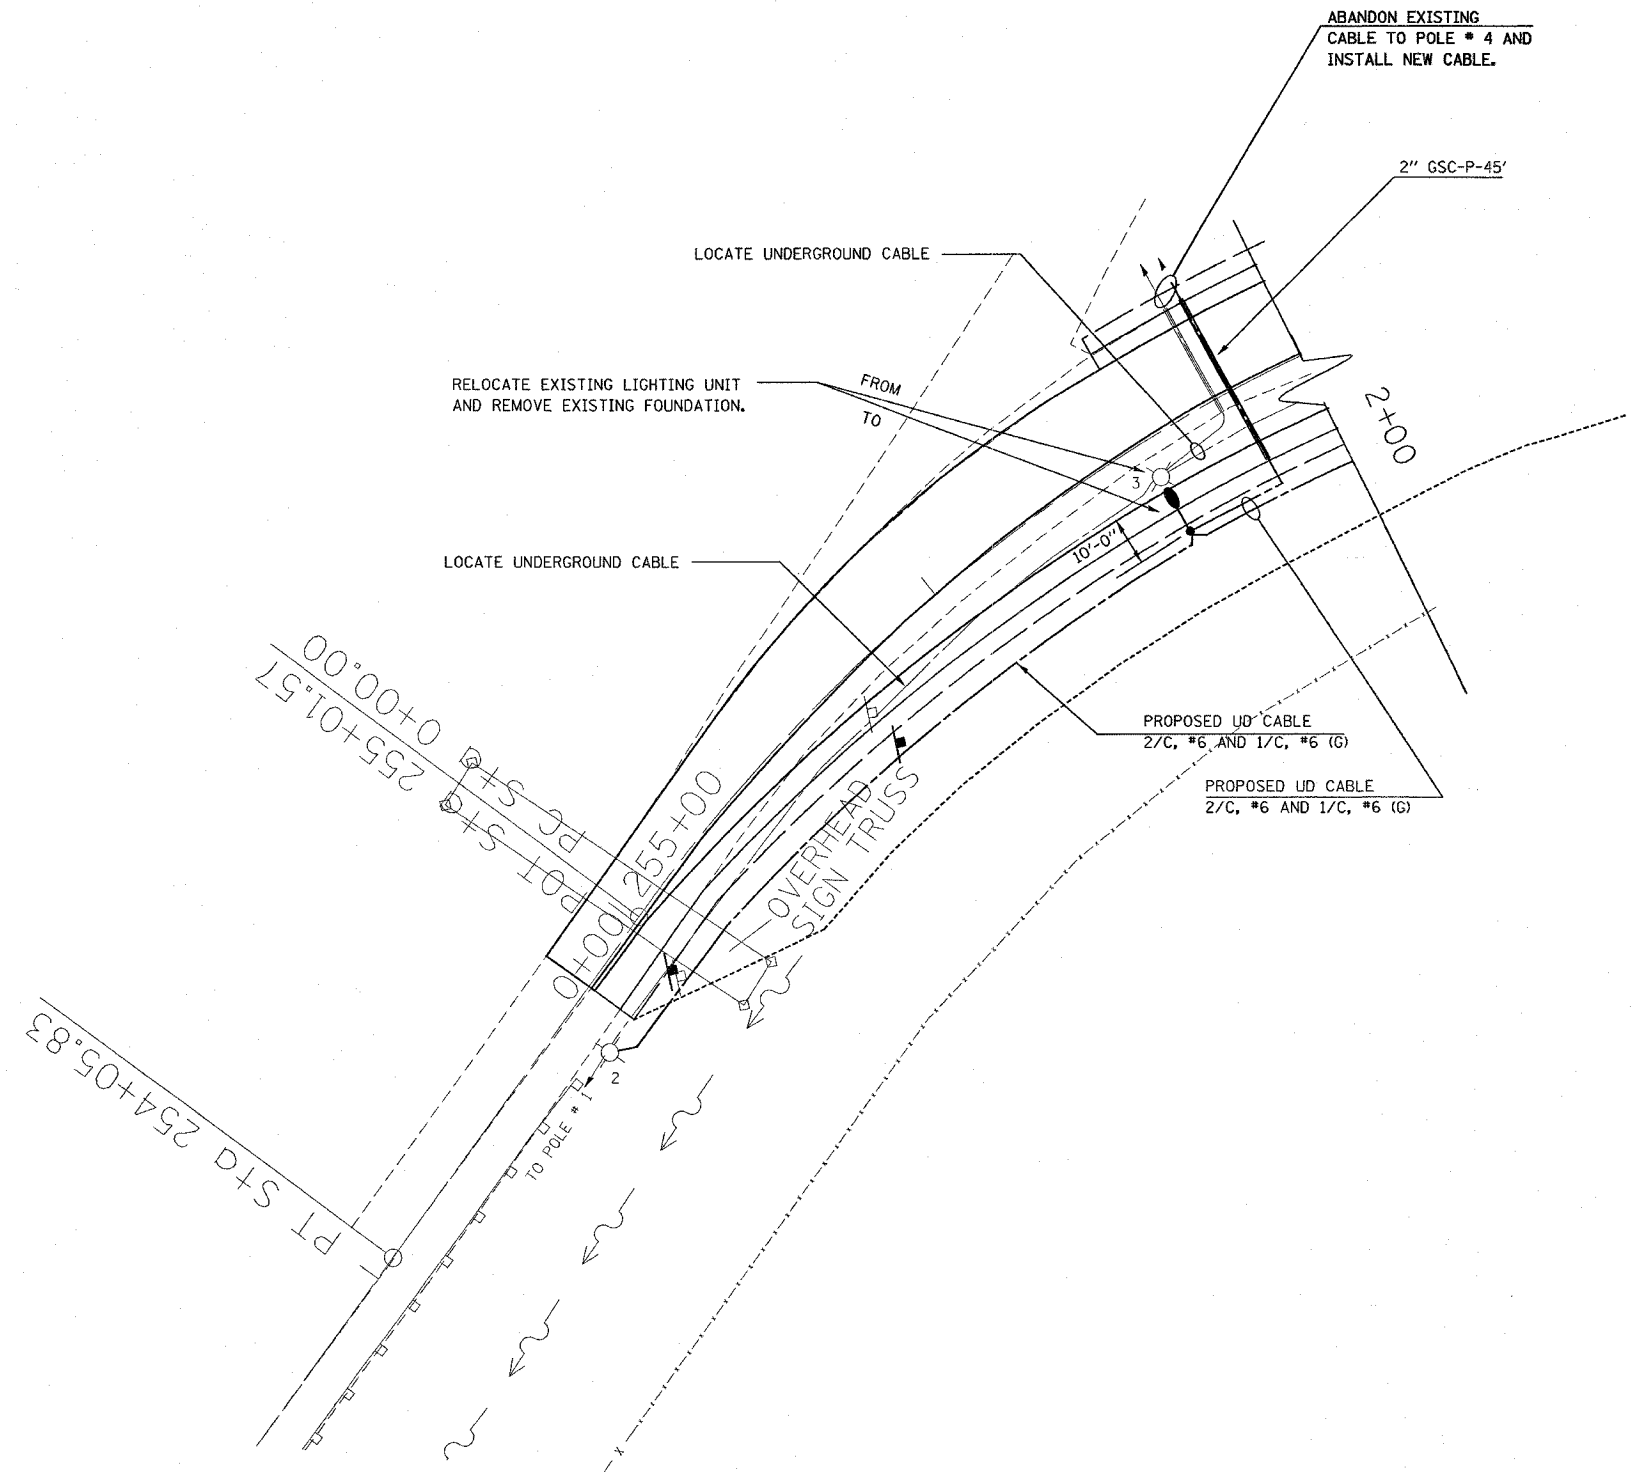

REVISIONS	
NAME	DATE

ILLINOIS DEPARTMENT OF TRANSPORTATION
LIGHTING PLAN
 FAP ROUTE 55/70
 SECTION 60-7K-2
 COUNTY MADISON

SCALE: VERT. _____
 HORIZ. _____
 DATE _____ DRAWN BY _____
 CHECKED BY _____

PLOT DATE = #DATE*
 PLOT SCALE = #SCALE*
 REFERENCE = #REF*