


EXISTING TOPOGRAPHY

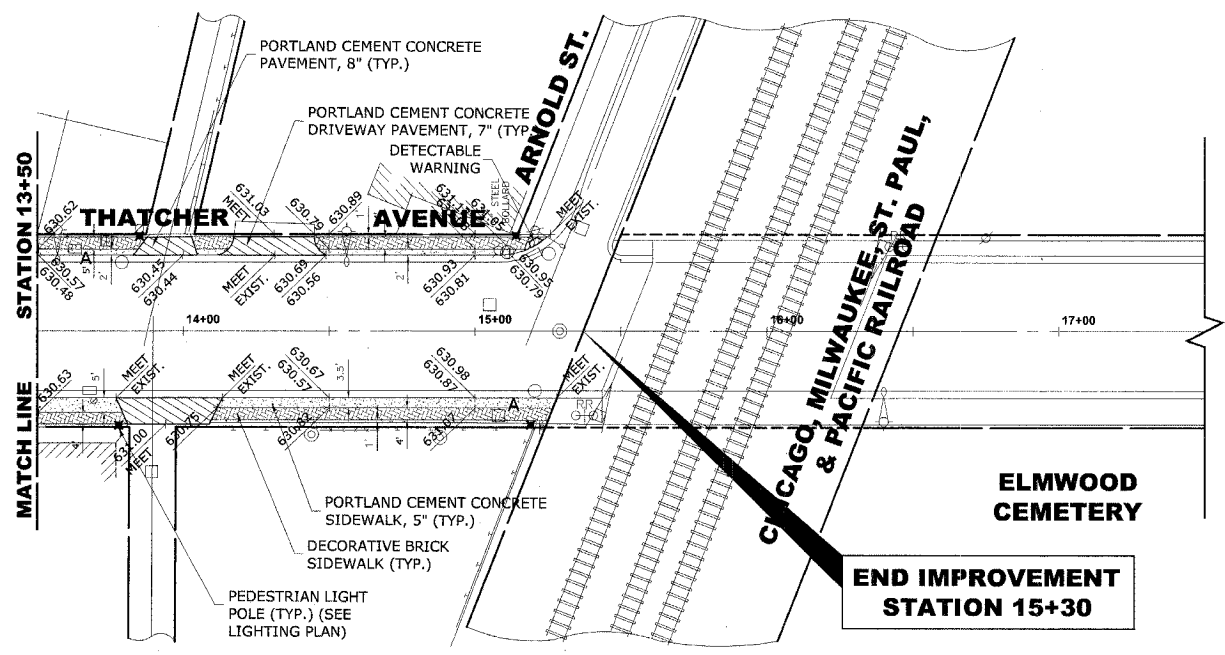

PROPOSED IMPROVEMENTS

632	EXISTING CENTERLINE	632
630		630
628		628
626		626
624		624

HANCOCK ENGINEERING

- Civil Engineers
- Municipal Consultants
- Established 1911

9933 Roosevelt Road
Westchester, Illinois 60154-2780
Phone: 708/865-0300
Fax: 708/865-1212

**GRAND AVENUE STREETSCAPE PROJECT
VILLAGE OF RIVER GROVE, ILLINOIS**

**THATCHER AVENUE
STREETSCAPING PLAN AND PROFILE**

SCALE: 1"=30'H. & 1"=2'V.
DRAWN BY: LEV/ECW/IMK
BOOK NO.: 1441,1443,1516
DATE: 10-15-07
E.H.E. NO.: 760-06-03320

REVISION:

SHEET **15** OF **35**

Drawing file: W:\Projects\76060323 - Grand Ave Streetscape\GRAV\THATCHER\GRAND-THATCHER.dwg Oct 16, 2007 - 2:38pm