
 
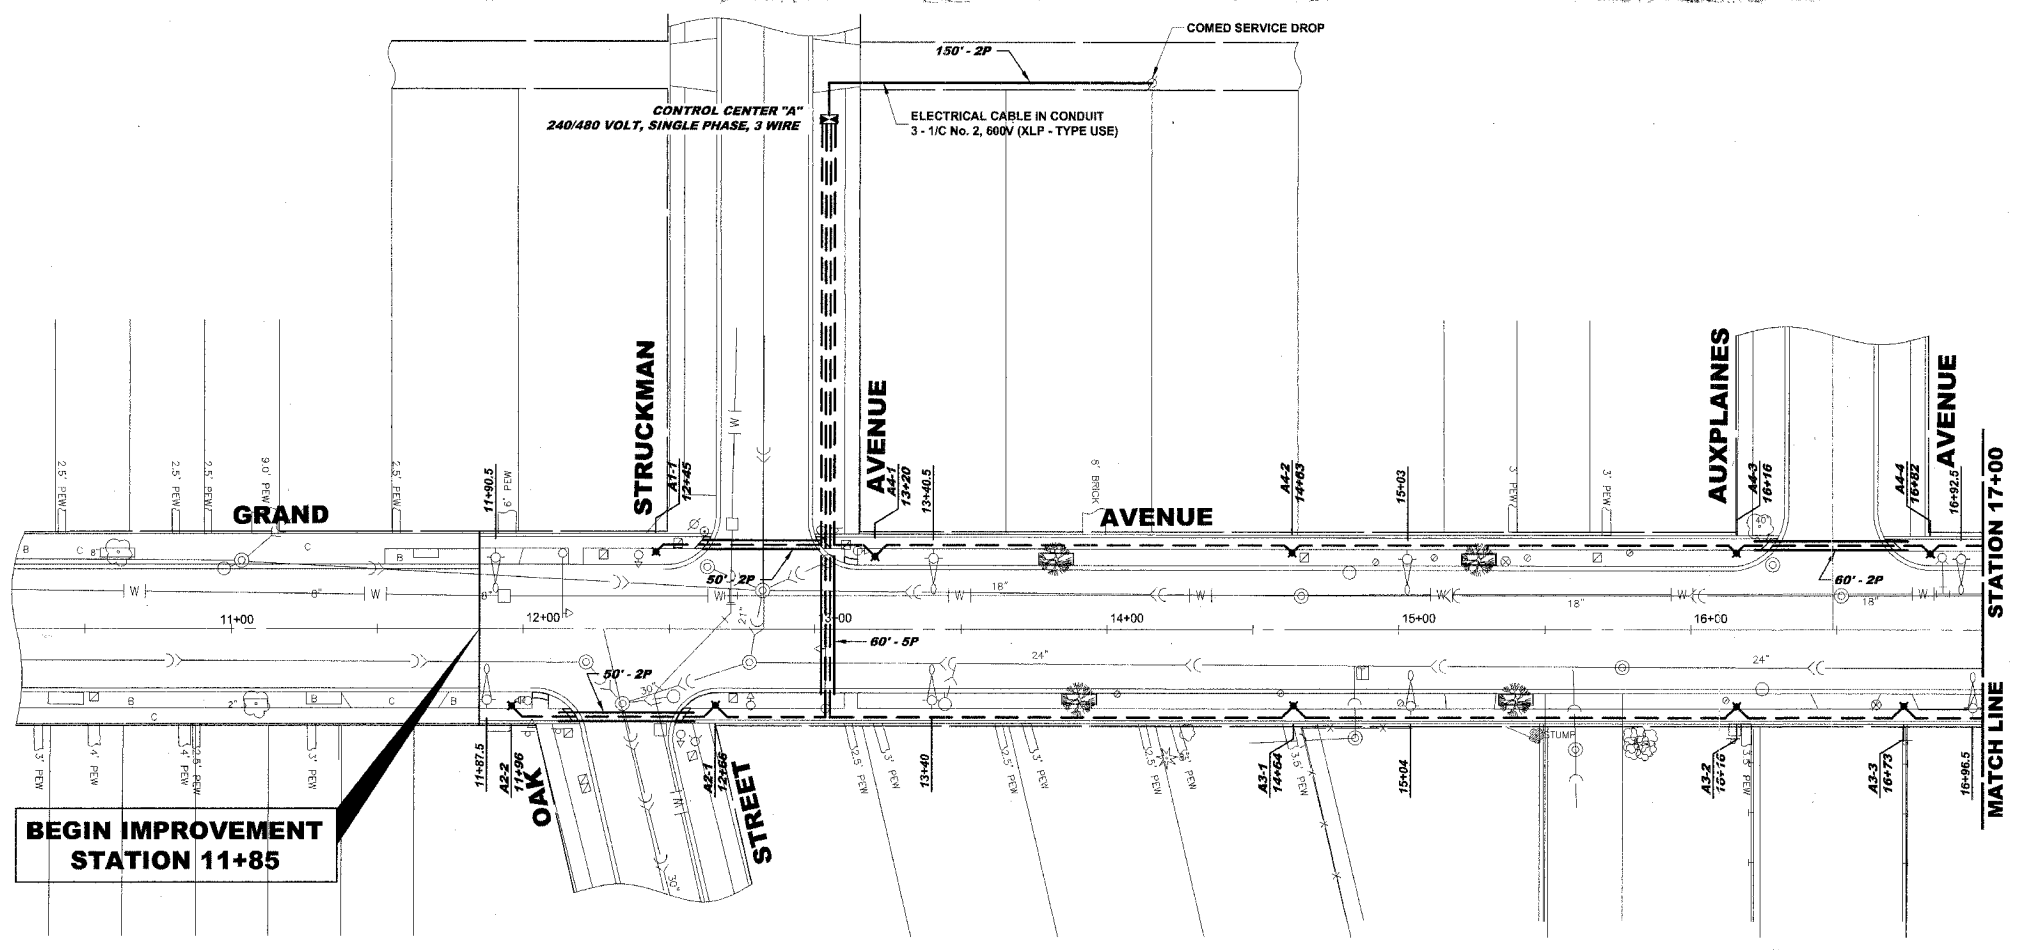


ROUTE NO.	SECTION	COUNTY	TOTAL SHEETS	SHEET NO.
FAU 1376	**	COOK	35	19
ILLINOIS PROJECT TE-00D1(754)				
VILLAGE SECTION 06-00087-00-SW				
CONTRACT NO. 83926				



LEGEND OF SYMBOLS	
	PROPOSED DECORATIVE LIGHT POLE, ALUMINUM, 12' MOUNTING HEIGHT WITH DECORATIVE ACORN STYLE LUMINAIRE, SODIUM VAPOR, TENON MOUNT, 70 WATT
	EXISTING 35' MOUNTING HEIGHT POLE WITH 8' MAST ARM AND 310 WATT HIGH PRESSURE SODIUM LAMP (GE451002.IES)
	EXISTING 35' MOUNTING HEIGHT COMBINATION TRAFFIC/LIGHT POLE WITH 12' MAST ARM AND 400 WATT HIGH PRESSURE SODIUM LAMP (GE451002.IES)
	PROPOSED CONTROL CENTER
	PROPOSED UNIT DUCT WITH 2-1/2" No. 8 & 1-1/2" No. 8 GROUND, 600V (XLP-TYPE USE), 1" DIAMETER OR AS NOTED, BORED & PULLED OR AS NOTED
	PROPOSED RIGID GALVANIZED STEEL CONDUIT IN TRENCH OR PUSHED AS NOTED
	CONTROLLER IDENTIFICATION (TYP.)
	CIRCUIT NUMBER (TYP.)
	POLE NUMBER (TYP.)
	STATION NUMBER (TYP.)

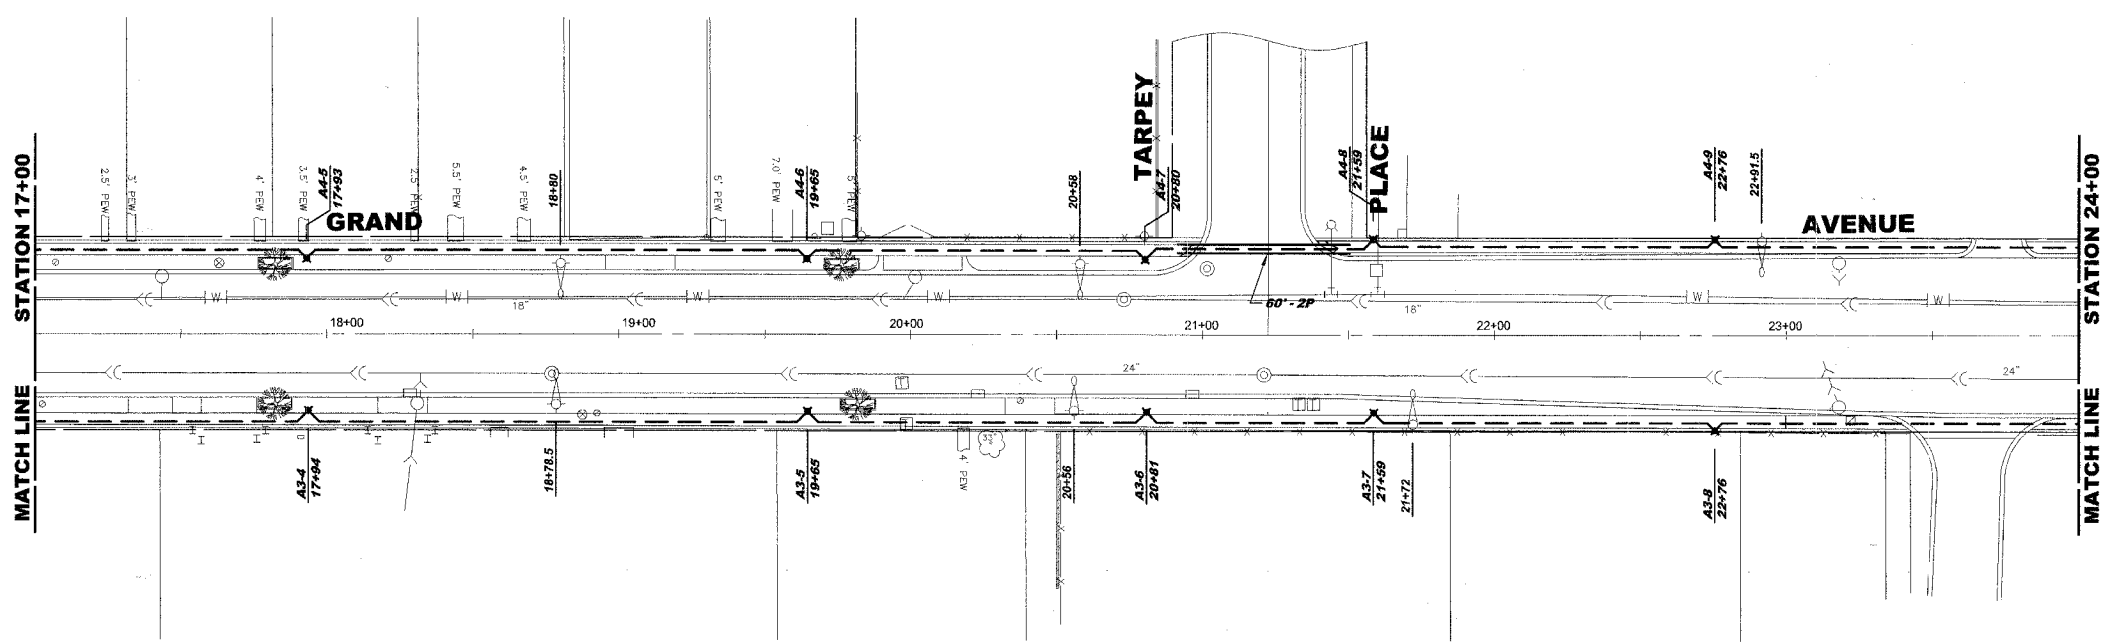

Drawing file: W:\Projects\6606033 - Grand Ave Streetscape\66060 A6-1-Lighting.dwg Oct 16, 2007 - 2:28pm

HANCOCK ENGINEERING

- ◆ Civil Engineers
- ◆ Municipal Consultants
- ◆ Established 1911

9933 Roosevelt Road
Westchester, Illinois 60154-2780
Phone: 708/865-0300
Fax: 708/865-1212

**GRAND AVENUE STREETScape PROJECT
VILLAGE OF RIVER GROVE, ILLINOIS**

GRAND AVENUE LIGHTING PLAN

SCALE:	1"=30'	SHEET	19
DRAWN BY:	LEV/ECW/MK	OF	35
BOOK NO.:	1441,1443,1516		
DATE:	10-15-07		
REVISION:			
E.H.E. NO.:	760-06-03320		